

ORD 25-1974 Exhibit B

TENANT IMPROVEMENT FOR:

REBEL

STORE NO: 0868

AT 1300 W. NORMANTOWN RD.

ROMEOVILLE, IL 60446

SITE LOCATION




Code Officials; If you have any questions regarding these plans please contact dvater@carenterprises.net



1450 N. Benson Ave.,
Upland, CA 91786 USA
www.anabioil.com - (909) 394-4728

REVISION #:	DESIGNER:	PAGE:
32	DV	CS
STORE #:	DATE:	SCALE:
868	02-05-2025	NTS

PROJECT FILE NAME:
REBEL REMODEL WITH DRIVE-THRU & GAMING
PROJECT ADDRESS:
1300 W. NORMANTOWN RD. ROMEOVILLE, IL

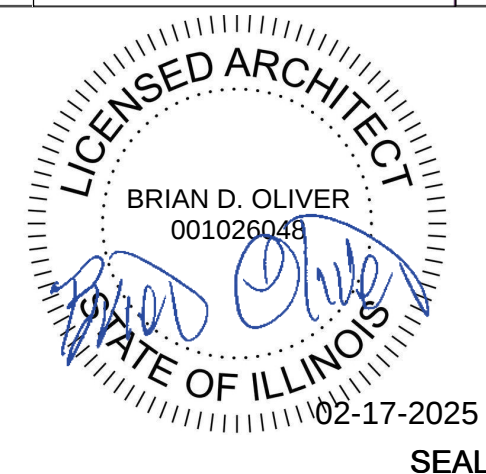

DRAWING INDEX

CODE DATA

PROJECT DIRECTORY


<u>ARCHITECTURAL</u>	
CS	COVER SHEET
GC-1	GENERAL NOTES
SP0.1	PROPOSED SIGNAGE - SITE PLAN
SP1.0	EXISTING SITE PLAN
SP1.1	DEMO SITE PLAN
SP2.0	OVERALL PROPOSED SITE PLAN
SP2.1	ENLARGED PROPOSED SITE PLAN
SP3.0	PROPOSED SITE PLAN - AAHSTO TRUCK ROUTE
D1.0	EXISTING / DEMO DIMENSION PLAN
D1.1	DEMO REFLECTED CEILING PLAN
LS1.0	LIFE SAFETY PLAN
A1.0	PROPOSED DIMENSION FLOOR PLAN
A1.1	PROPOSED NOTED FLOOR PLAN
A2.0	ROOF PLAN
A3.0	INTERIOR ELEVATIONS
A3.1	INTERIOR LED SCREEN DETAILS
A3.2	SALES COUNTER PLAN, ELEVATIONS, AND DETAILS
A4.0	REFLECTED CEILING PLAN
A5.1	DETAILS
A6.0	EXTERIOR ELEVATION
A7.0	DOOR SCHEDULE AND DETAILS
<u>MPE</u>	
M1.1	MECHANICAL FLOOR PLAN
M1.2	MECHANICAL ROOF PLAN
M1.3	MECHANICAL DETAILS
M2.1	HOOD DETAILS & SCHEDULES
M2.2	HOOD FIRE SUPPRESSION SYSTEM DETAILS
M2.3	HOOD EXHAUST FAN DETAILS & SCHEDULES
M2.4	MAKEUP AIR UNIT DETAILS & SCHEDULES
P1.1	PLUMBING PROPOSED PLAN
P1.2	PLUMBING DETAILS & NOTES
E0.0	ELECTRICAL GENERAL NOTES
E1.0	ELECTRICAL LIGHTING PLAN
E2.0	ELECTRICAL POWER PLAN
E3.0	SCHEDULE AND PANEL CALCS
E4.0	ELECTRICAL SPECIFICATIONS

PROJECT INFO

TENANT IMPROVEMENT CONSISTS OF DEMOLITION OF EXISTING C-STORE EQUIPMENT, FIXTURES, DISPLAYS, FINISHES, ETC... IN PREPARATION FOR NEW RE-BRANDING / REMODEL WITH GAMING AND DRIVE THRU FOR QSR. KITCHEN AREA TO BE MODIFIED AS PLANS INDICATE TO ACCOMMODATE NEW MERCHANDISE AREA. EXISTING MECHANICAL UNITS TO BE REPLACED WITH EQUAL SIZED & WEIGHTED UNITS. NO CHANGE IN BUILDING USE OR OCCUPANCY PROPOSED AS PART OF T.I. SCOPE.

APN:	12-02-31-200-017-0000
CONSTRUCTION TYPE:	V-B
OCCUPANCY CLASS:	MERCANTILE
SPRINKLERED:	NON-SPRINKLERED
SALES FLOOR SQ FT:	2595
TOTAL BUILDING SQ FT:	4646
OCCUPANT LOAD:	54
NUMBER OF STORIES:	1 (ACTUAL)
BUILDING HEIGHT:	20'-0"
NUMBER OF EXITS:	4 (SEE SHEET A1.0)

VICINITY MAP

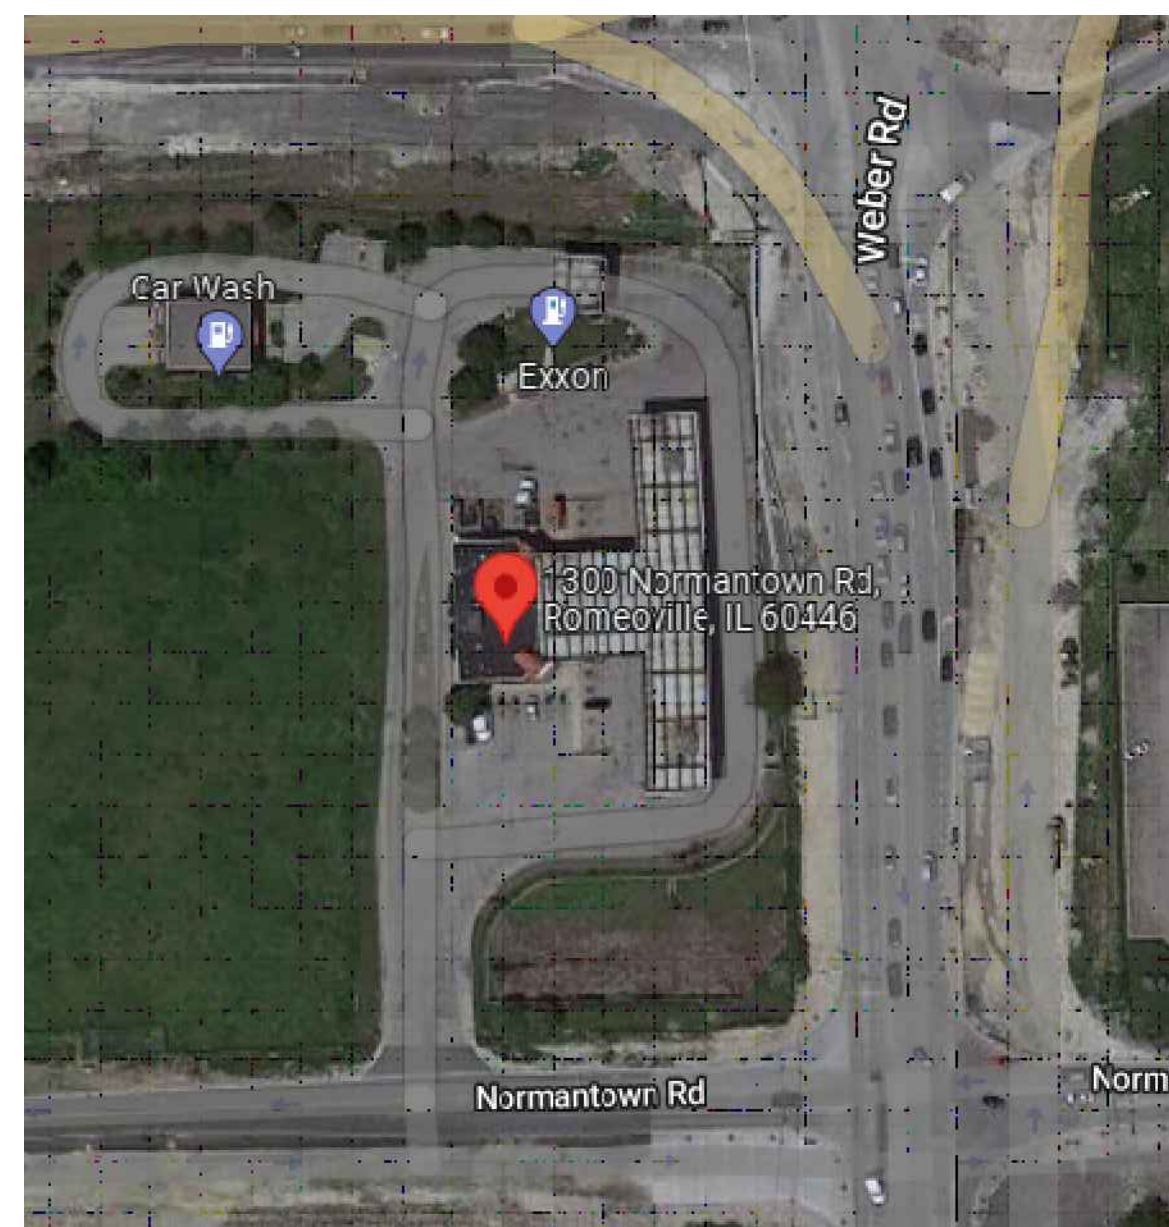

BUILDING CODES

2021 EXISTING INTERNATIONAL BUILDING CODE

2021 INTERNATIONAL BUILDING CODE

2021 INTERNATIONAL CONSERVATION CODE

2021 INTERNATIONAL MECHANICAL CODE

2014 ILLINOIS STATE PLUMBING CODE

2020 NFPA 70 NATIONAL ELECTRIC CODE

2019 NFPA 72 NATIONAL FIRE ALARM &
SIGNALING CODE

2019 NFPA 13 STANDARD FOR THE INSTALLATION
OF SPRINKLER SYSTEMS

2021 INTERNATIONAL FIRE CODE

ACCESSIBILITY: 2009 ICC/ANSI A117.1

VILLAGE OF ROMEVILLE CODE OF ORDINANCES
CHAPTER 91 – FIRE PREVENTION

GENERAL NOTES

THESE DRAWINGS AND SPECIFICATIONS ARE PROPERTY OF ANABI OIL CORPORATION, LLC AND MAY NOT BE REPRODUCED OR USED FOR ANY PURPOSE, WITHOUT ANABI DESIGN’S WRITTEN CONSENT. AS INSTRUMENTS OF SERVICE, THESE DOCUMENTS ARE NOT FINAL AND READY FOR USE, AND THEREFORE NOT VALID, UNLESS THEY ARE SEALED, SIGNED, AND DATED BY AOR.

THE CONTRACTOR SHALL CHECK AND VERIFY ALL DIMENSIONS AND REPORT ALL ERRORS TO THE DESIGN PROFESSIONAL PRIOR TO COMMENCING WORK. THESE DRAWINGS ARE NOT TO BE SCALED. WRITTEN DIMENSIONS SHALL HAVE PRECEDENCE OVER SCALED DIMENSIONS.

UPON ENTERING THE SITE AND COMMENCING WORK THE CONTRACTOR REPRESENTS THAT HE HAS VISITED, FAMILIARIZED HIMSELF WITH THE CONDITIONS AND LAWS, CODES, AND GOVERNMENTAL AGENCY REGULATIONS UNDER WHICH THE WORK IS TO BE PERFORMED, AND CORRELATED HIS OBSERVATIONS WITH THE REQUIREMENTS OF THE CONTRACT DOCUMENTS AND ACCEPTS THE SITE "AS-IS."

PRIOR TO BIDDING, THE CONTRACTOR SHALL VERIFY ALL DIMENSIONS AND FIELD CONDITIONS AT THE JOB SITE AND NOTIFY THE GENERAL CONTRACTOR OF ANY DISCREPANCIES.

THE CONTRACTOR SHALL CONTINUOUSLY MAINTAIN ADEQUATE PROTECTION OF ALL HIS WORK FROM DAMAGE AND PROPERTY LOSS.

THE CONTRACTOR SHALL ERECT AND PROPERLY MAINTAIN AT ALL TIMES, AS REQUIRED BY THE CONDITIONS AND PROGRESS OF THE WORK, ALL NECESSARY SAFEGUARDS FOR THE PROTECTION OF WORKMEN AND THE PUBLIC AND SHALL POST DANGER SIGNS WARNING AGAINST THE HAZARDS CREATED BY, BUT NOT LIMITED TO, SUCH FEATURES OF CONSTRUCTION AS PROTRUDING NAILS, HOISTS, WELL HOLES, SCAFFOLDING, WINDOW OPENINGS, STAIRWAYS, AND FALLING MATERIALS.

ALL MATERIALS AND EQUIPMENT SHALL BE FREE FROM DEFECTS, AND SHALL BE DELIVERED TO THE SITE IN THE ORIGINAL MANUFACTURER’S CONTAINERS, MATERIALS AND EQUIPMENT SHALL BE STORED OFF THE GROUND AND PROTECTED FROM DAMAGE.

IT IS THE VENDORS RESPONSIBILITY TO INSURE THAT THEIR MATERIALS OR FIXTURES ARE DELIVERED TO THE JOB SITE UNDAMAGED. IN THE EVEN THAT DAMAGE OCCURS DURING SHIPPING, THE VENDOR SHALL REPLACE ALL DAMAGED MATERIAL OR FIXTURES IMMEDIATELY AT NO COST TO OWNER OR THE CONTRACTOR ANY CLAIMS AGAINST THE SHIPPER FOR DAMAGE THAT OCCURS DURING THE SHIPPING SHALL BE MADE BY THE VENDOR DIRECTLY TO THE SHIPPER.

ALL VENDORS WHOSE MATERIALS OR FIXTURES ARE TO BE INSTALLED BY THE CONTRACTOR SHALL VERIFY DELIVERY DATES WITH THE CONTRACTOR’S ON SITE REPRESENTATIVE IMMEDIATELY UPON RECEIPT OF AN APPROVED PURCHASE ORDER FROM OWNER.

ABSOLUTELY NO SMOKING OR ALCOHOL CONSUMPTION IS TO BE ALLOWED ON THIS JOB SITE. IT IS THE GENERAL CONTRACTORS RESPONSIBILITY TO INSURE THAT ALL EMPLOYEES, VENDORS, AND SUBCONTRACTORS COMPLY WITH THIS RESTRICTION.

DRAWINGS ARE NOT TO BE SCALED, ANY DISCREPANCIES ARE TO BE BROUGHT TO THE GENERAL CONTRACTOR’S ATTENTION.

INTERIOR FINISHES SHALL CONFORM WITH I.B.C. CHAPTER 8.

THE GENERAL CONTRACTOR SHALL PROVIDE FIRESTOPPING BETWEEN OPEN VERTICAL PARTITIONS AND HORIZONTAL SPACES ABOVE FINISHED CEILING.

ALL WOOD BLOCKING SHALL BE FIRE RETARDANT.

ALL GYPSUM BOARD SHALL BE 5/8” TYPE ‘X’. PROVIDE VERTICAL CONTROL JOINTS TA 20’–0” ON CENTER MIN. AT WALLS. PROVIDE RATED JOINT DETAIL EQUAL TO WALL RATING IF REQUIRED

ALL ROOF PENETRATIONS FOR ANY PURPOSE SHALL BE PERFORMED BY THE DEVELOPER’S ROOFER AND PAID FOR BY THE GENERAL CONTRACTOR.

ALL PENETRATIONS THROUGH ONE–HOUR RATED WALLS, CEILINGS, DOORS, SHALL COMPLY WITH THE REQUIREMENTS OF THE FIRE DEPARTMENT & IBC.

PLACE A DURABLE SIGN WITH LETTERING ON A CONTRASTING BACKGROUND OVER ALL EXIT DOORS WHICH STATE: ”THIS DOOR TO REMAIN UNLOCKED WHEN BUILDING IS OCCUPIED.”

CONTRACTOR TO VERIFY ALL ELECTRICAL AND COMMUNICATION REQUIREMENTS PRIOR TO STARTING PROJECT – ALL DISCREPANCIES ARE TO BE BROUGHT TO THE OWNER’S ATTENTION.

CONTRACTOR TO VERIFY FLOOR CONDITION PRIOR TO STARTING CONSTRUCTION – FLOOR TO HAVE SMOOTH FINISH PER FLOORING MFR. REQUIREMENTS.


ALL DIMENSIONS ON FLOOR PLAN SHALL BE TO FINISH FACE OF WALL. – TYP. U.N.O.

ALL CORRESPONDENCE BETWEEN SUBCONTRACTORS, AND ENGINEER / ARCHITECT SHALL BE COORDINATED THRU THE GENERAL CONTRACTOR AND ARCHITECT DURING CONSTRUCTION.




1450 N. Benson Ave.,
Upland, CA 91786 USA
www.anabioil.com • (909) 394-4728

PAGE:	GC-1	SCALE:	NTS
DESIGNER:	DV	DATE:	02-05-2025
REVISION #:	32	STORE #:	868
PROJECT FILE NAME:	REBEL REMODEL WITH DRIVE-THRU & GAMING	PROJECT ADDRESS:	1300 W. NORMANTOWN RD. ROMEOVILLE, IL

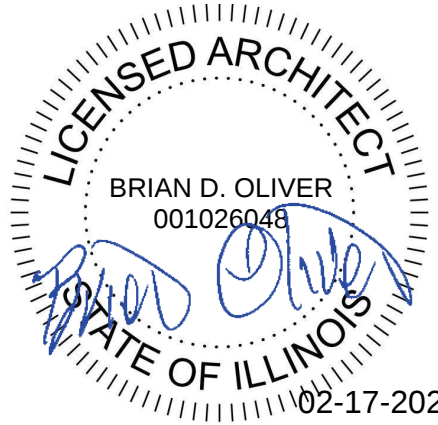

SEAL

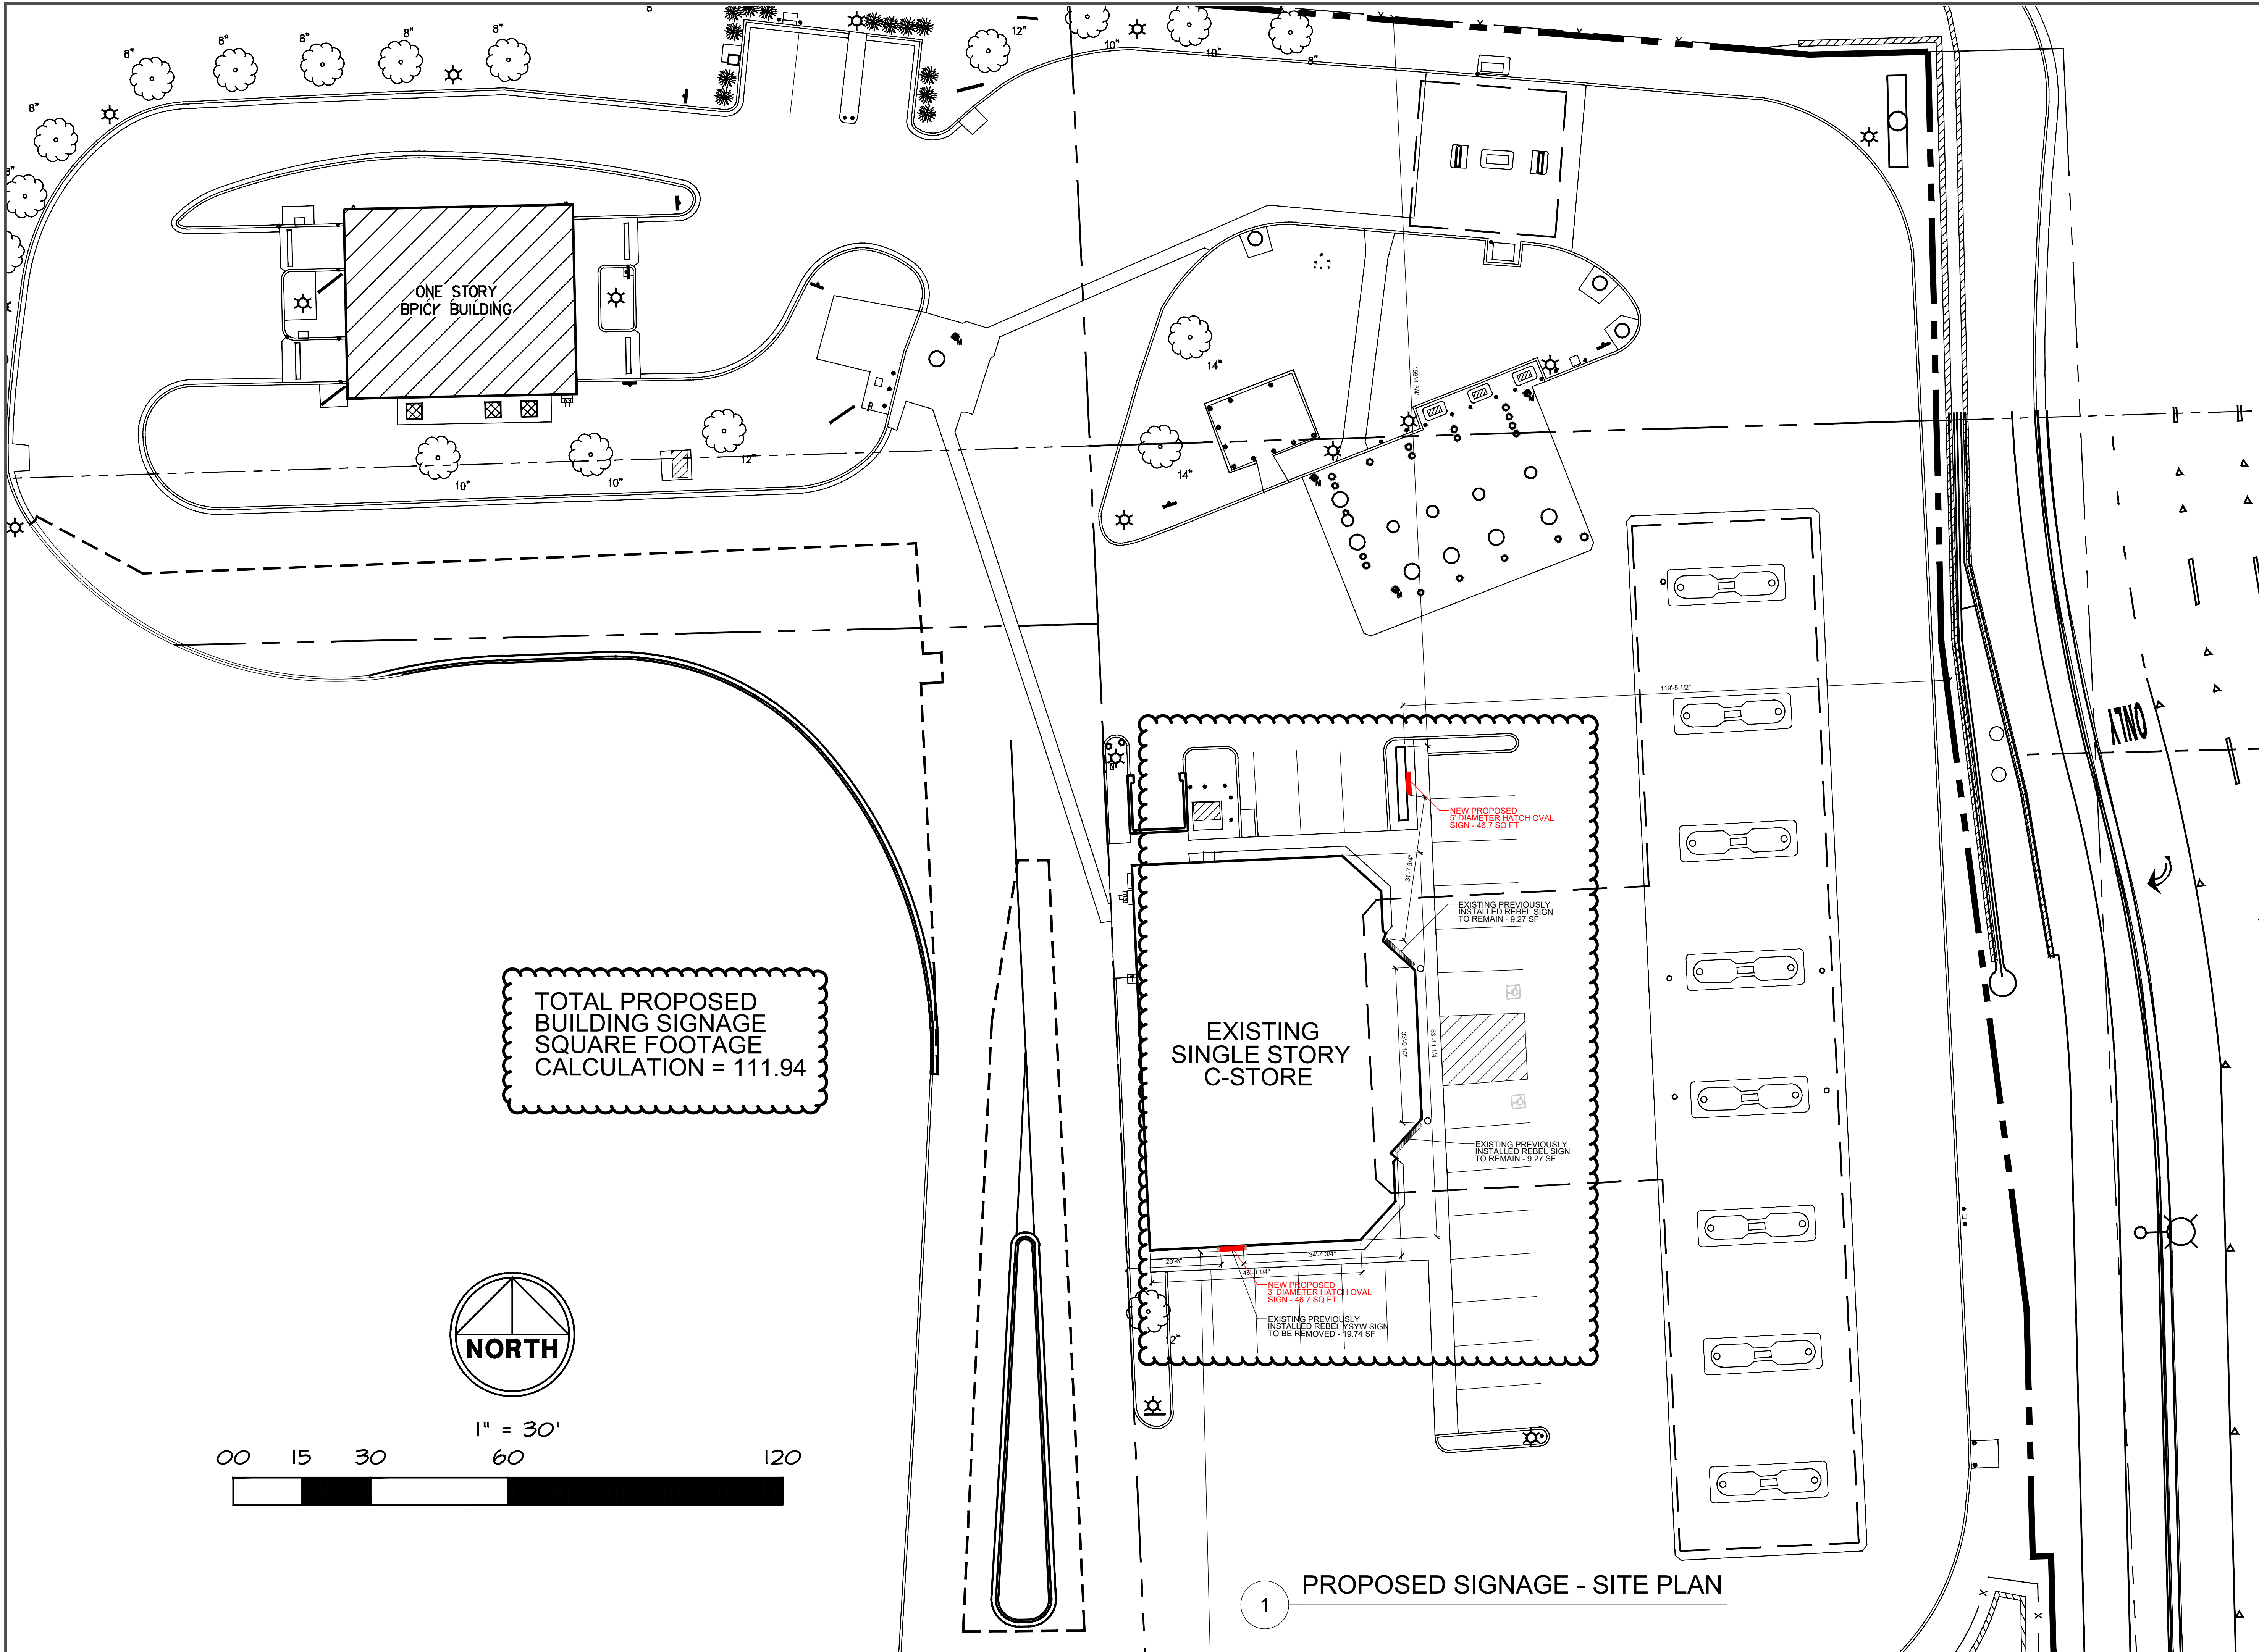


1 PROPOSED SIGNAGE - SITE PLAN




1450 N. Benson Ave.,
Upland, CA 91786 USA
www.anabioli.com - (909) 394-4728


PROJECT FILE NAME:	REBEL REMODEL WITH DRIVE-THRU & GAMING	REVISION #:	DESIGNER:	PAGE:
PROJECT ADDRESS:	1300 W. NORMANTOWN RD. ROMEOVILLE, IL	32	DV	SP0.1
		STORE #:	DATE:	SCALE:
		868	02-05-2025	1/16" = 1'-0"

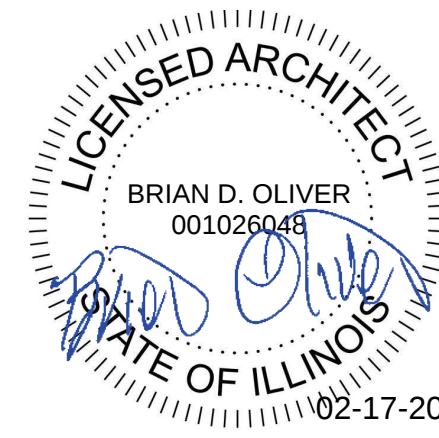

02-17-2025
SEAL

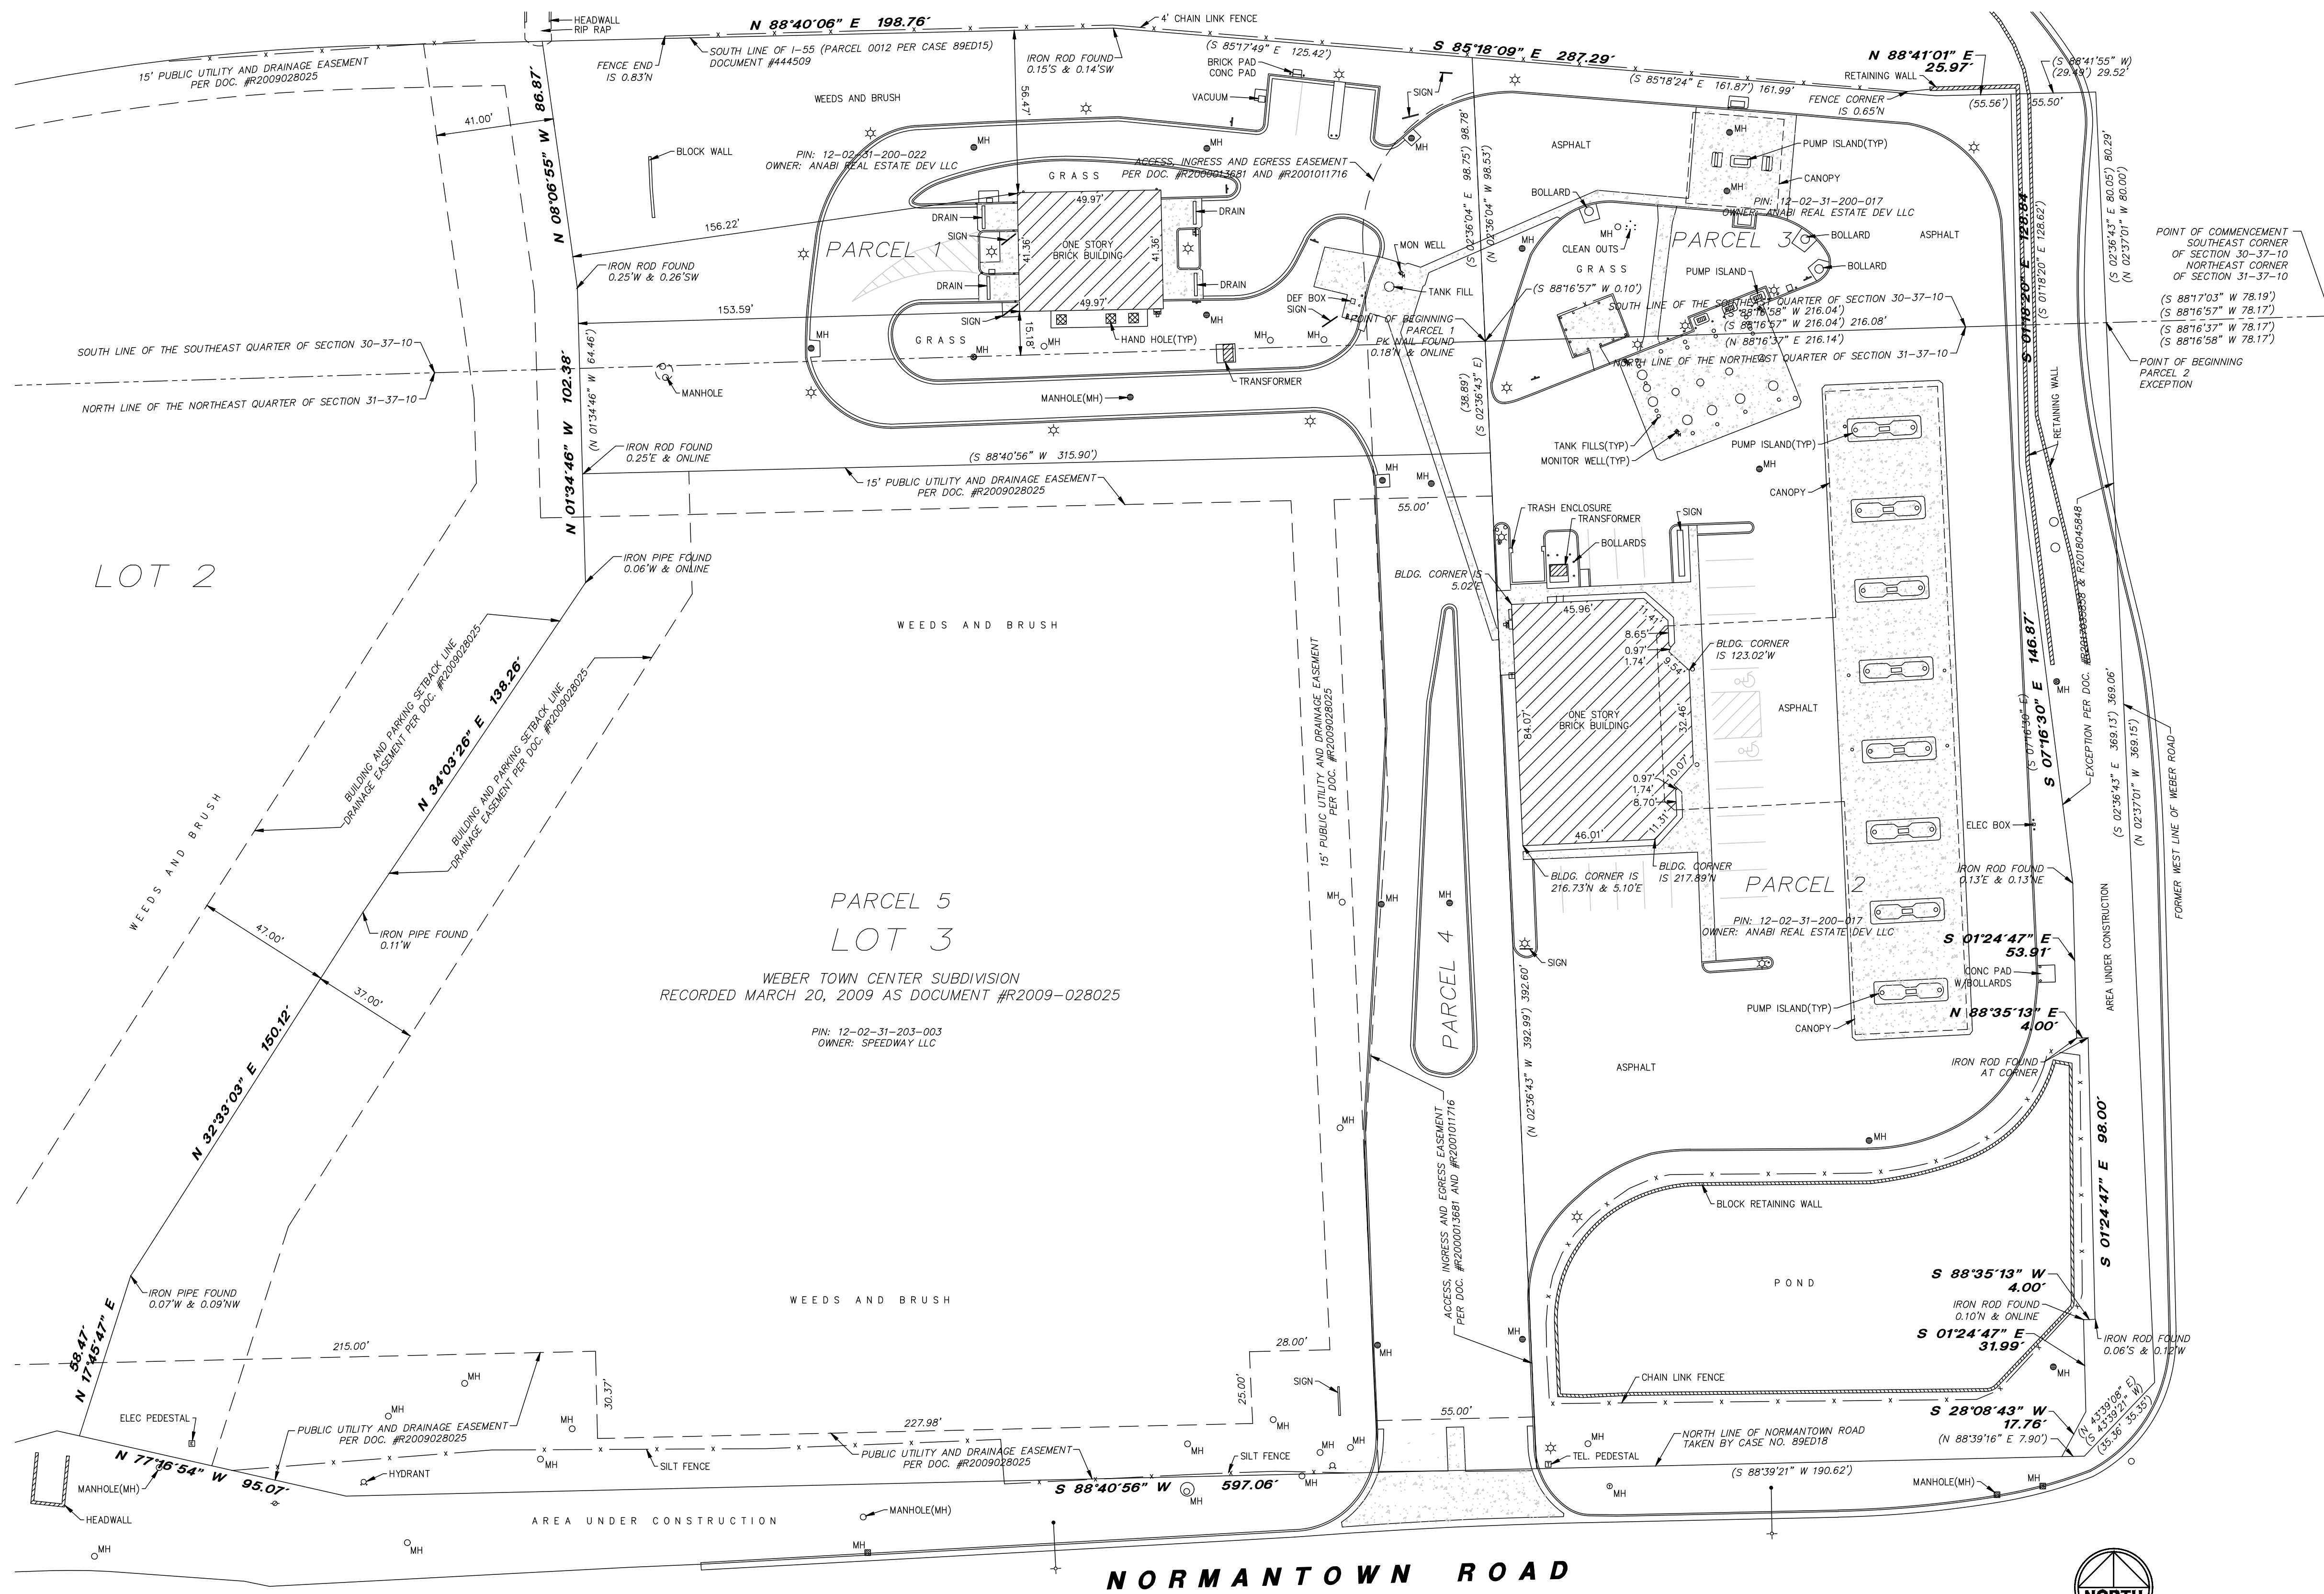



1 EXISTING SITE PLAN

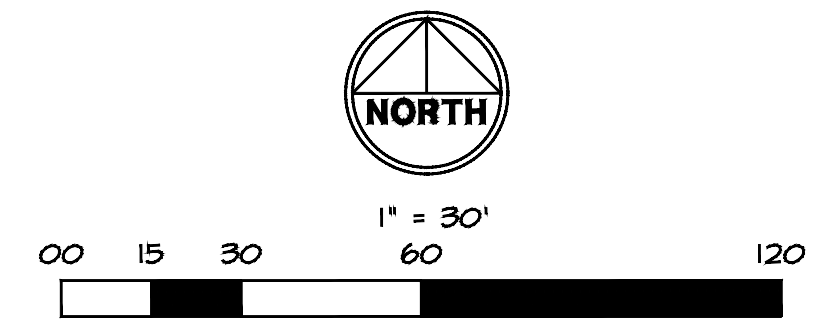

1450 N. Benson Ave.,
Upland, CA 91786 USA
www.anabioli.com - (909) 394-4728

PROJECT FILE NAME:	REBEL REMODEL WITH DRIVE-THRU & GAMING
PROJECT ADDRESS:	1300 W. NORMANTOWN RD. ROMEOVILLE, IL
REVISION #:	32
DESIGNER:	DV
PAGE:	SP1.0
DATE:	02-05-2025
SCALE:	1/32" = 1'-0"
STORE #:	868

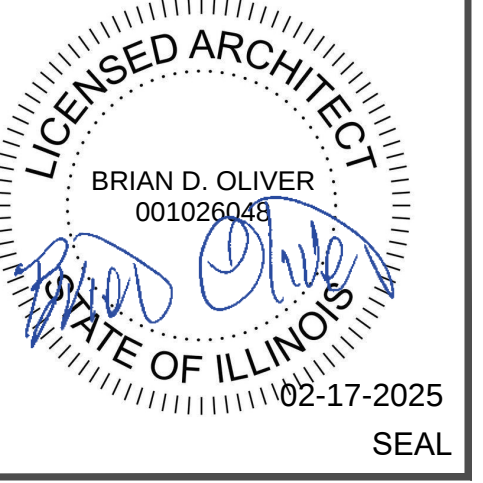

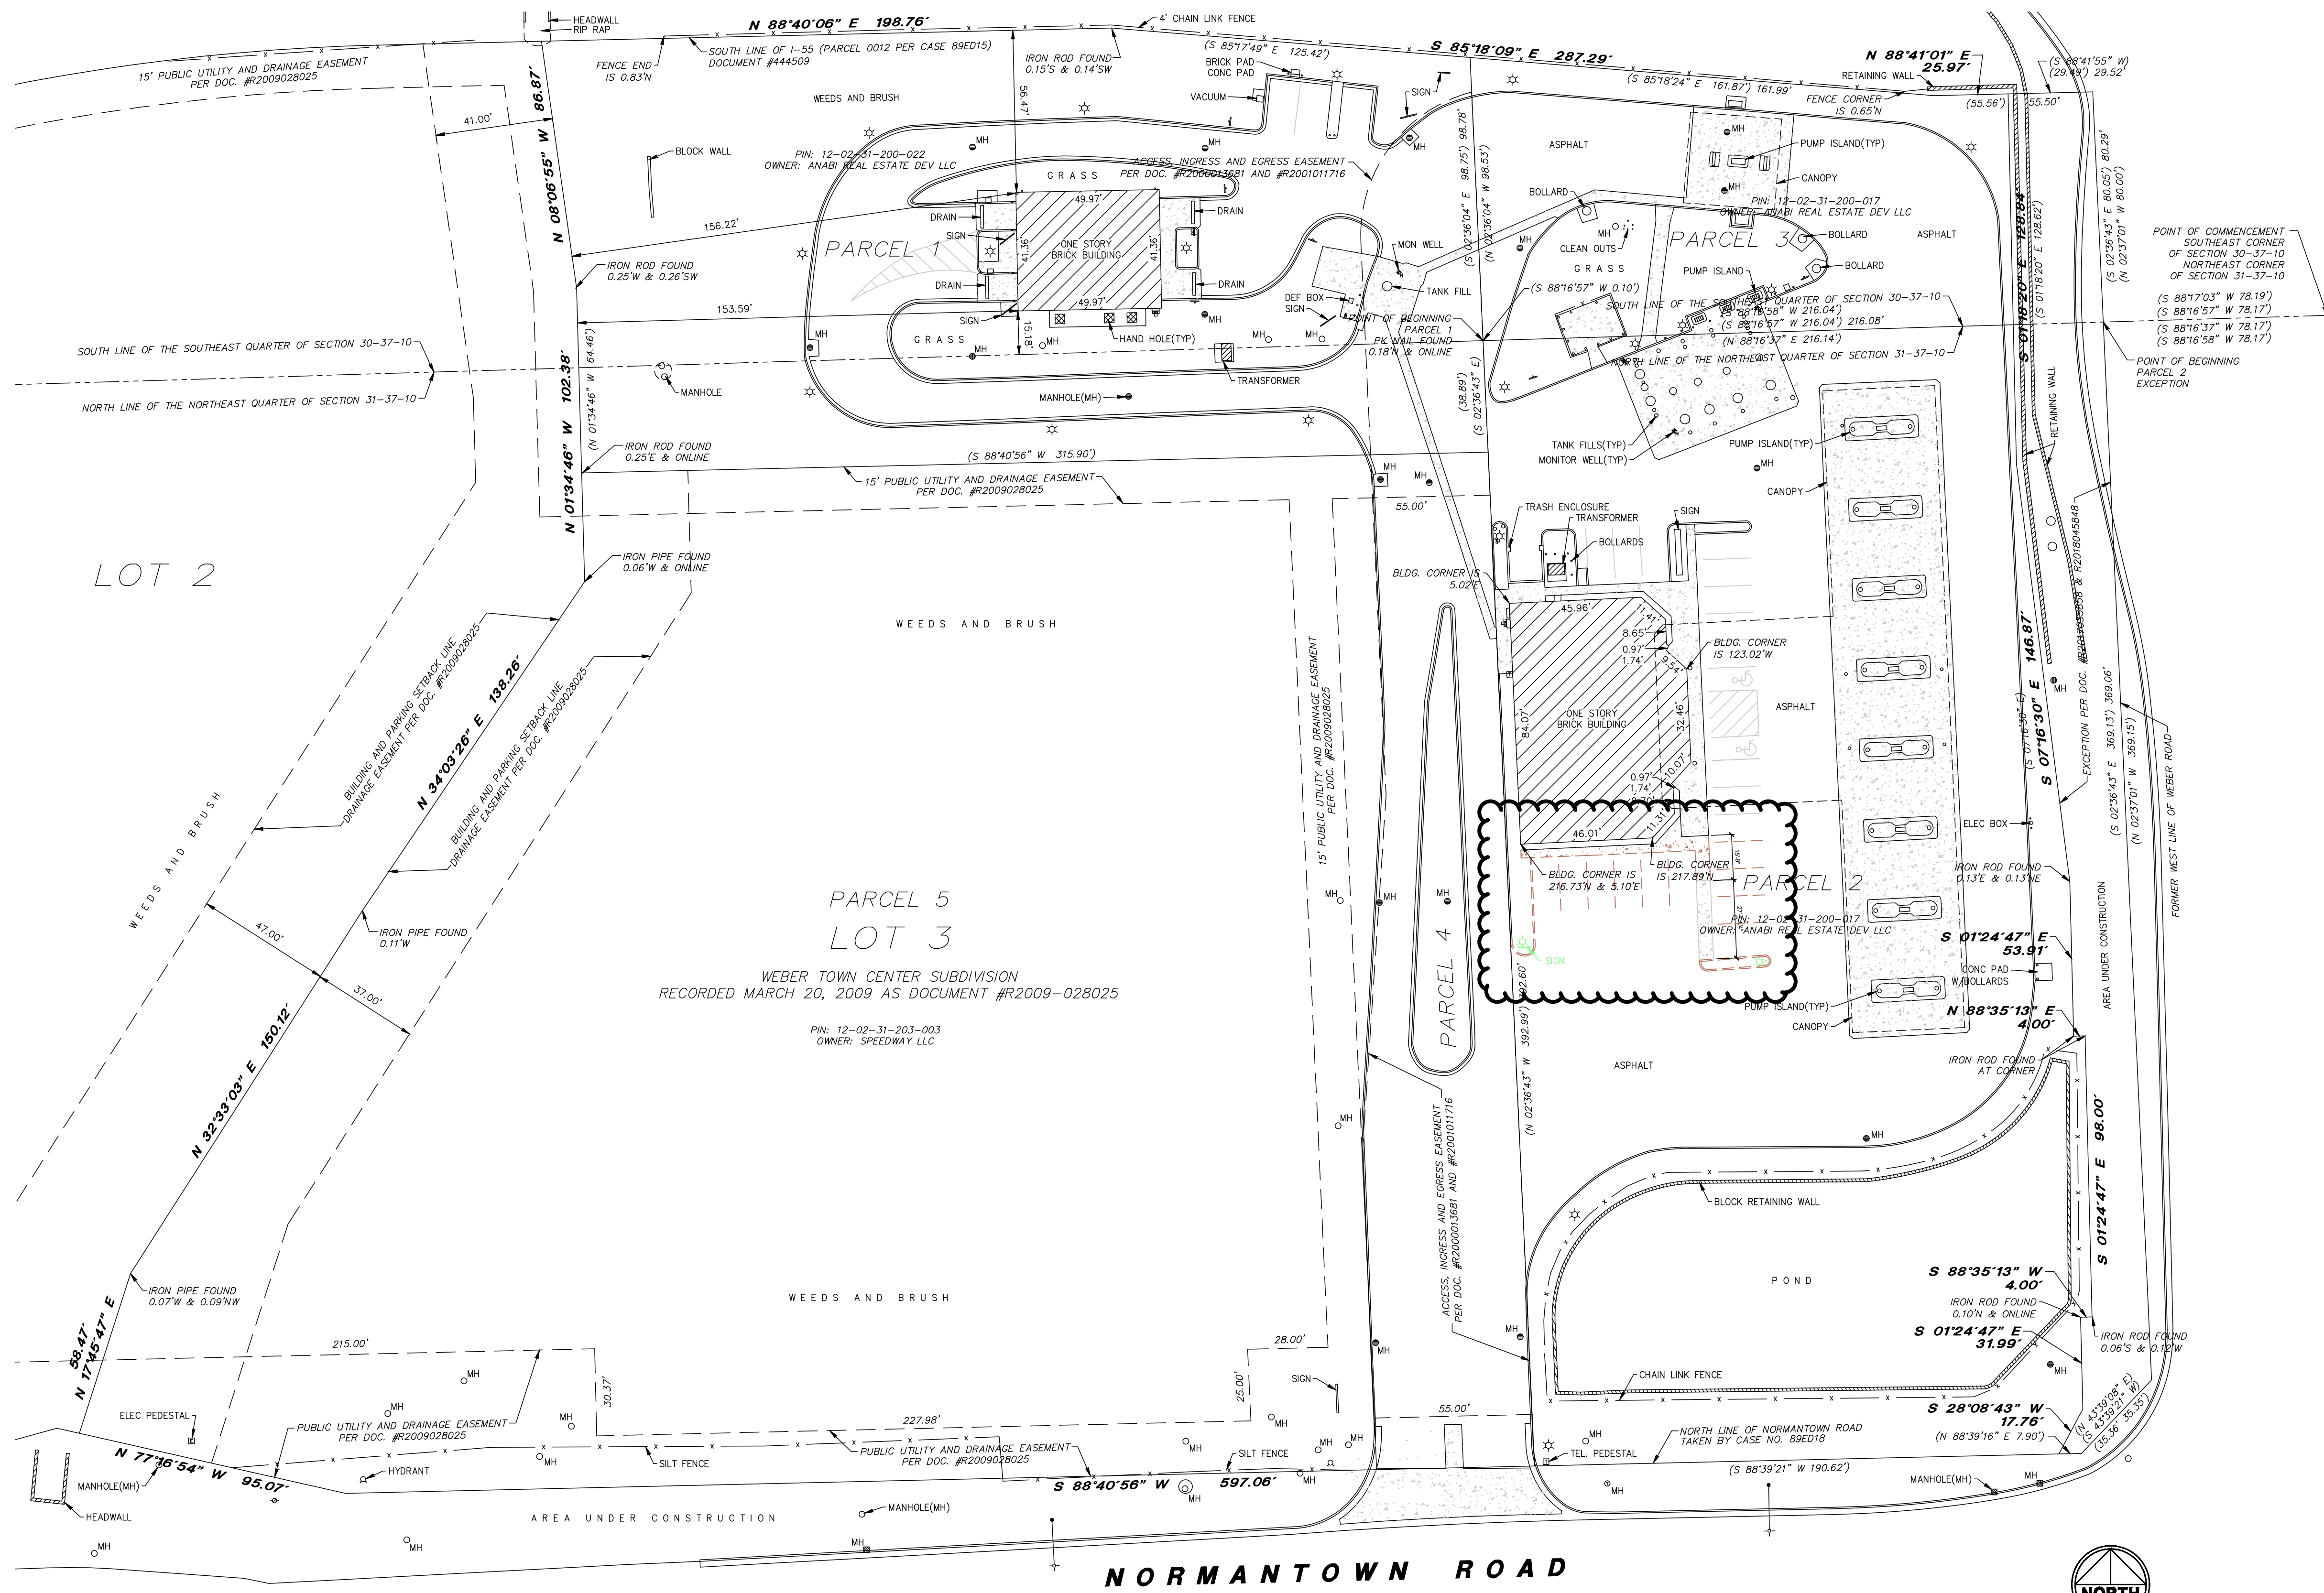

1 DEMO SITE PLAN




1450 N. Benson Ave.,
Upland, CA 91786 USA
www.anabioli.com - (909) 394-4728

PROJECT FILE NAME:	REVISION #:	DESIGNER:	PAGE:
REBEL REMODEL WITH DRIVE-THRU & GAMING	32	DV	SP1.1
PROJECT ADDRESS:	STORE #:	DATE:	SCALE:
1300 W. NORMANTOWN RD. ROMEOVILLE, IL	868	02-05-2025	1/32" = 1'-0"



02-17-2025
SEAL

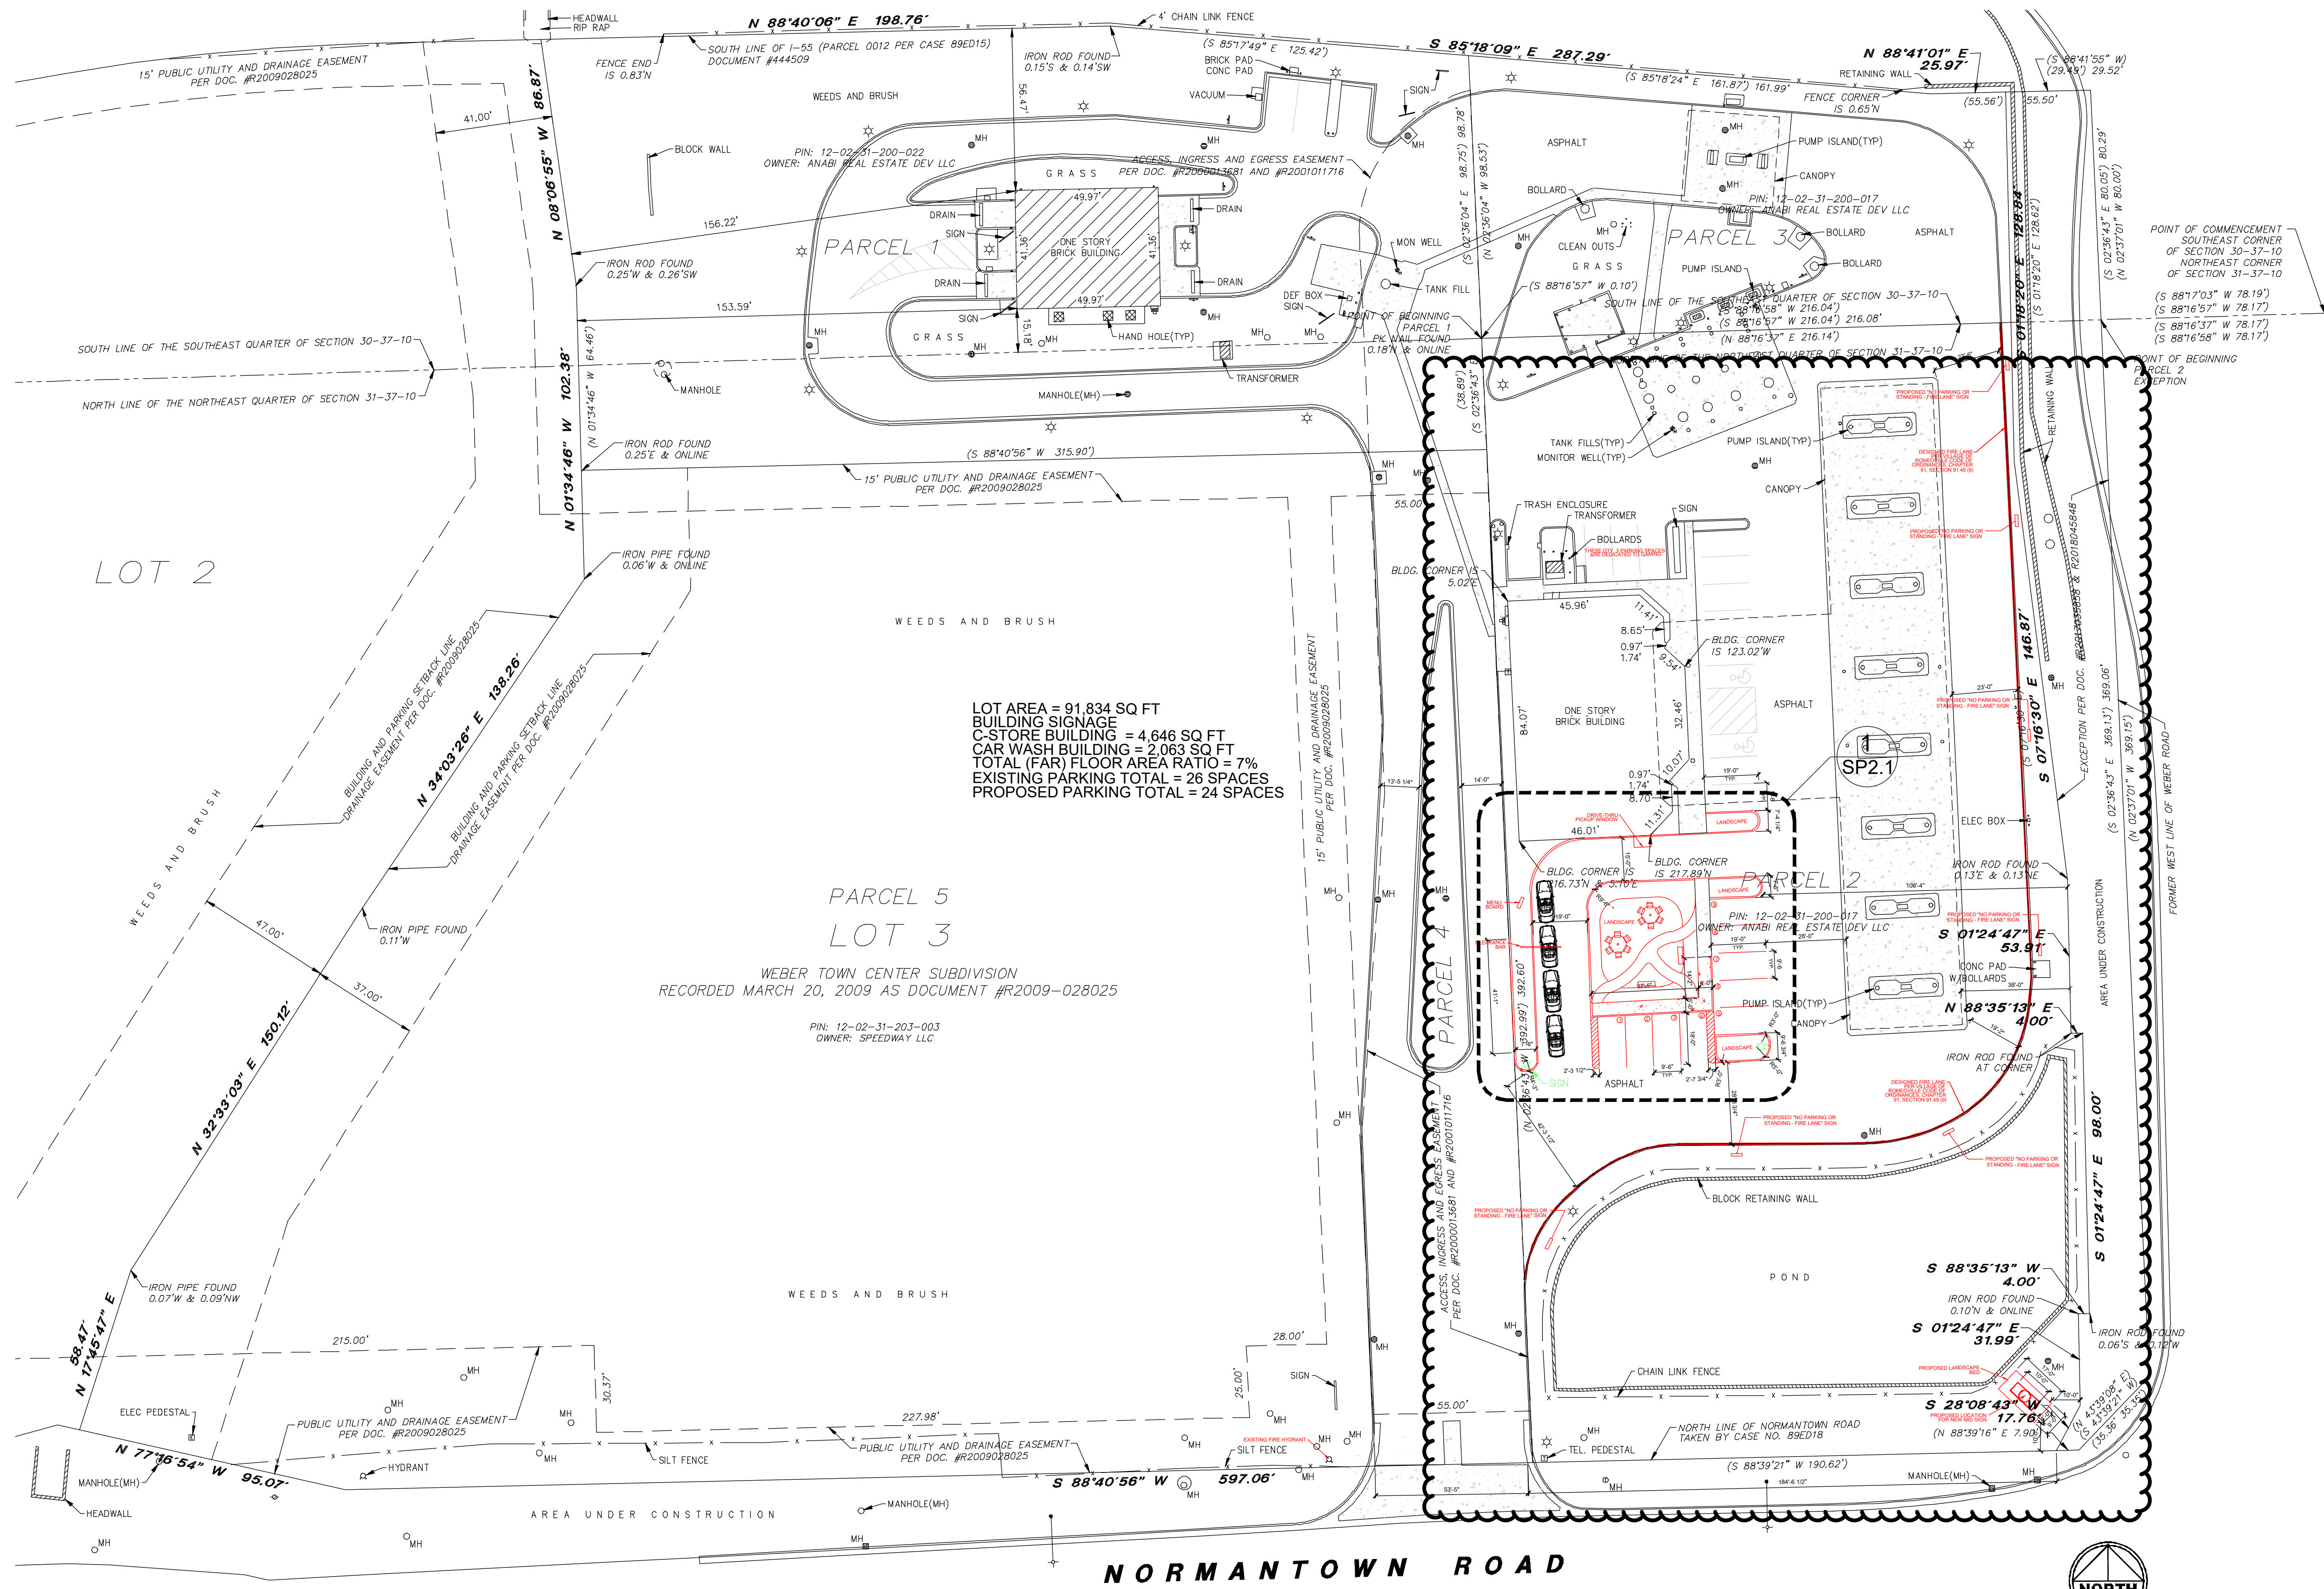

1 OVERALL PROPOSED SITE PLAN




1450 N. Benson Ave.,
Upland, CA 91786 USA
www.anabioli.com • (909) 394-4728

PAGE:	SP2.0	SCALE:	1/32" = 1'-0"
DESIGNER:	DV	DATE:	02-05-2025
REVISION #:	32	STORE #:	868

PROJECT FILE NAME:
REBEL REMODEL WITH DRIVE-THRU & GAMING
PROJECT ADDRESS:
1300 W. NORMANTOWN RD. ROMEOVILLE, IL



02-17-2025
SEAL

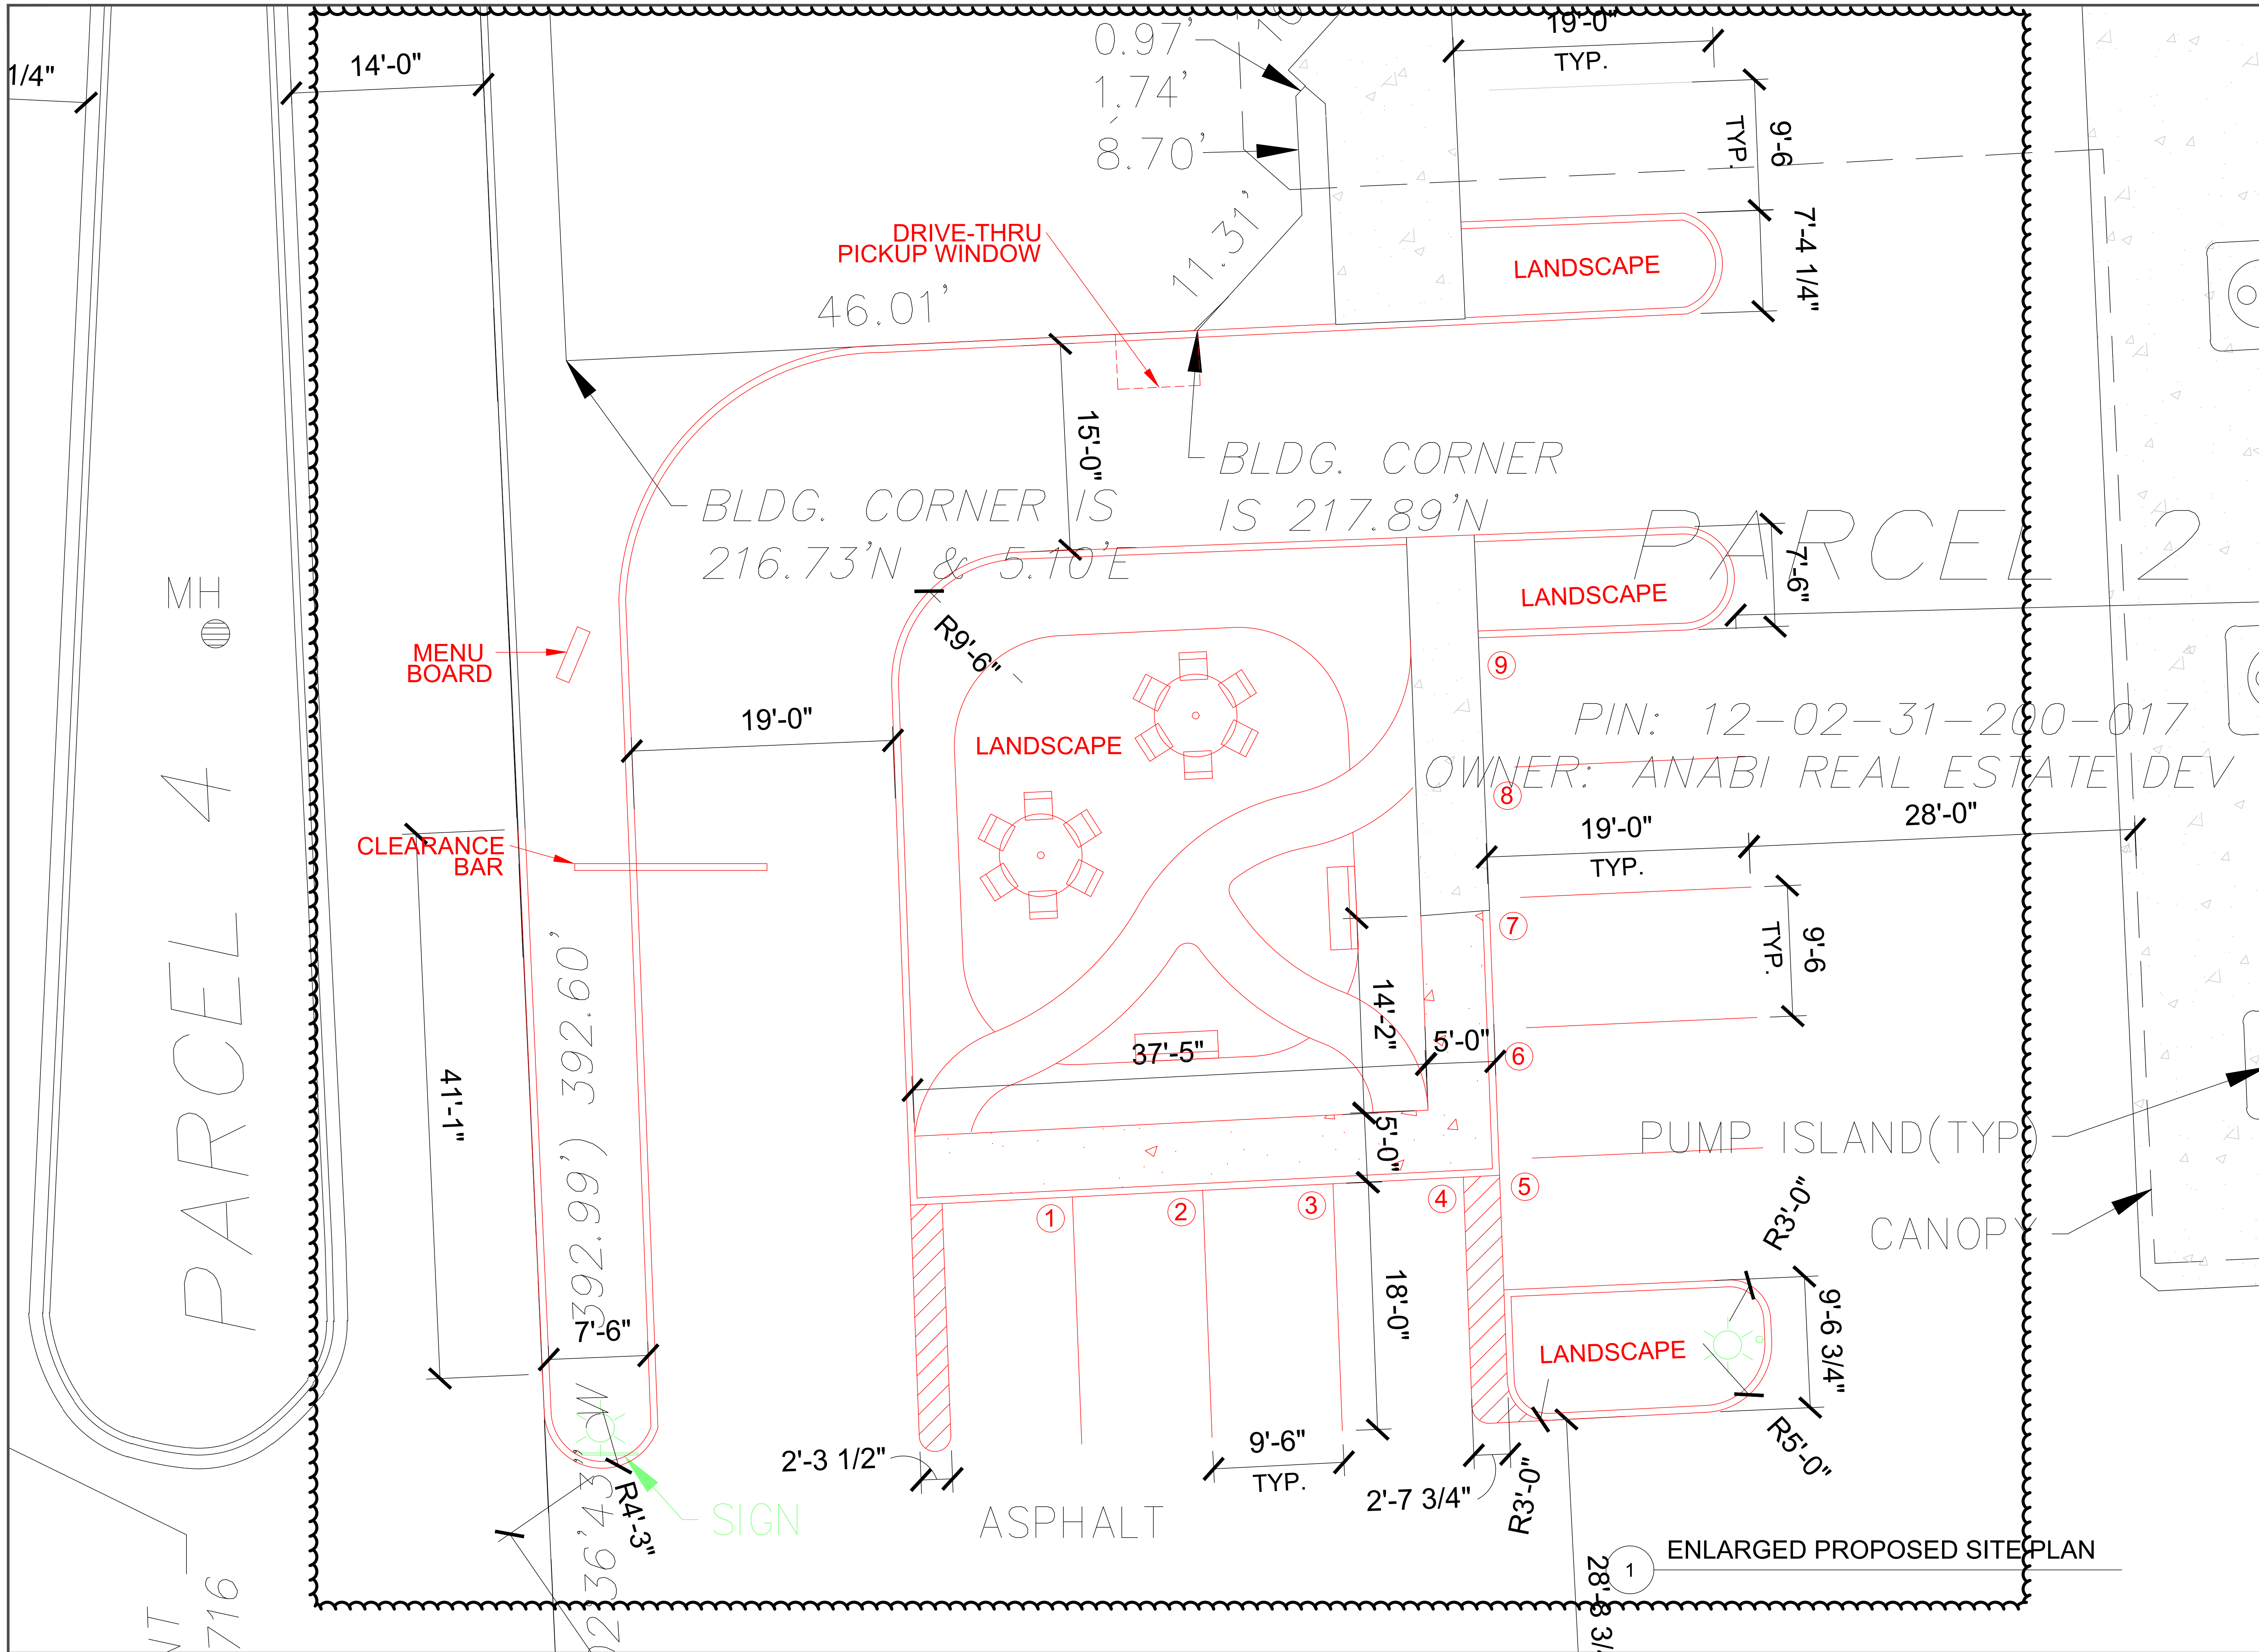



1450 N. Benson Ave.,
Upland, CA 91786 USA
www.anabioli.com - (909) 394-4728

REVISION #:	DESIGNER:	PAGE:
32	DV	SP2.1
STORE #:	DATE:	SCALE:
868	02-05-2025	3/16" = 1'-0"

PROJECT FILE NAME:

REBEL REMODEL WITH DRIVE-THRU & GAMING


PROJECT ADDRESS:

1300 W. NORMANTOWN RD. ROMEOVILLE, IL



LICENSED ARCHITECT
BRIAN D. OLIVER
001026048
STATE OF ILLINOIS
02-17-2025
SEAL

ENLARGED PROPOSED SITE PLAN

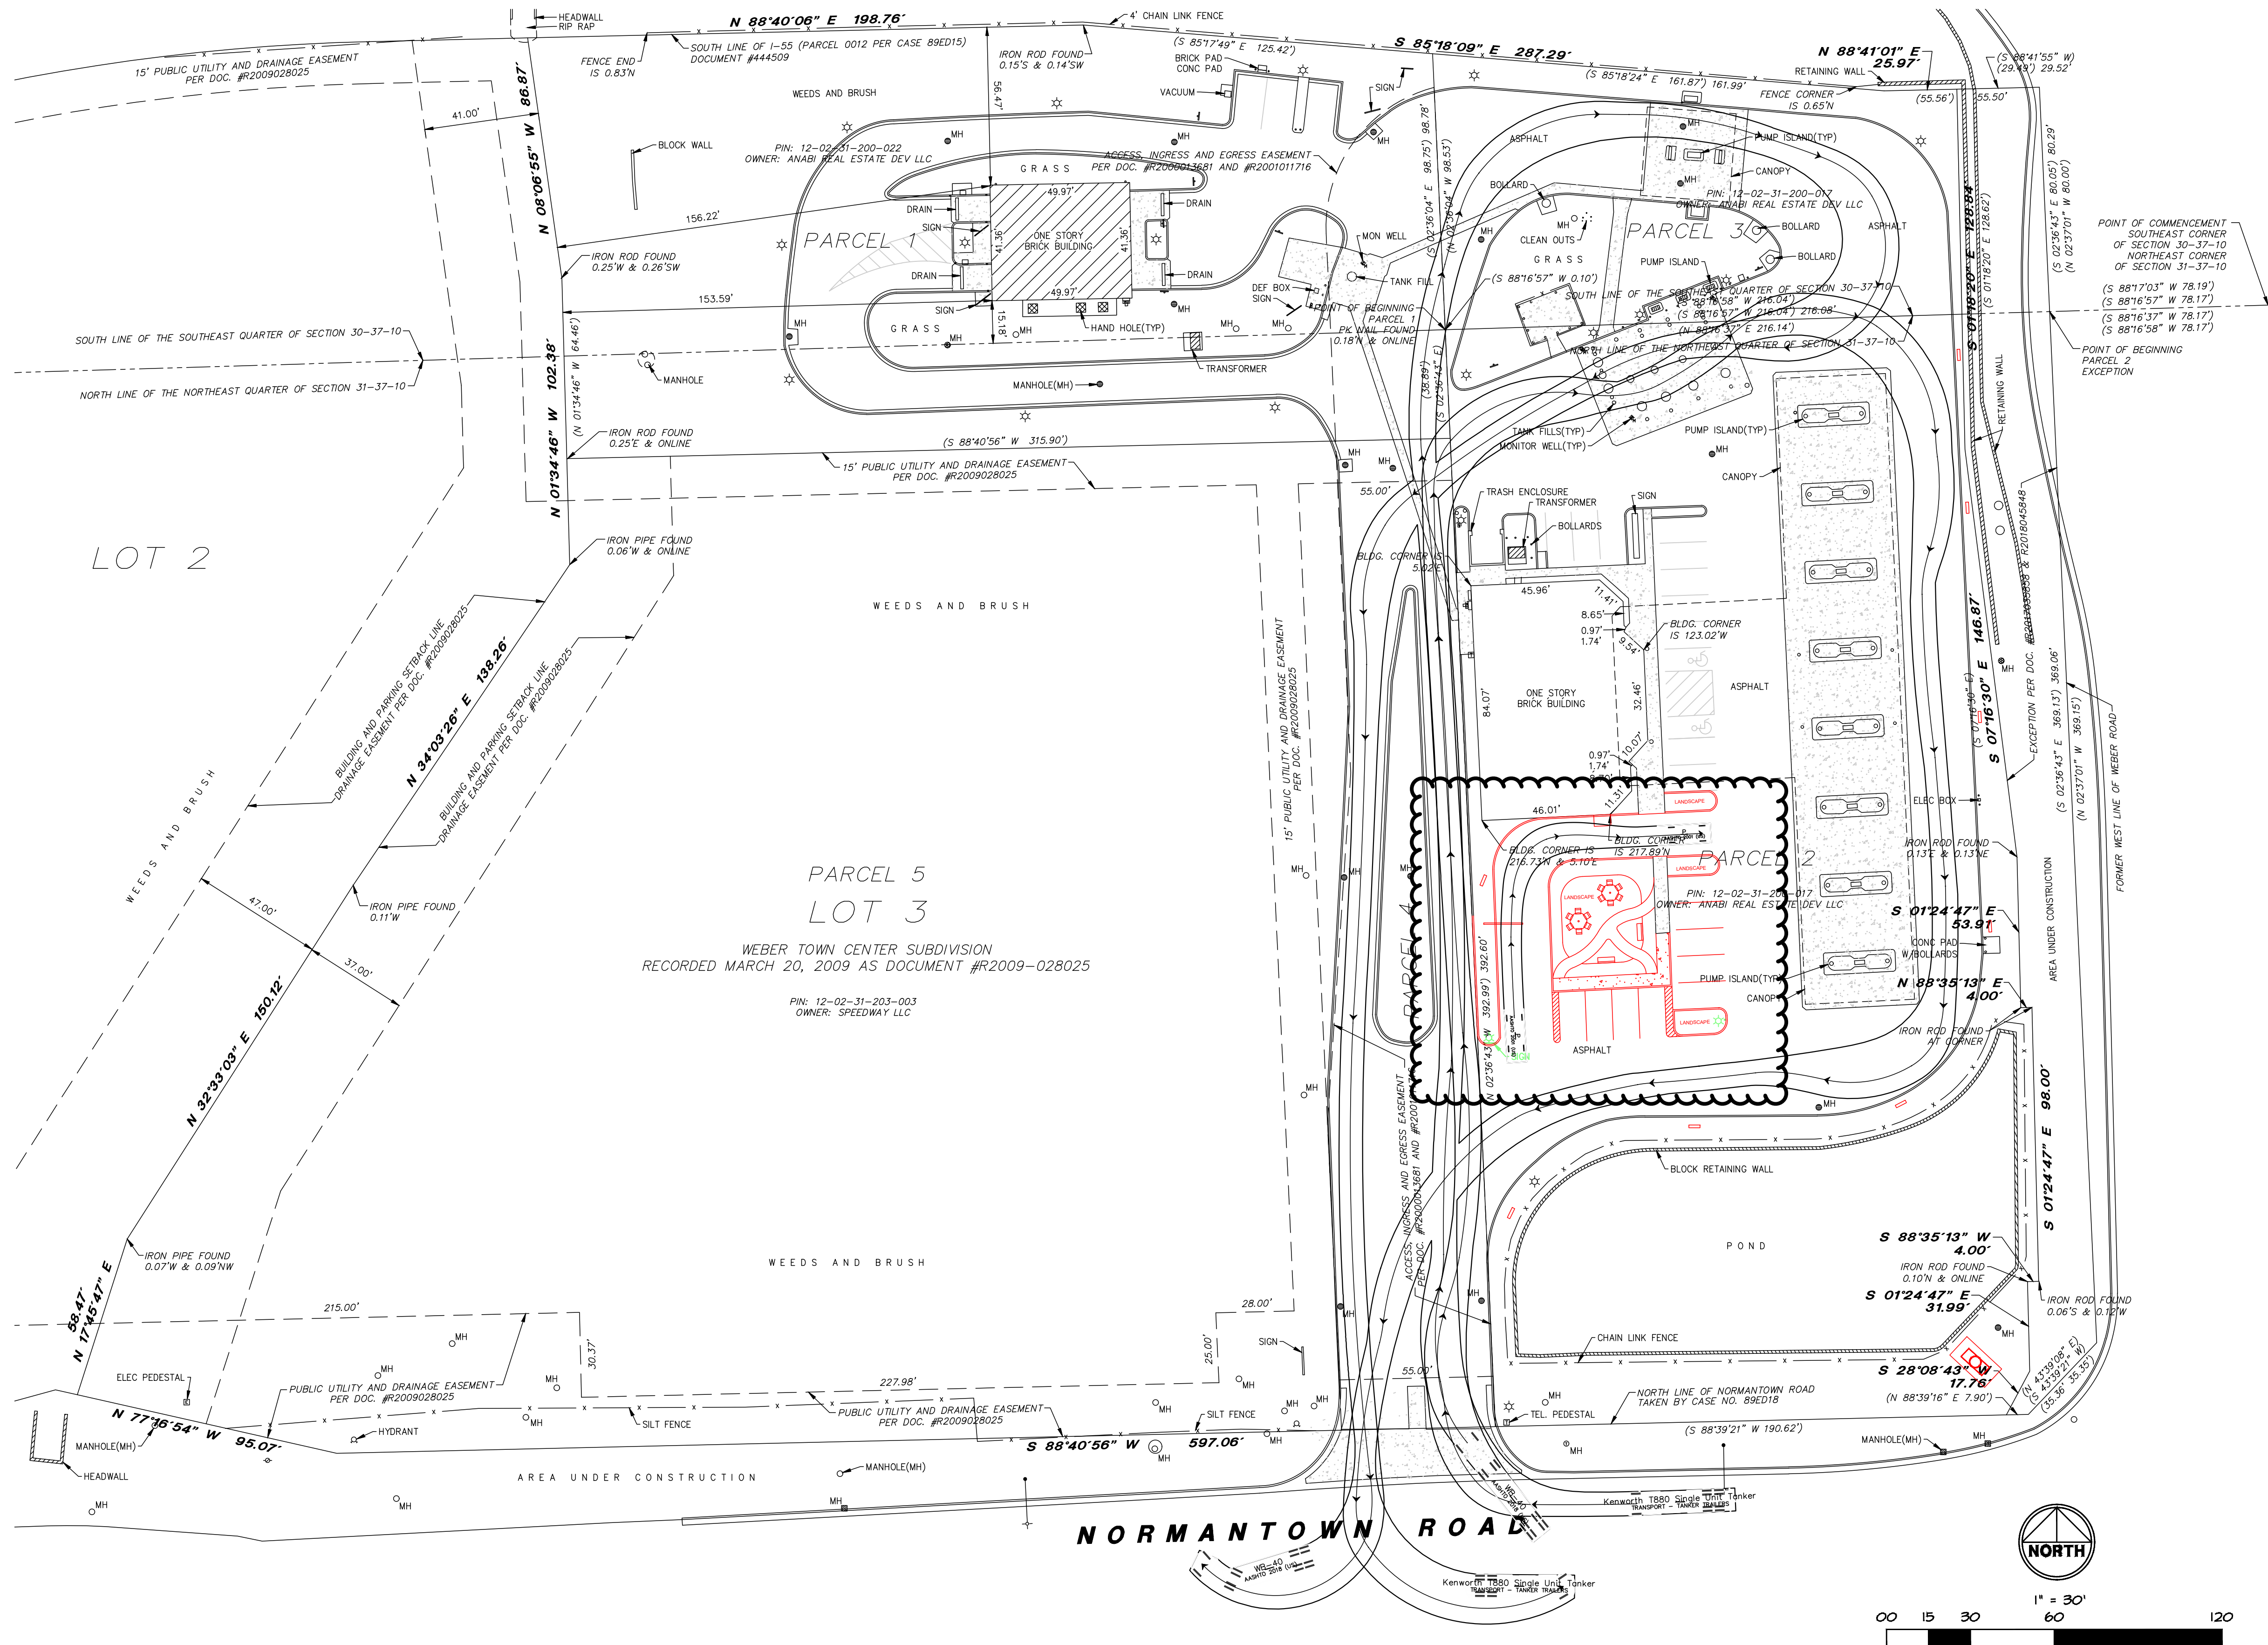

1 PROPOSED SITE PLAN - AAHSTO TRUCK ROUTE



1450 N. Benson Ave.,
Upland, CA 91786 USA
www.anabioli.com - (909) 394-4728

PAGE:	SP3.0	SCALE:	1/32" = 1'-0"
DESIGNER:	DV	DATE:	02-05-2025
REVISION #:	32	STORE #:	868

PROJECT FILE NAME:
 REBEL REMODEL WITH DRIVE-THRU & GAMING

PROJECT ADDRESS:
 1300 W. NORMANTOWN RD. ROMEOVILLE, IL



02-17-2025
SEAL



1450 N. Benson Ave.,
Upland, CA 91786 USA
www.anabioli.com • (909) 394-4728

PAGE:	D1.0	SCALE:	1/4" = 1'-0"
DESIGNER:	DV	DATE:	02-05-2025
REVISION #:	32	STORE #:	868

PROJECT FILE NAME:	REBEL REMODEL WITH DRIVE-THRU & GAMING
PROJECT ADDRESS:	1300 W. NORMANTOWN RD. ROMEOVILLE, IL




DEMO KEYNOTE LEGEND


- 1 DEMO STAINLESS STEEL TABLE
- 2 EXISTING QTY. 2 HOT FOOD DISPLAY CASES TO REMAIN
- 3 ALL EQUIPMENT AND CABINETRY IN QSR AREA TO REMAIN
- 4 DEMO (QTY. 2) END CAPS
- 5 DEMO LEAN BAR, CHAIRS, AND MILLWORK. PREPARE AREA FOR INSTALLATION OF NEW COFFEE AREA
- 6 DEMO (QTY. 2) OPEN AIR CASES
- 7 DEMO HOT FOOD ISLAND INCLUDING EQUIPMENT. PATCH/ REPAIR FLOORING AS NECESSARY
- 8 DEMO STOREFRONT ENTRY. PREPARE FOR INSTALLATION OF NEW AUTOMATIC SLIDING DOORS AND GLASS
- 9 DEMO EXISTING WALL TILE
- 10 DEMO EXISTING SWING GATE AND HARDWARE
- 11 RELOCATE ALL EXISTING GONDOLA SHELVING (TURN VERTICALLY). SEE PROPOSED PLAN /A1.0 FOR NEW LOCATIONS
- 12 EXISTING VENT HOOD TO REMAIN
- 13 DEMO EXISTING BASES AROUND COLUMNS
- 14 RELOCATE QTY. 2 FRAZIL BEVERAGE DISPENSERS. SEE SHEET A1.0 FOR NEW LOCATIONS
- 15 EXISTING ELECTRICAL PANELS TO REMAIN
- 16 DEMO EXISTING COUNTERTOP ON SALES COUNTER; LEAVE EXISTING CABINETS. RELOCATE EQUIPMENT PER A1.0 LAYOUT. PREP FOR PAINTING AND REFACING OF CABINETS
- 17 DEMO ALL FLOORING IN MERCHANDISE & SALES AREAS AND PREPARE FOR INSTALLATION OF NEW. COORDINATE WITH OWNER ON MATERIAL SELECTION AND BRAND STANDARDS TO BE USED
- 18 EXISTING SINK TO REMAIN; NO CHANGES
- 19 DEMO EXISTING CABINETS AND PREPARE FOR INSTALLATION OF NEW
- 20 DEMO EXISTING CIG/OTP BACKBAR AND LIQUOR DISPLAY CABINET
- 21 ALL FINISHES AND CABINETRY IN THIS AREA TO REMAIN
- 22 EXISTING STRUCTURAL COLUMNS TO REMAIN
- 23 RELOCATE EXISTING COFFEE EQUIPMENT; SEE PROPOSED PLAN /A1.0 FOR NEW LOCATIONS
- 24 EXISTING FIRE EXTINGUISHERS TO REMAIN
- 25 DEMO QTY. 1 METRO SHELF AND RELOCATE QTY. 1 METRO SHELF IN BACKROOM. SEE PROPOSED PLAN /A1.0 FOR NEW LOCATION
- 26 DEMO EXISTING WINDOWS AND PREPARE FOR INSTALLATION OF NEW DRIVE THRU WINDOW
- 27 DEMO EXISTING SINK AND RE-ROUTE PLUMBING AS NEEDED; REFER TO PLUMBING DRAWINGS FOR DETAILS

LINE TYPE LEGEND

- DEMO
- RELOCATE EXISTING (WITHIN STORE)
- RELOCATE EXISTING (ANOTHER OUTSIDE LOCATION)
- EXISTING

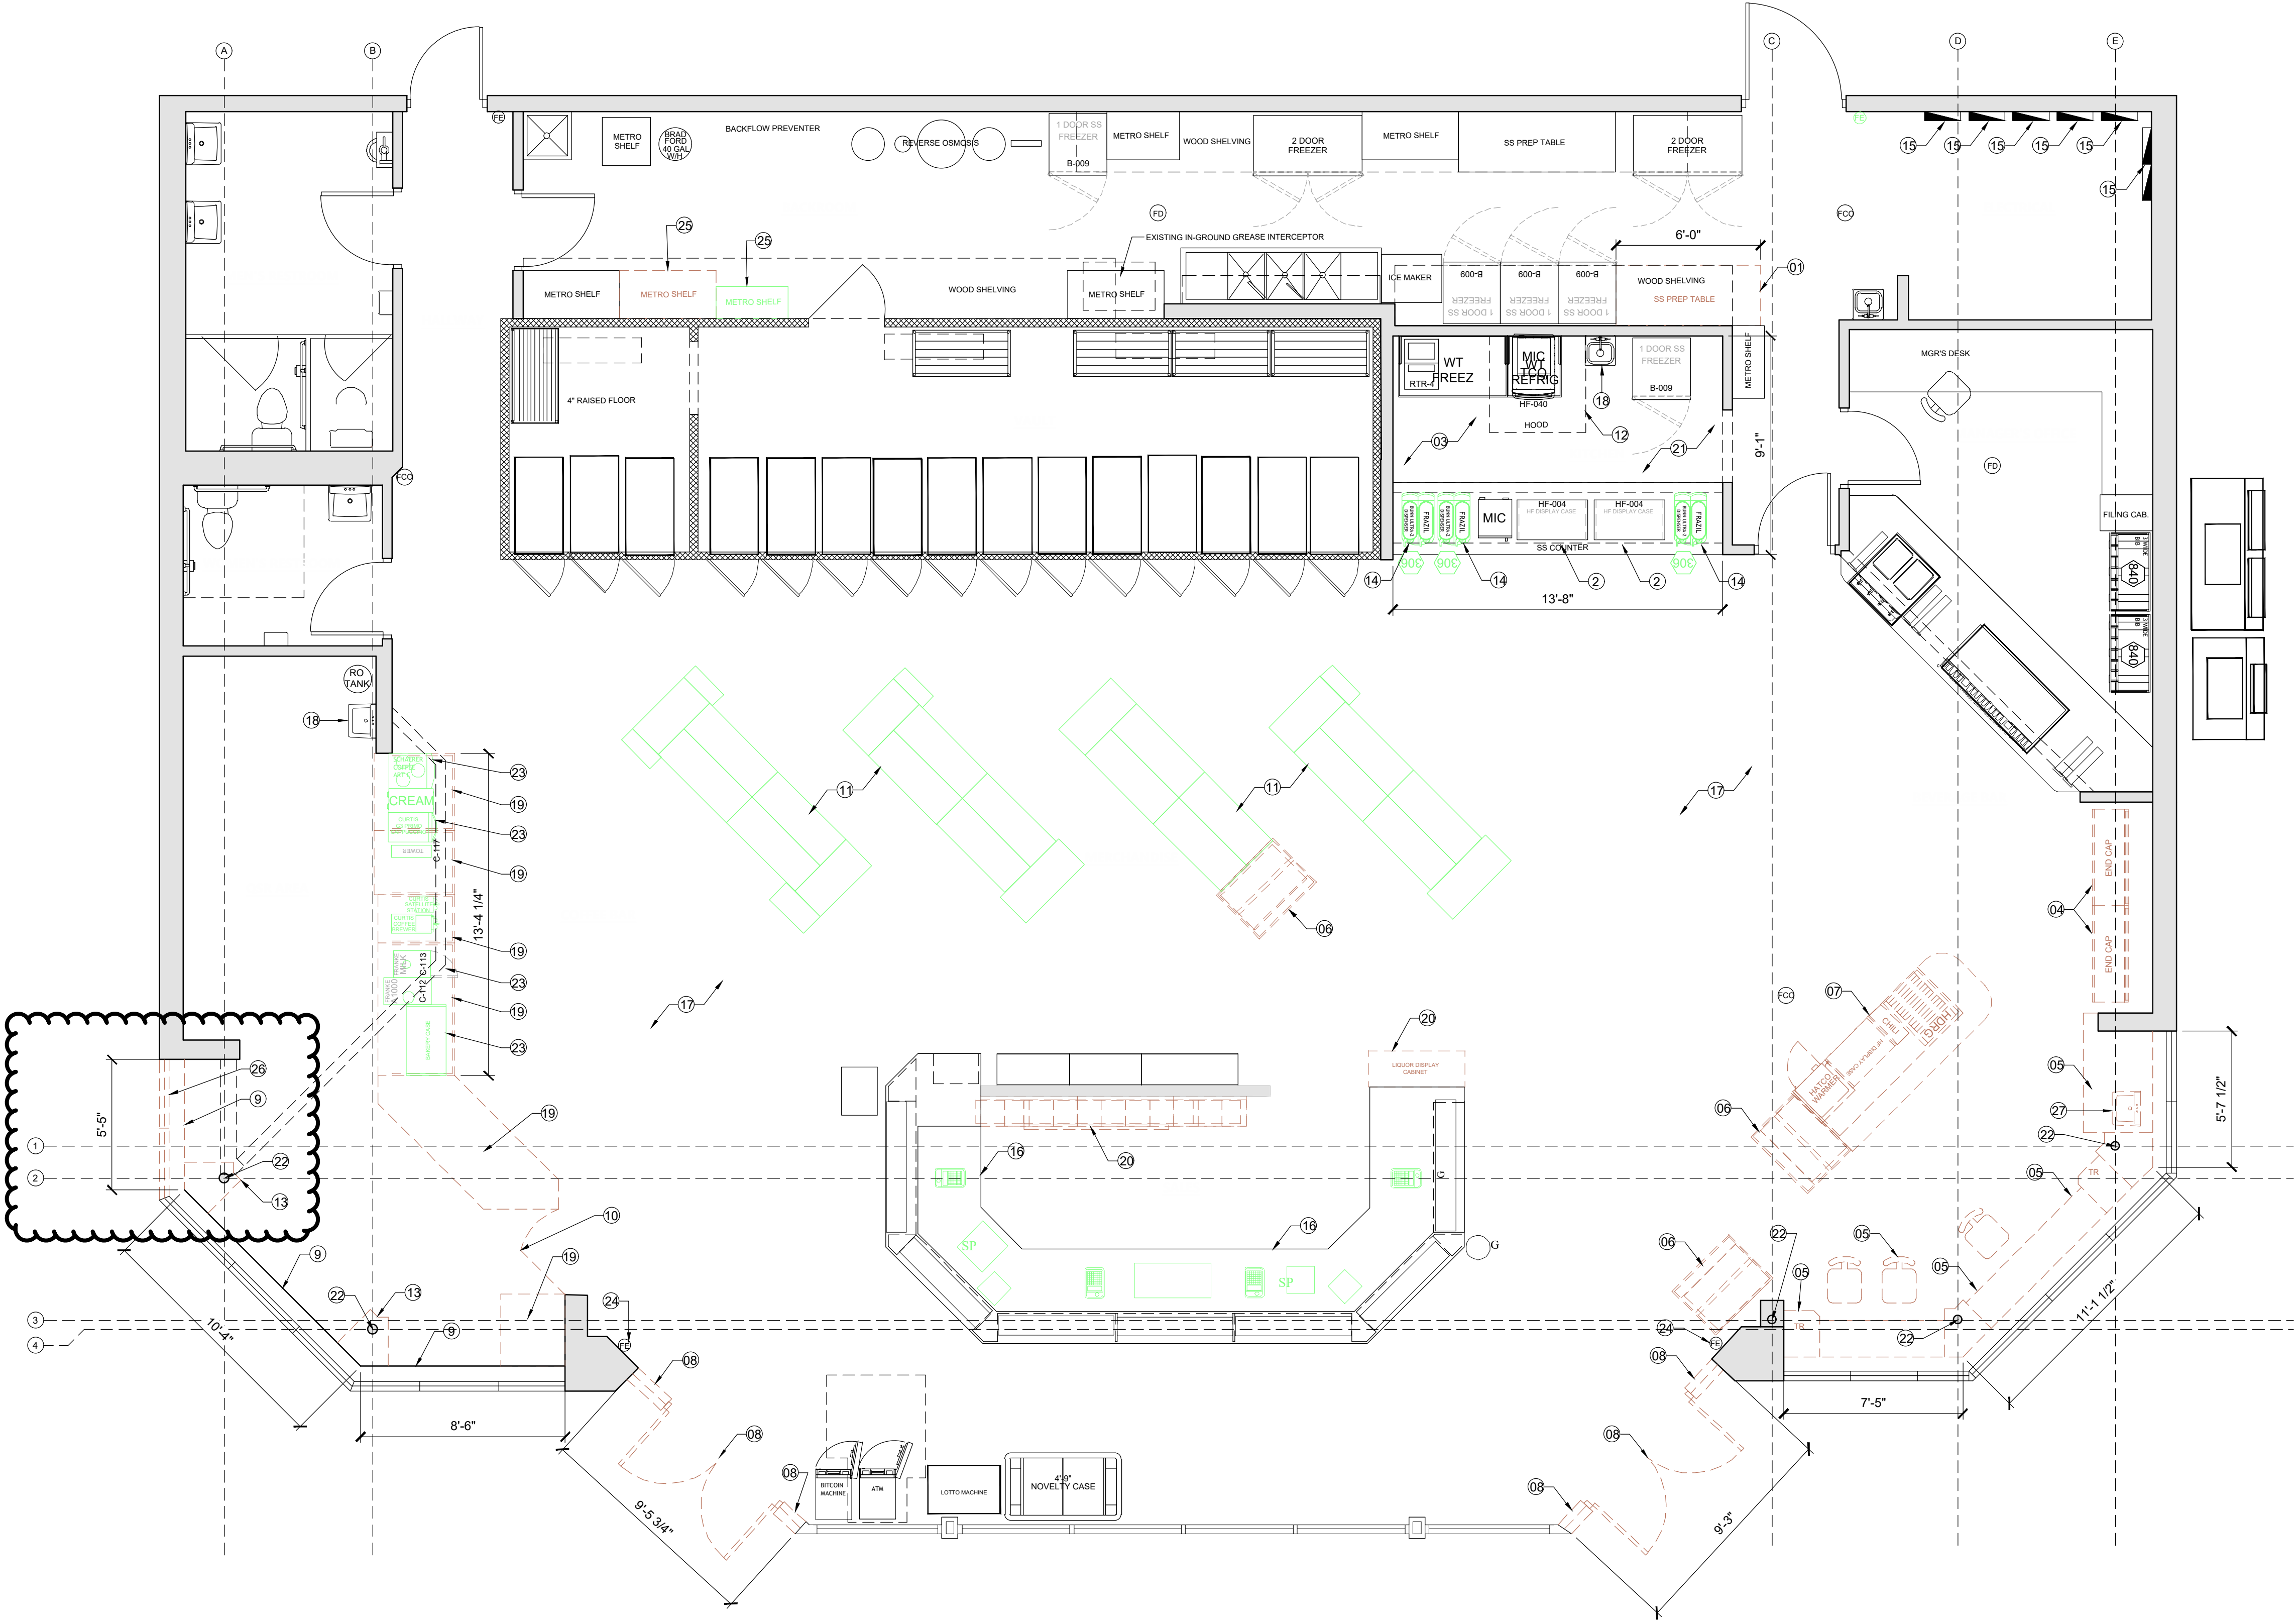

1 EXISTING / DEMO DIMENSION PLAN

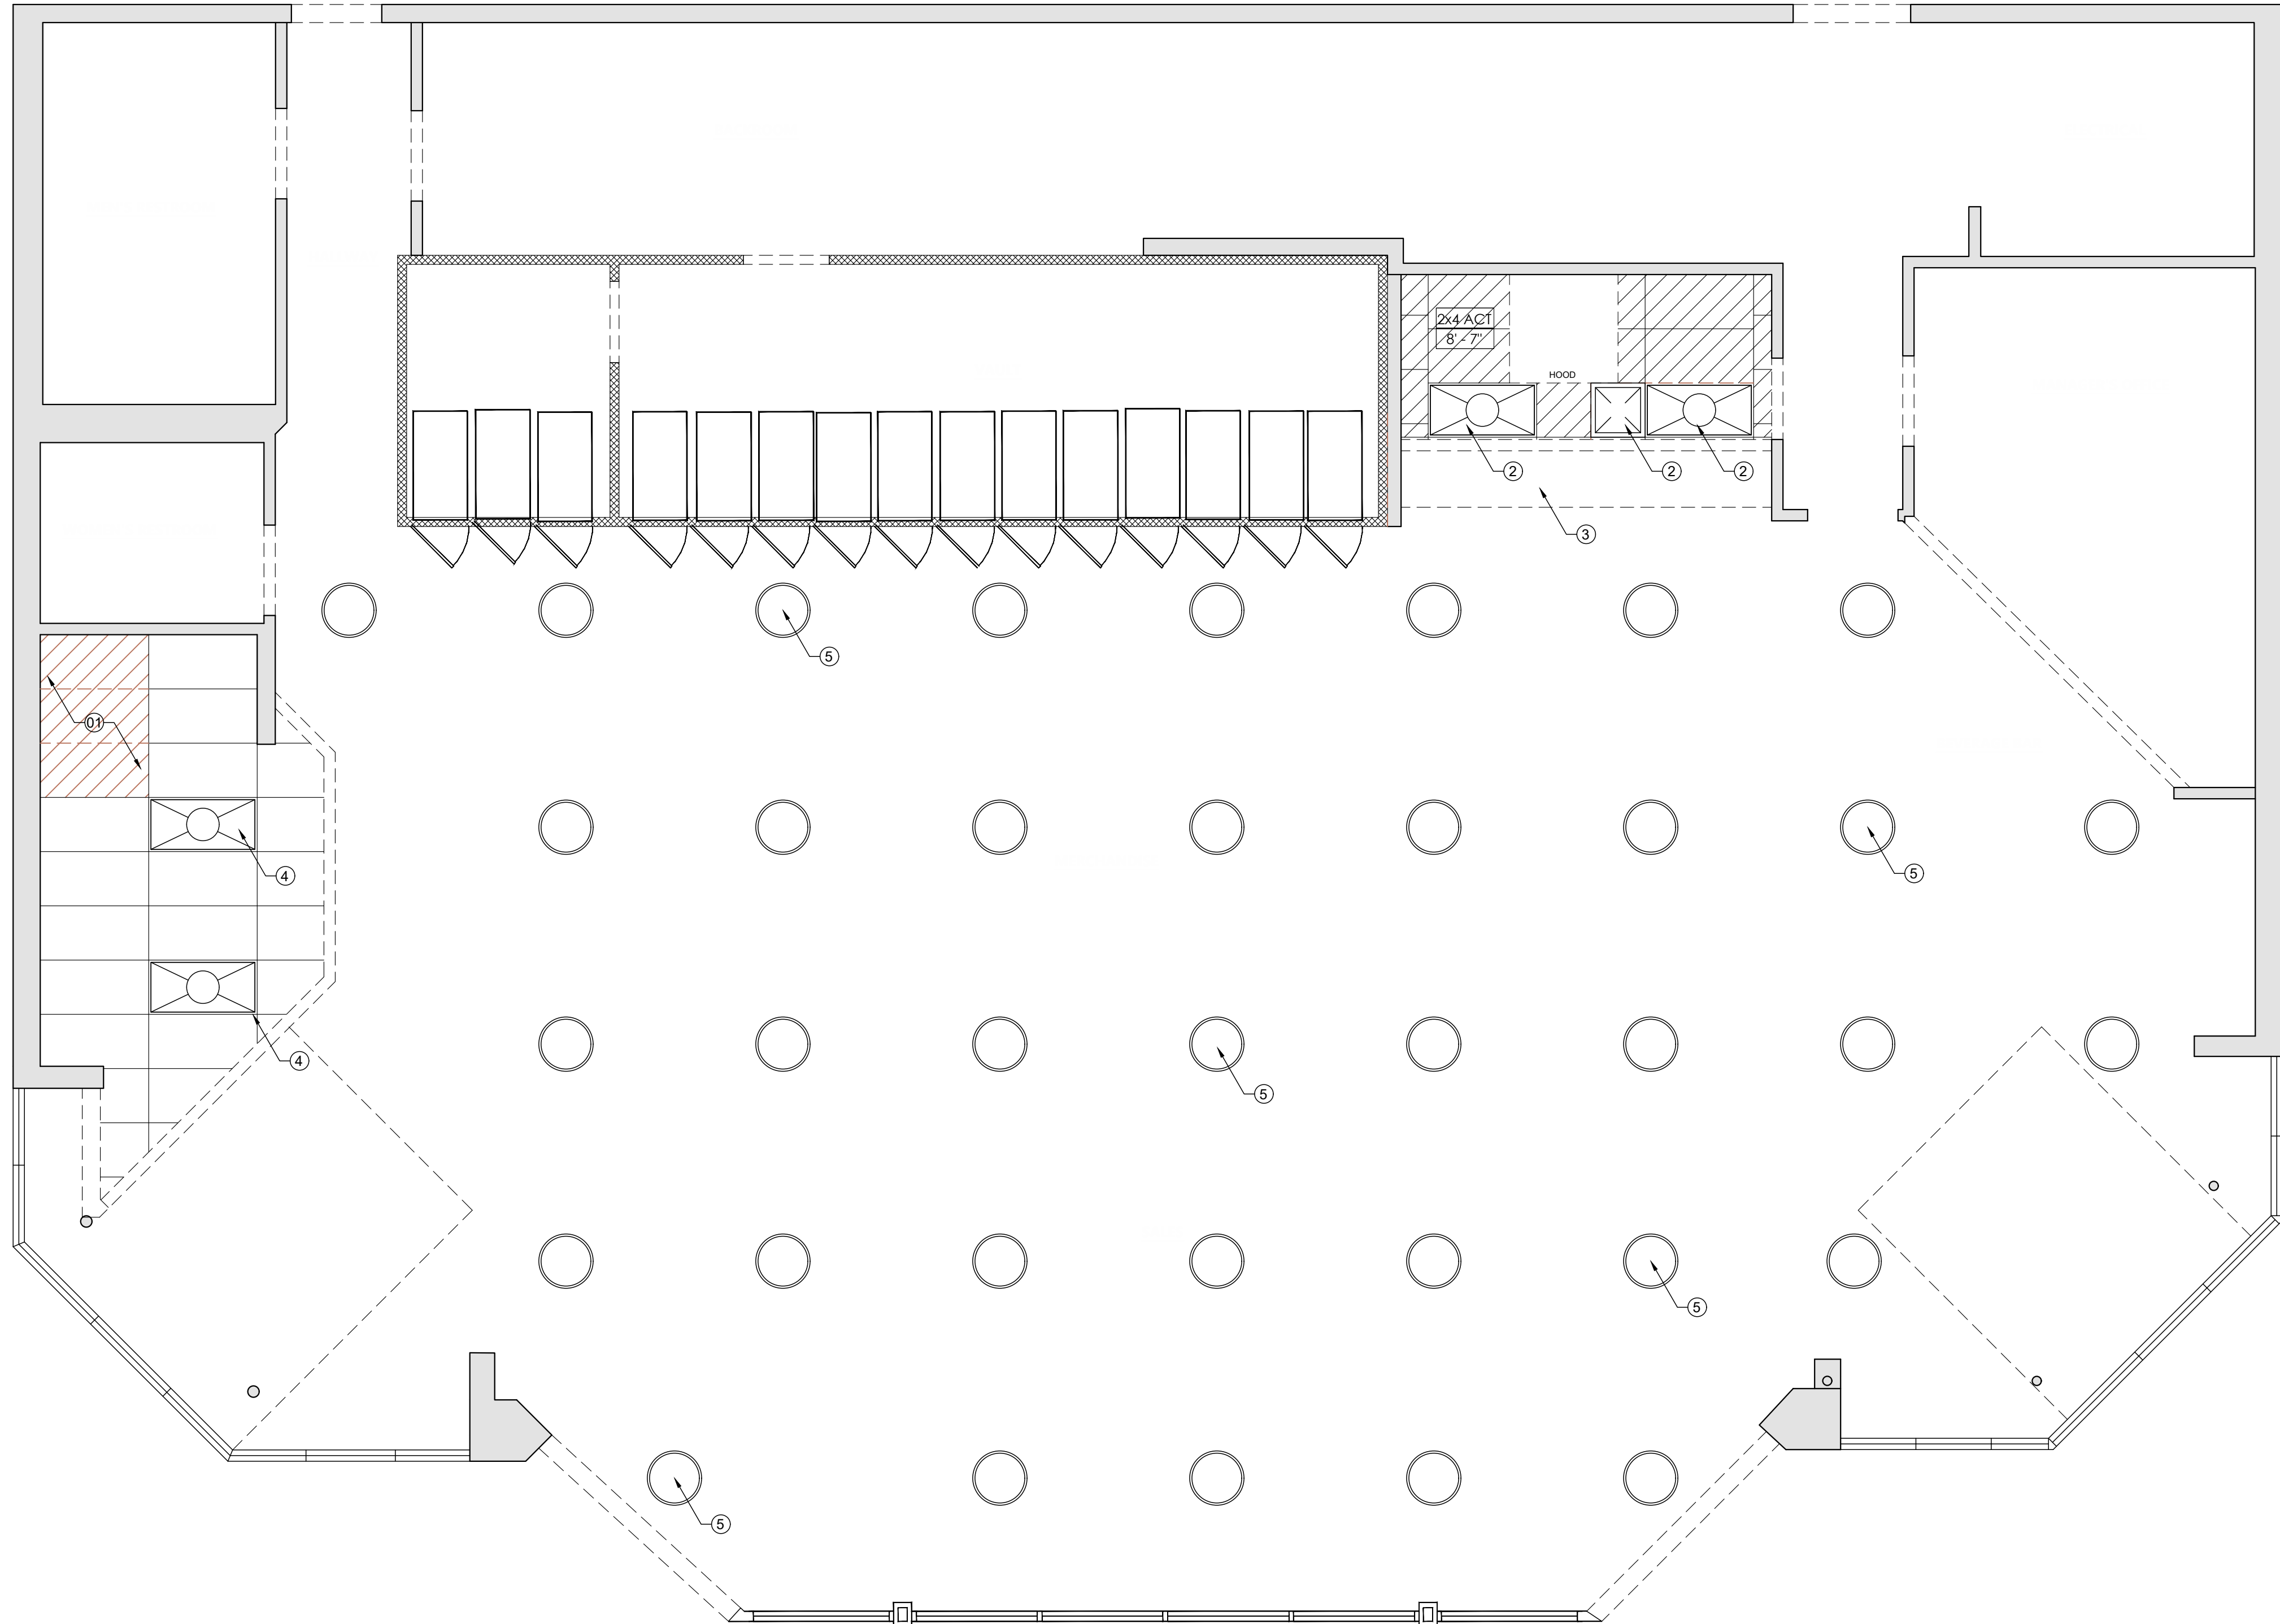

1 DEMO REFLECTED CEILING PLAN

LINE TYPE LEGEND

- DEMO
- - - - RELOCATE EXISTING (WITHIN STORE)
- RELOCATE EXISTING (ANOTHER OUTSIDE LOCATION)
- EXISTING

DEMO KEYNOTE LEGEND

- ① DEMO EXISTING ACOUSTICAL TILE CEILING AND GRID SYSTEM
- ② EXISTING LIGHT FIXTURES TO REMAIN
- ③ EXISTING METAL AWNING TO REMAIN
- ④ EXISTING 2X4 LIGHT FIXTURES TO REMAIN (TYP.)
- ⑤ EXISTING SUSPENDED BAY LIGHTING TO REMAIN; FIXTURES TO BE PAINTED (TYP.)




1450 N. Benson Ave.,
Upland, CA 91786 USA
www.anabioli.com - (909) 394-4728

PROJECT FILE NAME:	REBEL REMODEL WITH DRIVE-THRU & GAMING	REVISION #:	DESIGNER:	PAGE:
PROJECT ADDRESS:	1300 W. NORMANTOWN RD. ROMEOVILLE, IL	32	DV	D1.1
		STORE #:	DATE:	SCALE:
		868	02-05-2025	1/4" = 1'-0"





02-17-2025
SEAL

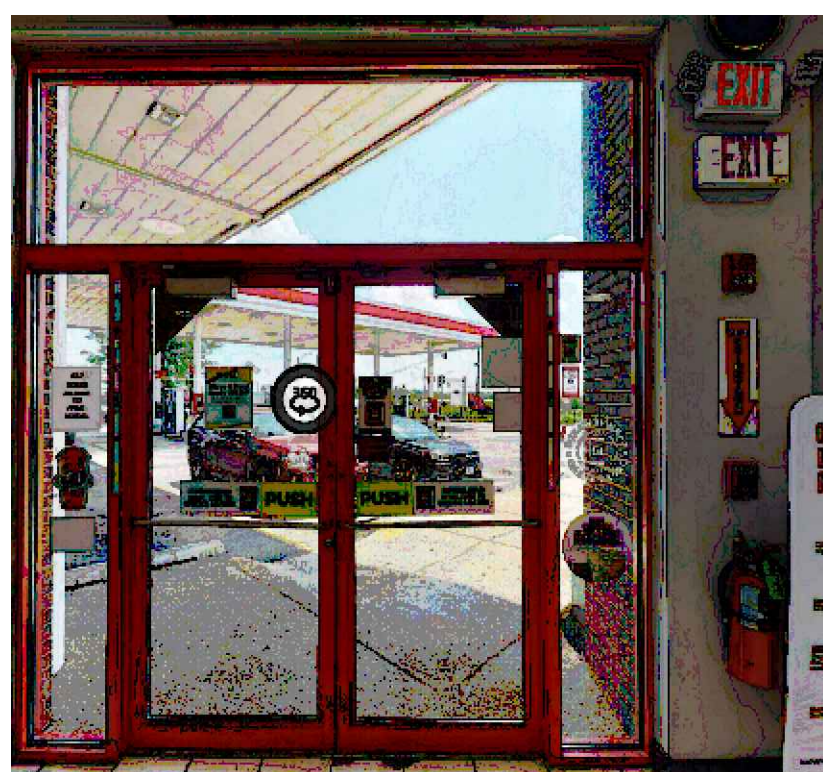

LIFE SAFETY KEYNOTE LEGEND:

- ① EXISTING STANDARD EXIT SIGN TO REMAIN
- ② EXISTING FIRE ALARM AND PULL SWITCH TO REMAIN
- ③ EXISTING BUG EYE EXIT SIGN TO REMAIN
- ④ EXISTING FIRE DEPARTMENT WATER CONNECTION TO REMAIN
- ⑤ EXISTING FIRE ALARM CONTROL PANEL TO REMAIN
- ⑥ INSTALL NEW AED (AUTOMATIC EXTERNAL DEFIBRILLATOR) AND APPROPRIATE SIGNAGE IF ONE IS NOT ALREADY PRESENT AT STORE
- ⑦ EXISTING KNOX BOX TO REMAIN

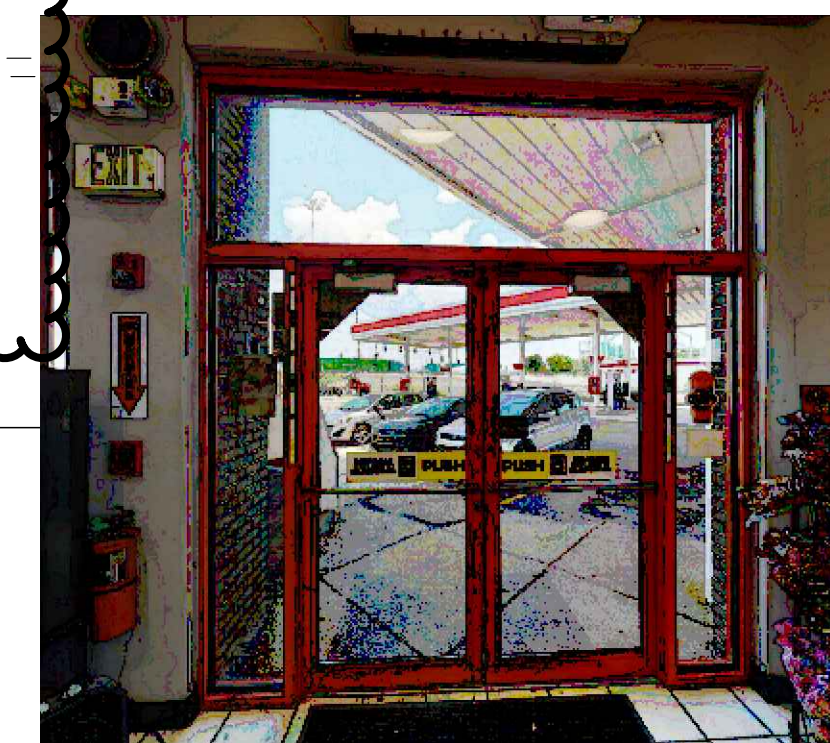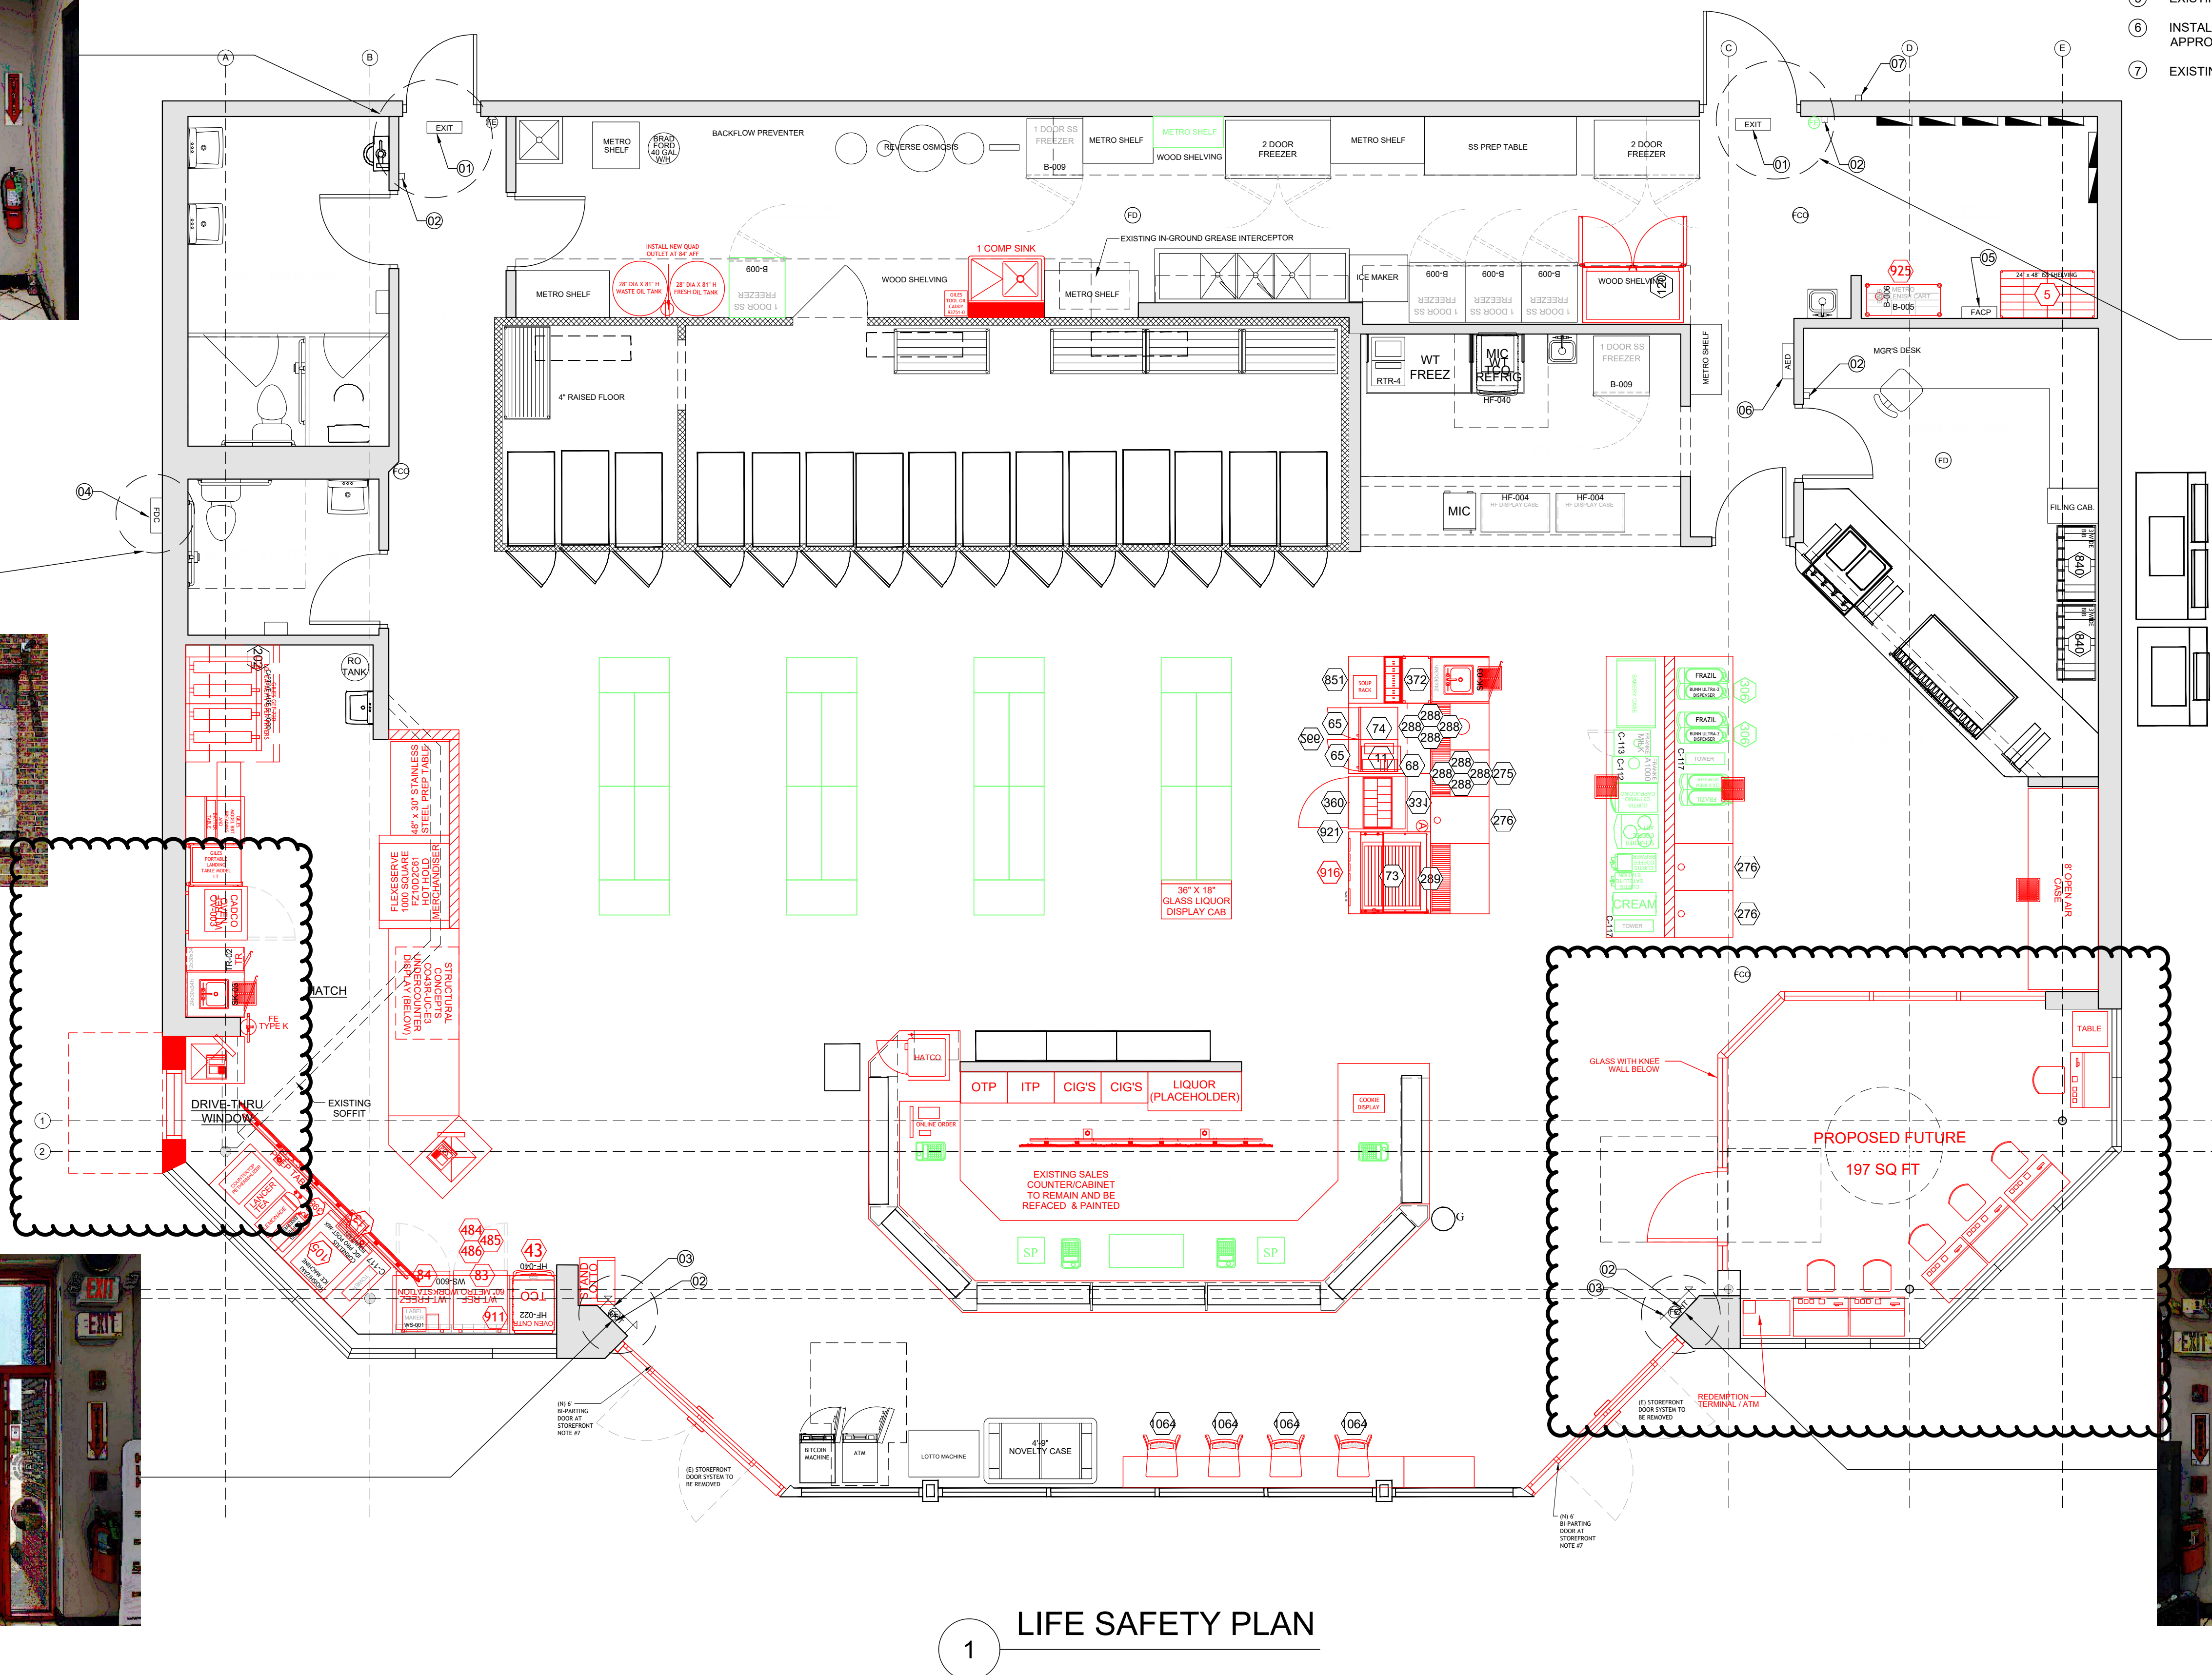

LINE TYPE LEGEND

- NEW CONDITIONS
- RELOCATE EXISTING CONDITIONS (WITHIN STORE)
- RELOCATE EXISTING CONDITIONS (ANOTHER OUTSIDE LOCATION)
- EXISTING CONDITIONS

1

LIFE SAFETY PLAN

CODE NOTES:

EXTERIOR DOOR OF THE FIRE SPRINKLER ROOM MUST READ "FIRE SPRINKLER ROOM" AND "FACP" ON THE EXTERIOR OF THE DOOR IN 4" MINIMUM LETTERING OF CONTRASTING COLOR TO THE DOOR.

ALL INTERIOR AND EXTERIOR STORAGE, ELECTRICAL, MECHANICAL, CUSTODIAL, HOUSEKEEPING, AND IT ROOMS OR CLOSETS SHALL BE LABELED AS SUCH ON THE EXTERIOR OF THE DOORS PER IFC 2015.



1450 N. Benson Ave.,
Upland, CA 91786 USA
www.anabioli.com - (909) 394-4728

PAGE:

LS1.0

DESIGNER:

DV

REVISION #:

32

PROJECT FILE NAME:

REBEL REMODEL WITH DRIVE-THRU & GAMING

PROJECT ADDRESS:

1300 W. NORMANTOWN RD. ROMEOVILLE, IL

SCALE:


1/4" = 1'-0"

DATE:

02-05-2025

STORE #:

868

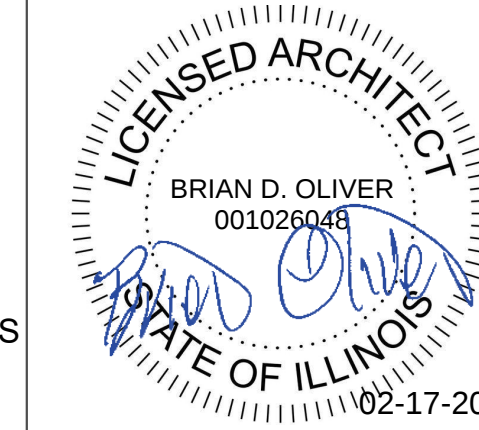02-17-2025
SEAL

LAYOUT INFORMATION

ROLLER GRILLS 2 (SELF SERVE)
SANDWICH CASE 1 CID
VAULT DOORS 15 (EXISTING)
BEER CAVE NO
CRAFT BEER DOORS 0
ICE MERCH. DOORS 1 (OUTDOOR)
NOVELTY DOORS 0
BAKERY CASE 1
FROZEN BARRELS 4
GONDOLA UNITS (60"H) 08
END CAPS (60"H) 07
LOW WALLS (36"H) 00
HIGH WALLS (72"H) 00

TOTAL SQ FT = 4,646 SF
SALES FLOOR AREA = 2,595 SF
GAS: YES LIQUOR: YES
BEER: YES WINE: NO
OCCUPANCY LOAD (>500) = 53
TRAVEL DISTANCE (<200) = 66'
COMMON PATH OF TRAVEL (<75) = 58'
RESTROOMS REQUIRED = 2
EXITS REQUIRED = 2
OVERHEAD SHELVES = 64 FT
FLOOR SHELVES = 16 LINEAR FT

OCCUPANCY CALCULATION


MERCHANDISE	2,595 SF	/	60	=	43 PEOPLE
SALES	244 SF	/	200	=	2 PEOPLE
QSR AREA	326 SF	/	60	=	5 PEOPLE

ELEC./STORAGE	86 SF	/	300	=	1 PEOPLE
BACK ROOM	489 SF	/	300	=	2 PEOPLE
HALLWAY	81 SF	/	200	=	1 PEOPLE

WALK-IN COOLER	334 SF	/	N/A	=	0 PEOPLE
RESTROOM	188 SF	/	N/A	=	0 PEOPLE
TOTAL				=	54 PEOPLE

LINE TYPE LEGEND

—	NEW CONDITIONS
—	RELOCATE EXISTING CONDITIONS (WITHIN STORE)
—	RELOCATE EXISTING CONDITIONS (ANOTHER OUTSIDE LOCATION)
—	EXISTING CONDITIONS

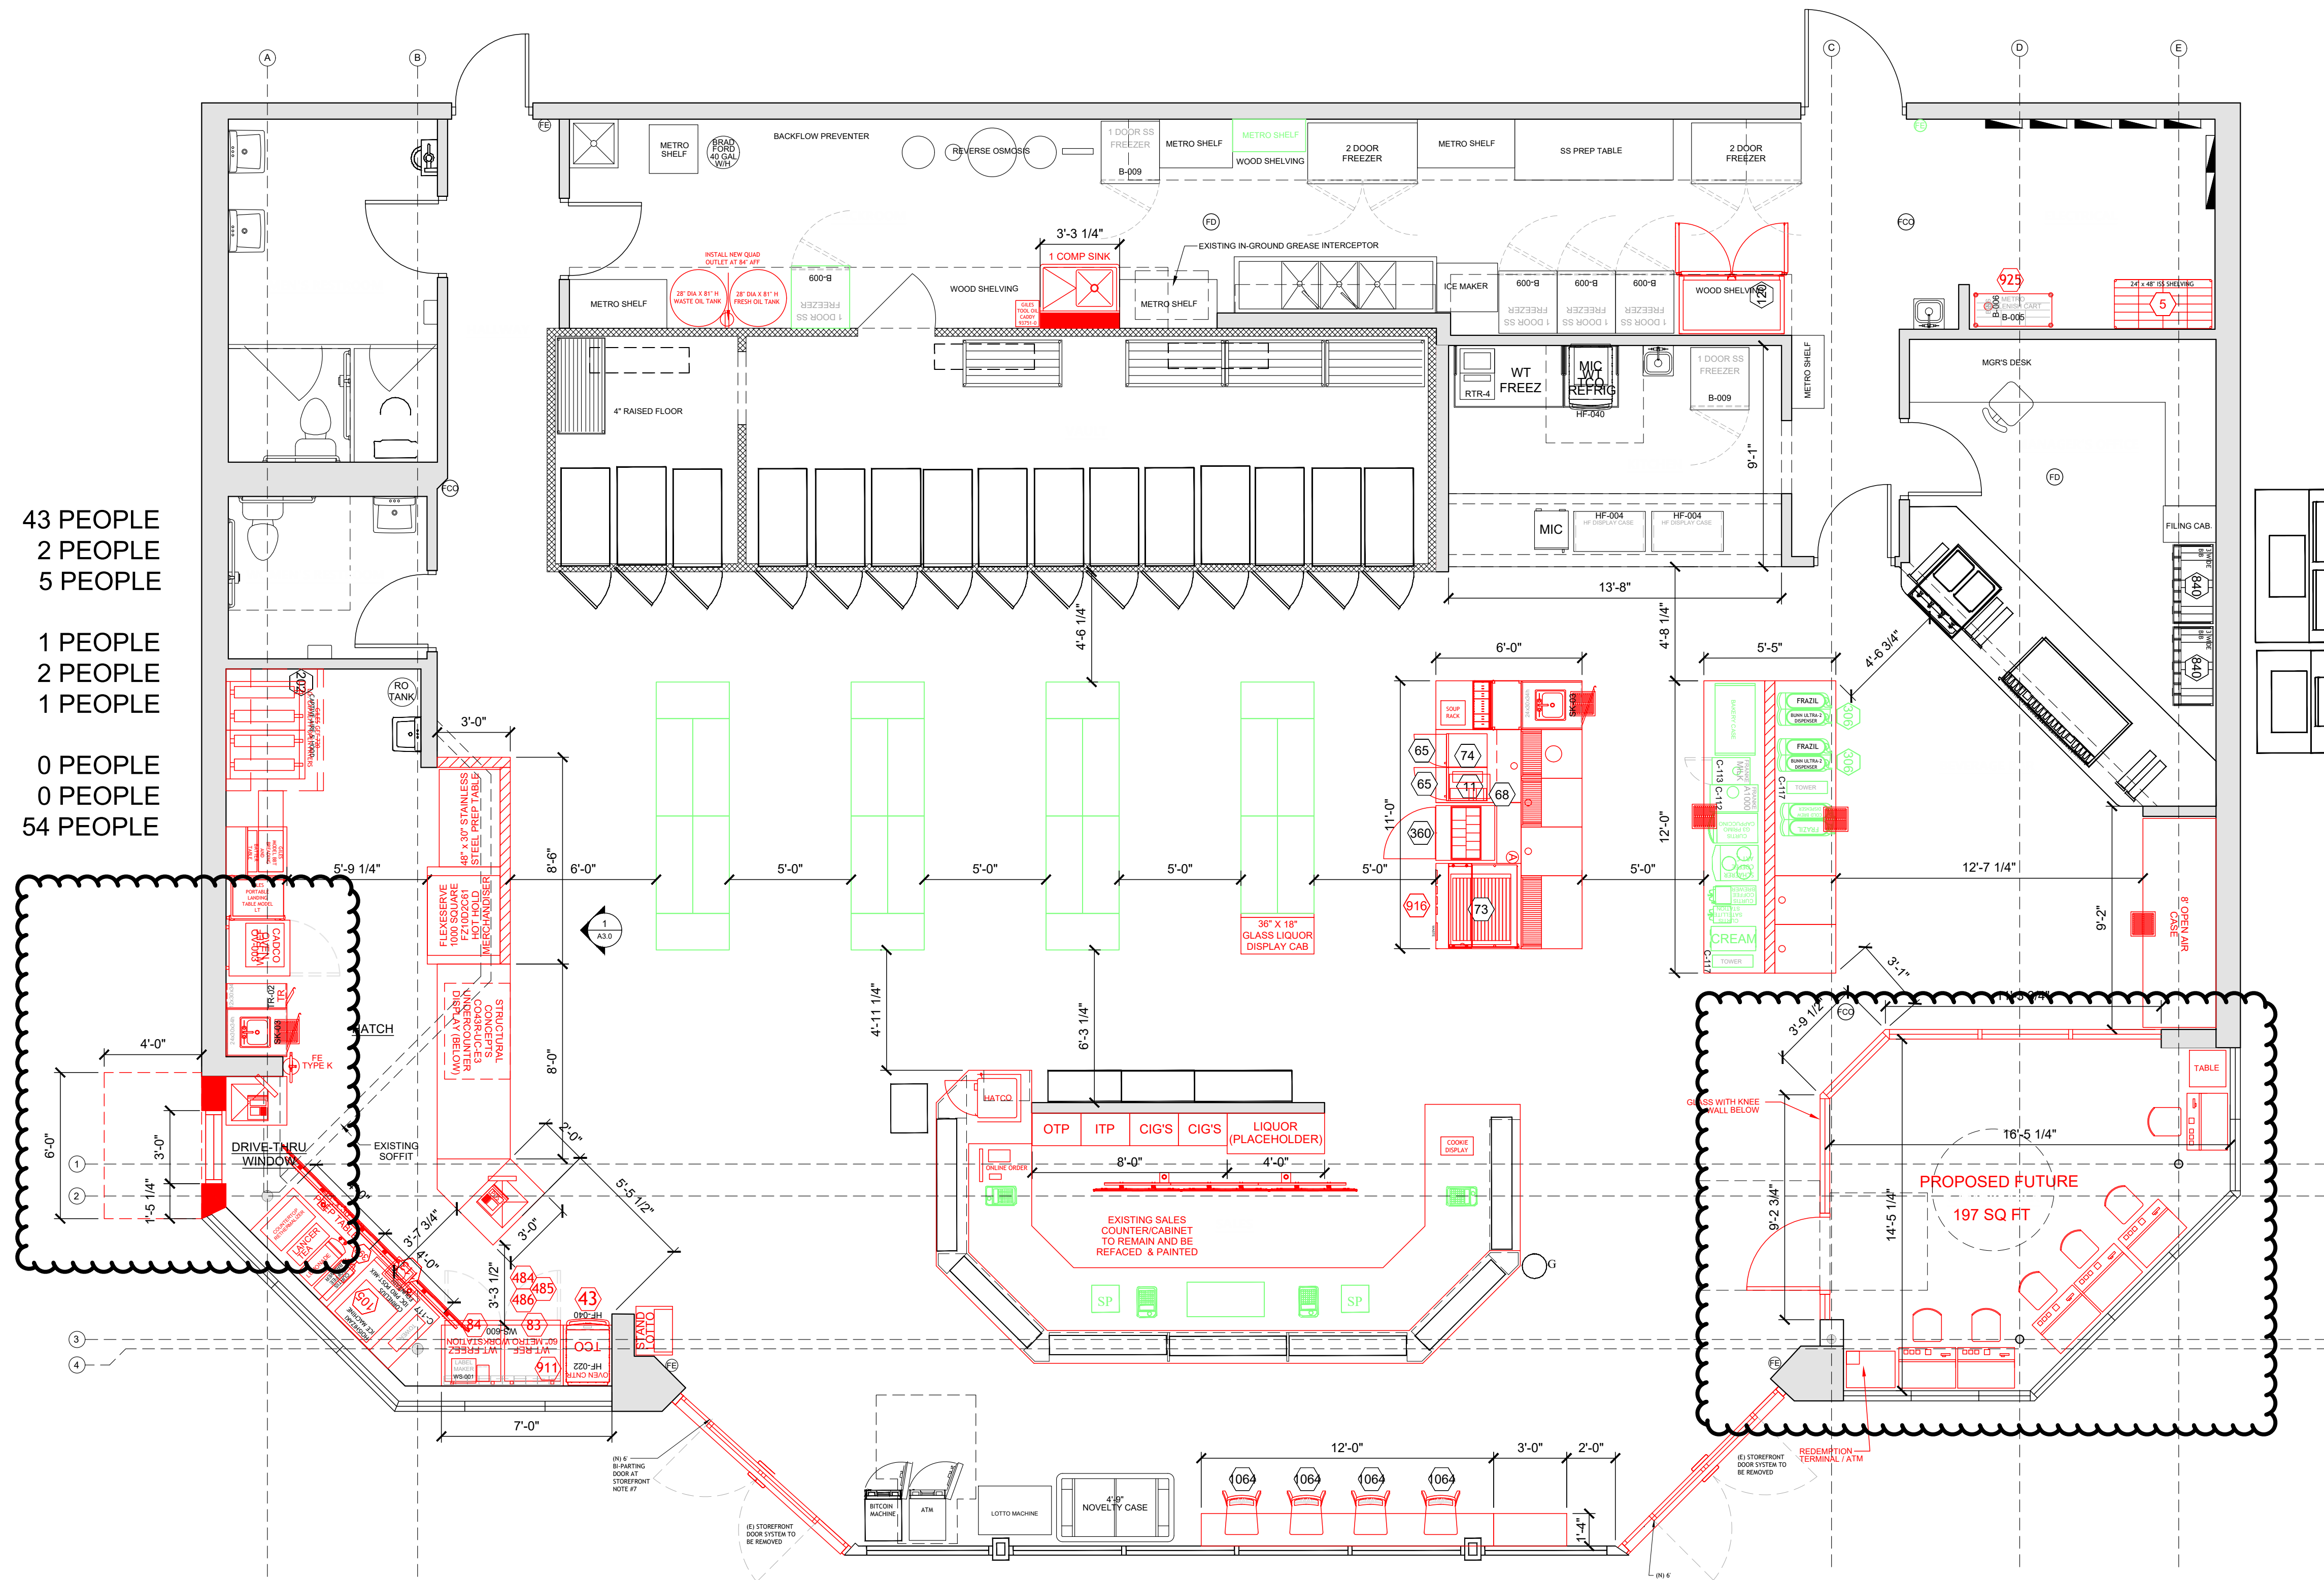



1 PROPOSED DIMENSION FLOOR PLAN



1450 N. Benson Ave.,
Upland, CA 91786 USA
www.anabioll.com - (909) 394-4728

PAGE:	DESIGNER:	REVISION #:	PROJECT FILE NAME:
A1.0	DV	32	REBEL REMODEL WITH DRIVE-THRU & GAMING
SCALE:	DATE:	STORE #:	PROJECT ADDRESS:
1/4" = 1'-0"	02-05-2025	868	1300 W. NORMANTOWN RD. ROMEOVILLE, IL

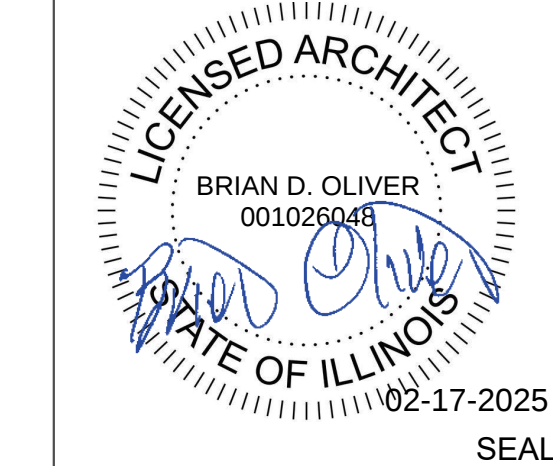

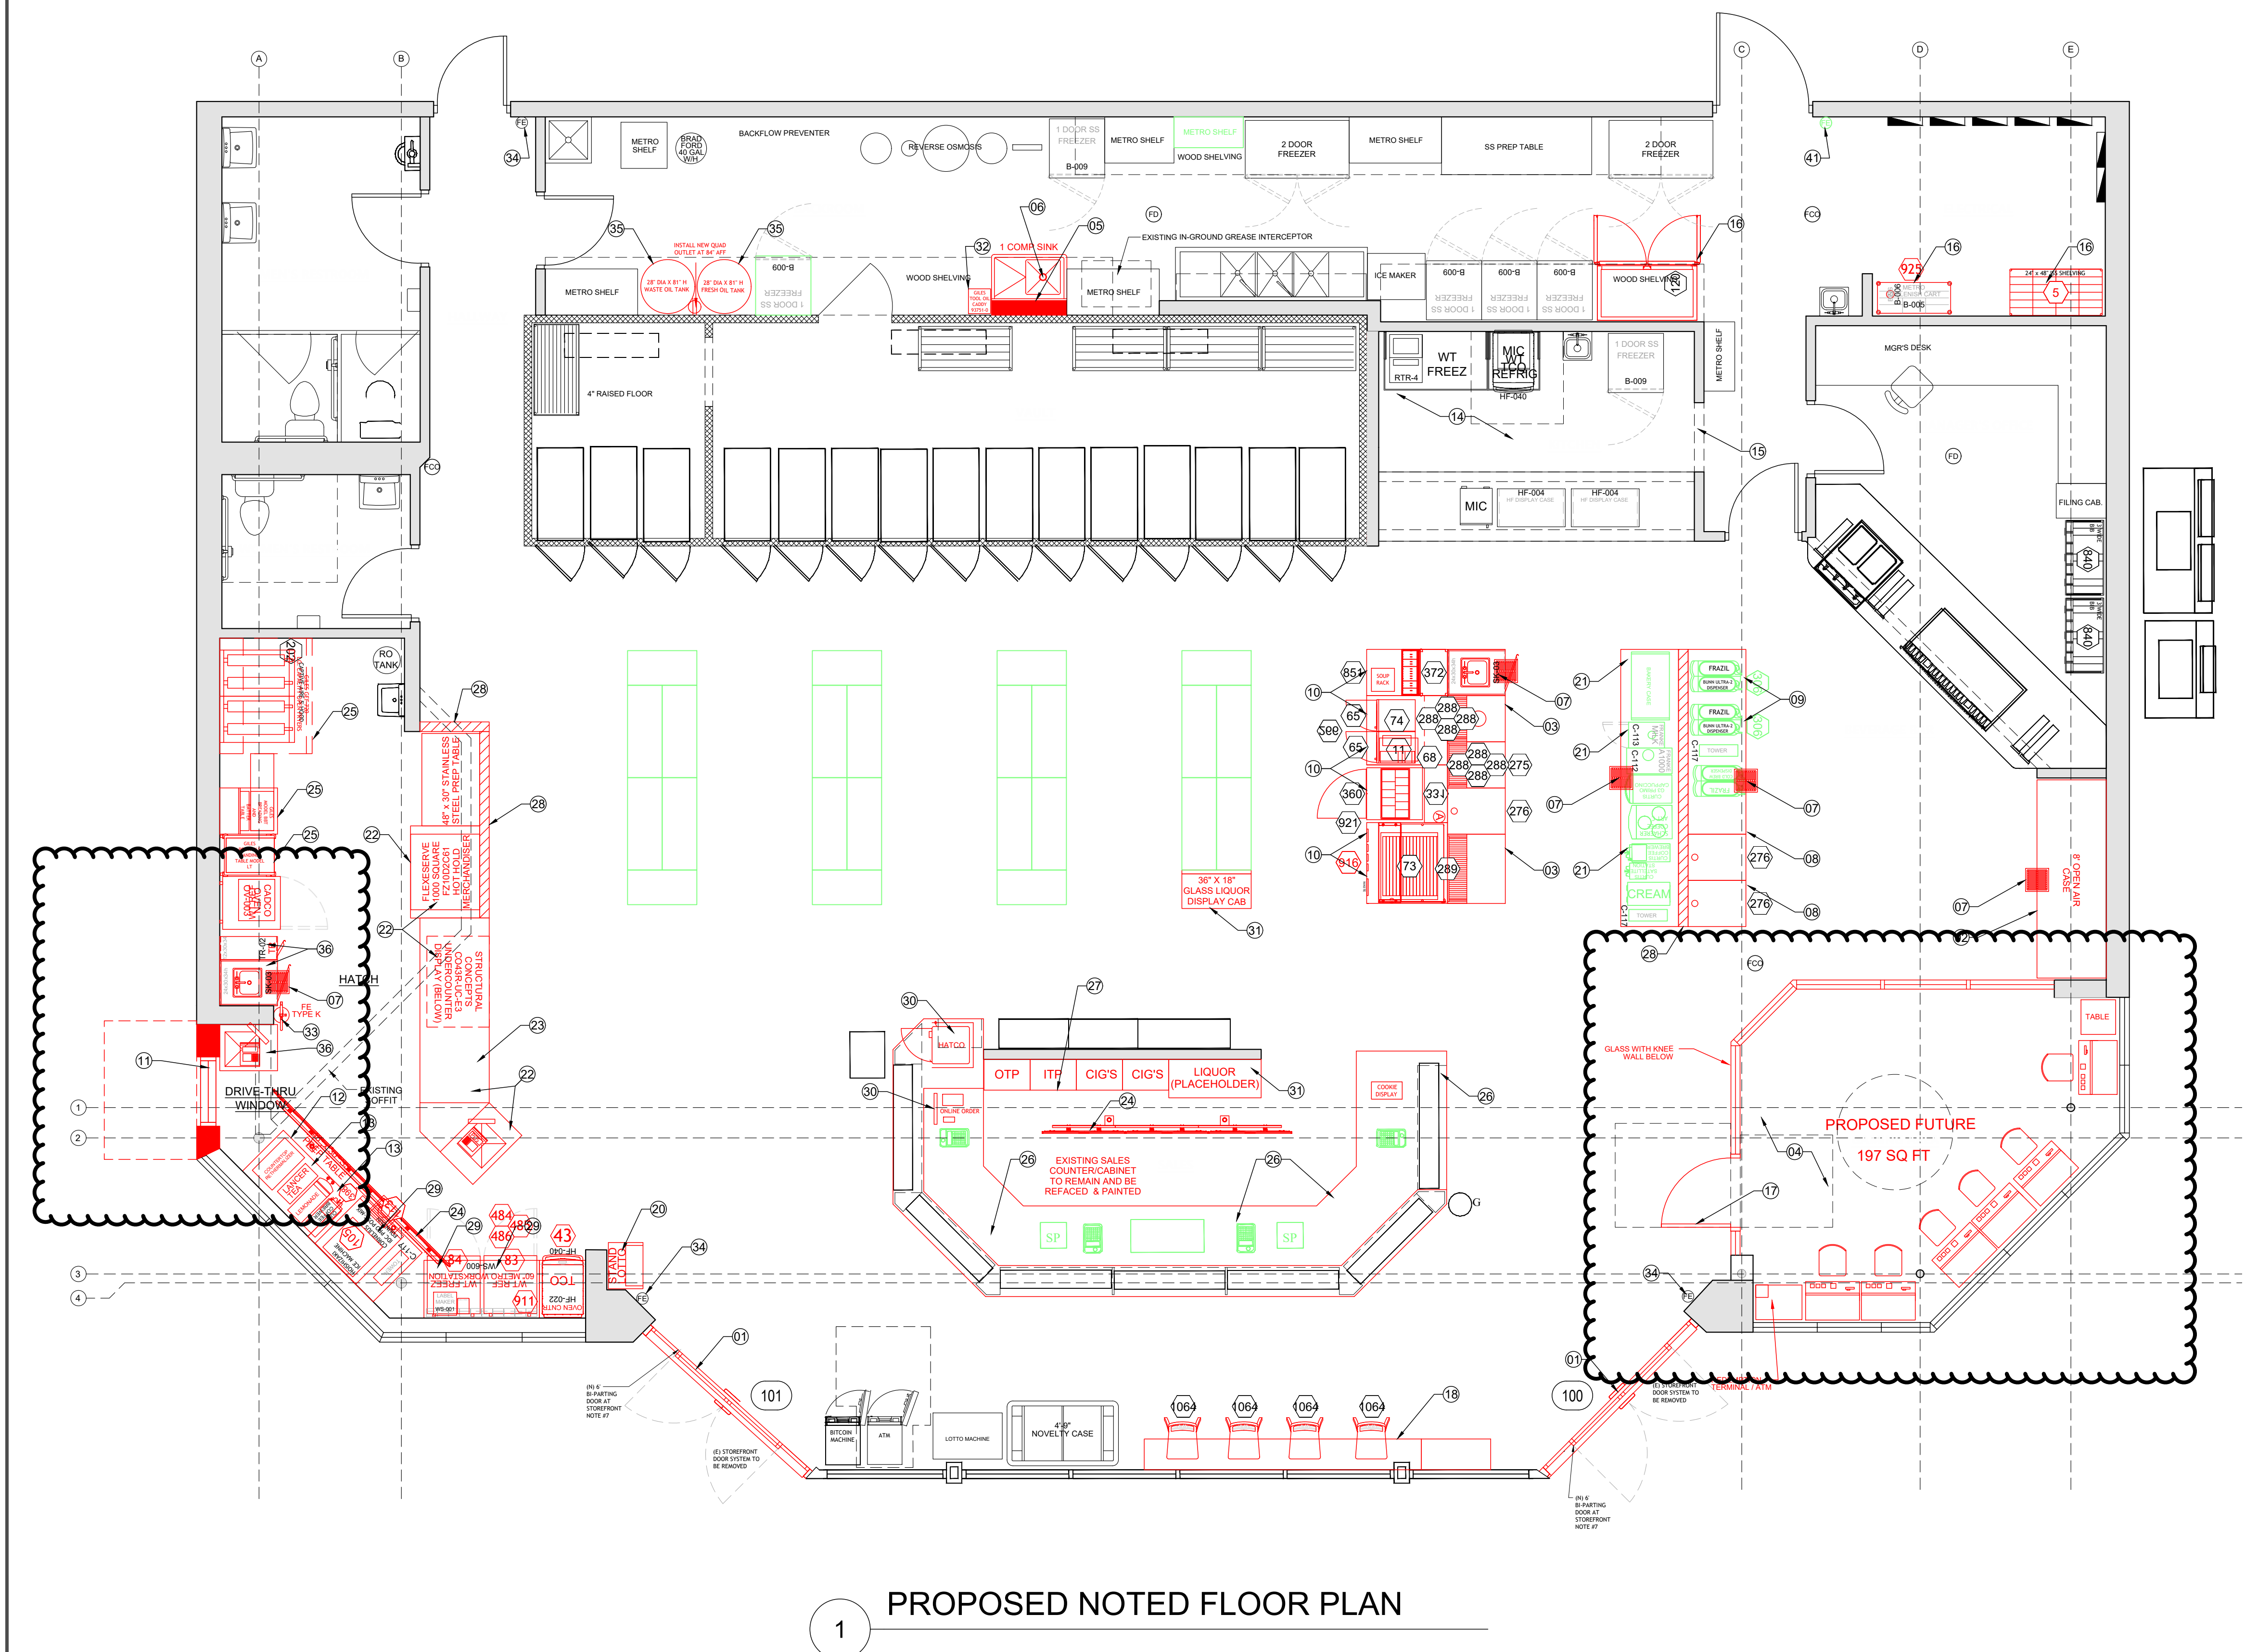

LINE TYPE LEGEND	
—	NEW CONDITIONS
—	RELOCATE EXISTING CONDITIONS (WITHIN STORE)
—	RELOCATE EXISTING CONDITIONS (ANOTHER OUTSIDE LOCATION)
—	EXISTING CONDITIONS

DEMO KEYNOTE LEGEND

- 1 INSTALL NEW AUTOMATIC SLIDING DOORS AND SIDELIGHTS; GO TO PREPARE EXISTING OPENING FOR INSTALLATION OF NEW ENTRY
- 2 INSTALL NEW 8" OPEN AIR CASE
- 3 INSTALL NEW COFFEE PREP ISLAND
- 4 INSTALL NEW GAMING AREA WITH CHAIRS AND MACHINES
- 5 INSTALL NEW FUR OUT WALL TO MATCH EXISTING HEIGHT AND FINISH
- 6 INSTALL NEW 1-COMP SINK; TIE TO EXISTING PLUMBING SANITARY
- 7 INSTALL NEW FLOOR DRAIN; REFER TO PLUMBING DRAWINGS FOR SPECS
- 8 INSTALL NEW BEVERAGE CABINETS PER PLAN
- 9 NEW LOCATION FOR RELOCATED FRAZIL MACHINES
- 10 INSTALL NEW FOOD SERVICE CABINETRY INCLUDING SELF-SERVE ROLLER GRILLS, CONDIMENT STATION, MICROWAVES, CHILI CHEESE, AND NACHO RACK
- 11 INSTALL NEW WINDOW AT DRIVE-THRU
- 12 INSTALL NEW 48" X 30" STAINLESS STEEL PREP TABLE
- 13 INSTALL NEW LEMONADE DISP, TEA DISP, AND RETHERMALIZER
- 14 MODIFY EXISTING KITCHEN AREA FOR NEW MERCHANDISE AREA (TBD)
- 15 EXISTING CASED OPENING TO REMAIN; NO CHANGES
- 16 INSTALL NEW MOBILE METRO REPLENISH CART, 2 DOOR FREEZER, AND 48" X 24" METRO SHELVING IN BACKROOM
- 17 INSTALL NEW LOCKABLE GLASS DOOR AND FRAME
- 18 INSTALL NEW LEAN BAR SEATING - TABLES AND CHAIRS
- 19 INSTALL NEW 72" X 30" STAINLESS STEEL PREP TABLE AND TRASH
- 20 INSTALL NEW LOTTO STAND
- 21 INSTALL RELOCATED COFFEE EQUIPMENT ON NEW CABINETRY
- 22 INSTALL NEW QSR CABINETS, GILES DISPLAY CASE, & POS REGISTER
- 23 INSTALL NEW TURBO CHEF UNDER COUNTER REF. MERCHANDISER
- 24 INSTALL NEW CEILING MOUNTED DIGITAL MENU BOARDS IN QSR & SALES AREAS; EXACT LOCATIONS TO BE FIELD VERIFIED
- 25 INSTALL NEW VENT HOOD, FRYERS, BREADING TABLE, LANDING TABLE, AND HAND SINK
- 26 EXISTING CABINETS TO BE PAINTED AND REFACED WITH NEW COUNTERTOP
- 27 INSTALL NEW 8" CIG, ITP, & OTP MERCHANDISER BACKBAR
- 28 INSTALL NEW KNEE WALLS AT 48" AFF; SEE DETAIL 3/A5.1
- 29 INSTALL NEW TURBO CHEF OVEN & METRO WORKSTATION WITH WORKTOP REF. & FREEZER BELOW. PROVIDE CASTER KITS AS REQ'D
- 30 INSTALL NEW HATCO WARMER, & ONLINE ORDER SYSTEM
- 31 INSTALL NEW LIQUOR GLASS DISPLAY CABINET
- 32 INSTALL NEW OIL CADDY IN BACKROOM
- 33 INSTALL NEW K-TYPE FIRE EXTINGUISHER, SIGNAGE, AND LOCATION MARKINGS PER CHAPTER 91 SECTION 91.61 & NFPA10 (2013)
- 34 EXISTING FIRE EXTINGUISHER TO BE REMOVED AND RE-INSTALLED IN SAME LOCATION
- 35 INSTALL NEW FRESH AND WASTE OIL TANKS
- 36 INSTALL NEW REGISTER AREA, HAND SINK, AND 12" TRASH






1450 N. Benson Ave.,
Upland, CA 91786 USA
www.anabioli.com - (909) 394-4728

PAGE:	A1.1
DESIGNER:	DV
REVISION #:	32
SCALE:	1/4" = 1'-0"
DATE:	02-05-2025
STORE #:	868

PROJECT FILE NAME:
REBEL REMODEL WITH DRIVE-THRU & GAMING

PROJECT ADDRESS:
1300 W. NORMANTOWN RD. ROMEOVILLE, IL

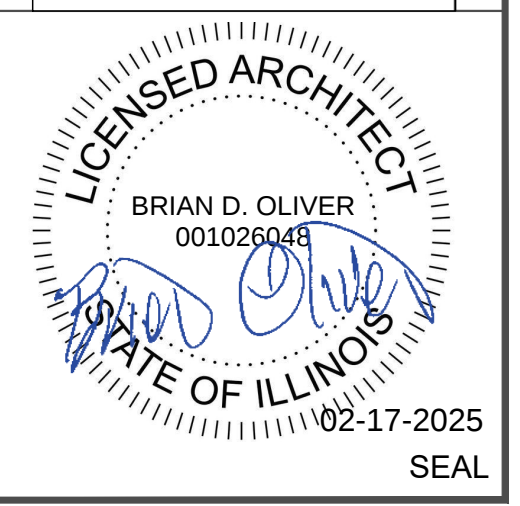

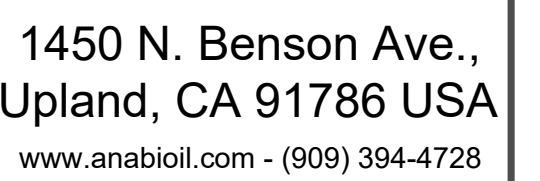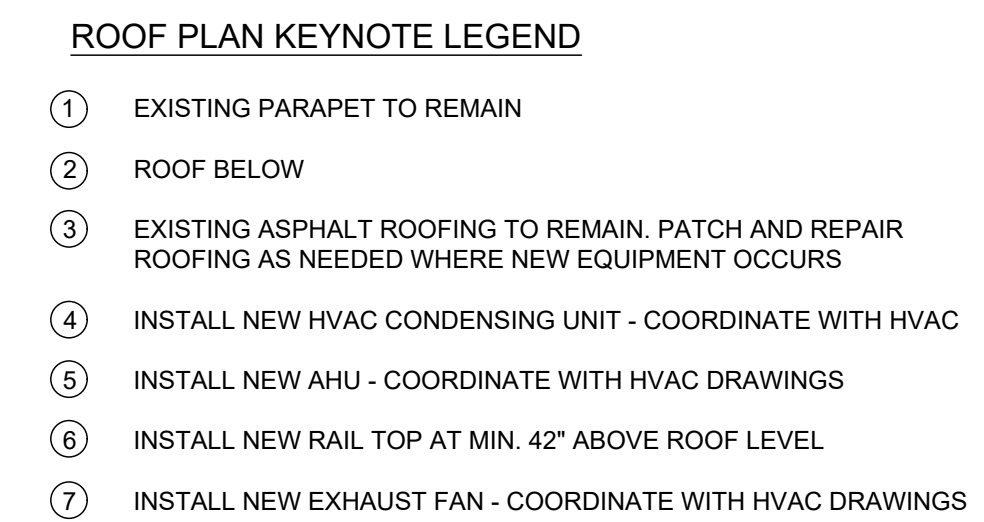

PROJECT FILE NAME:	REVISION #:	DESIGNER:	PAGE:
REBEL REMODEL WITH DRIVE-THRU & GAMING	32	DV	A2.0
PROJECT ADDRESS:	STORE #:	DATE:	SCALE:
1300 W. NORMANTOWN RD. ROMEIOVILLE, IL	868	02-05-2025	1/4" = 1'-0"



02-17-2025
SEAL

LINE TYPE LEGEND



	NEW CONDITIONS
	RELOCATE EXISTING CONDITIONS (WITHIN STORE)
	RELOCATE EXISTING CONDITIONS (ANOTHER OUTSIDE LOCATION)
	EXISTING CONDITIONS




1450 N. Benson Ave.,
Upland, CA 91786 USA
www.anabioli.com - (909) 394-4728

PAGE:	A3.0	SCALE:	VARIES
DESIGNER:	DV	DATE:	02-05-2025
REVISION #:	32	STORE #:	868


PROJECT FILE NAME:	REBEL REMODEL WITH DRIVE-THRU & GAMING
PROJECT ADDRESS:	1300 W. NORMANTOWN RD. ROMEOVILLE, IL

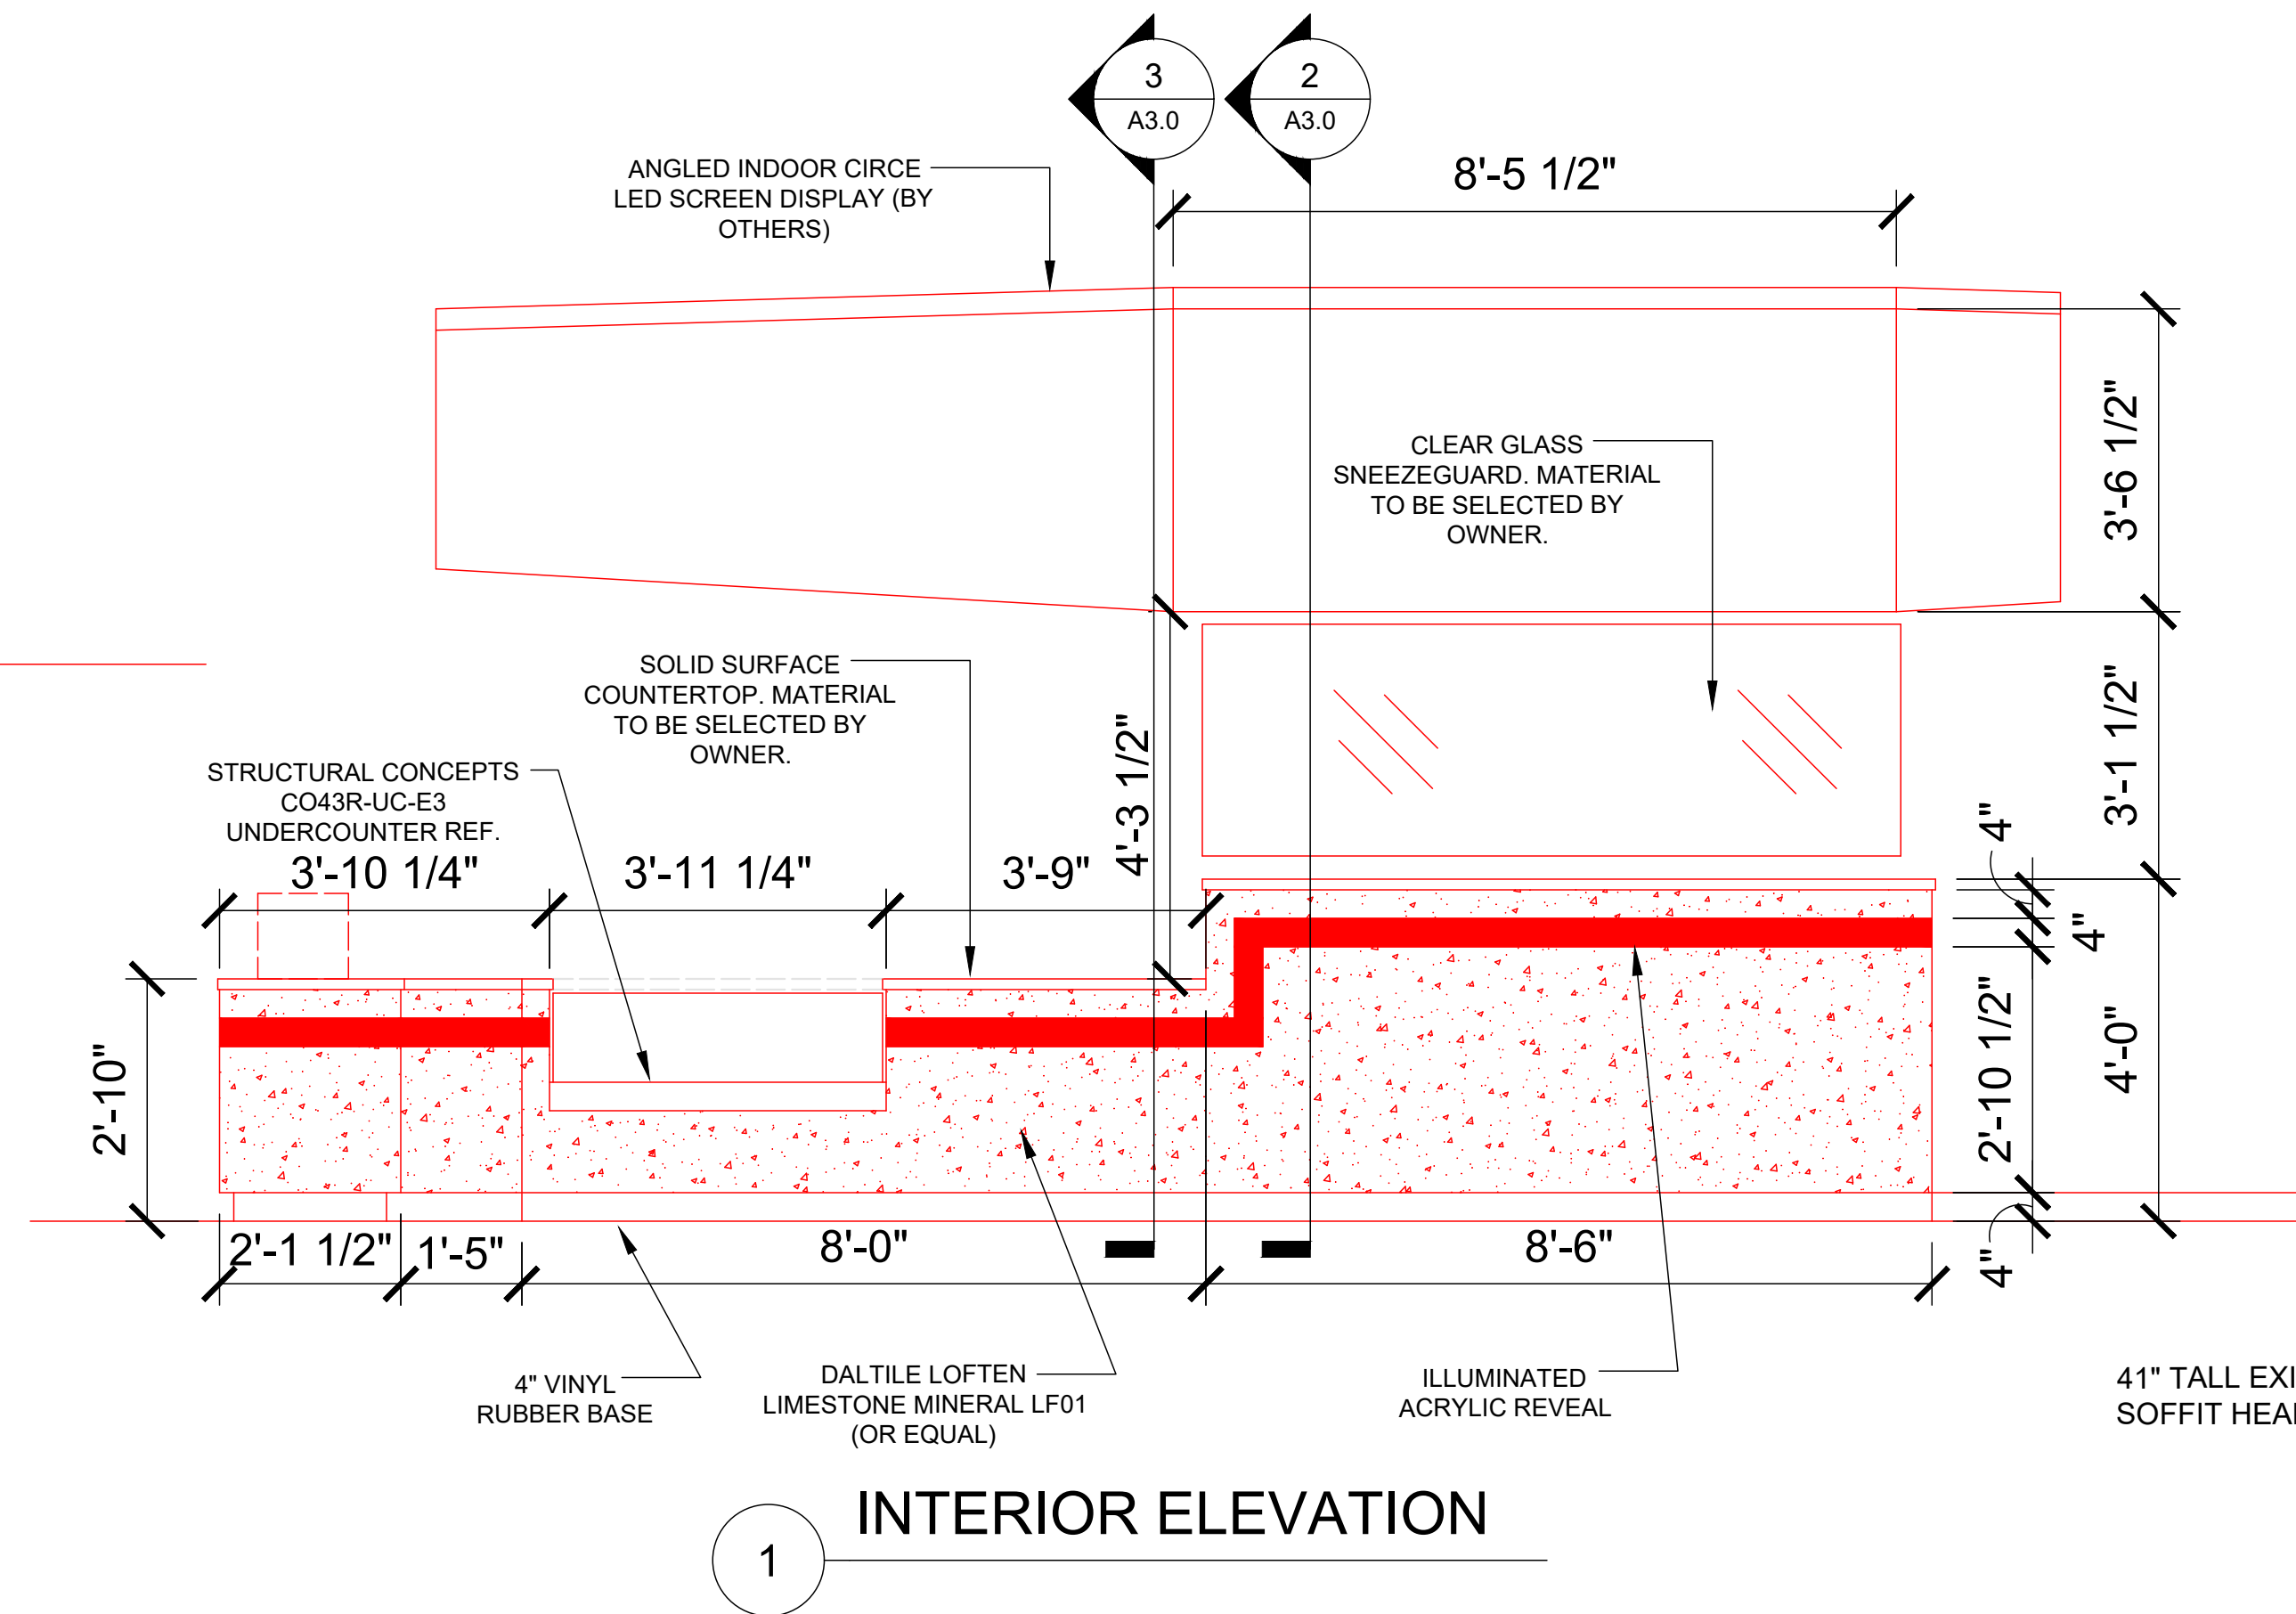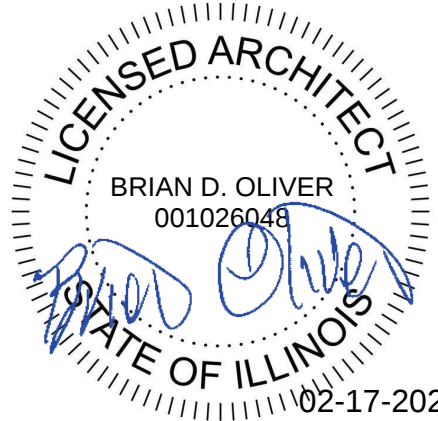


1 INTERIOR ELEVATION

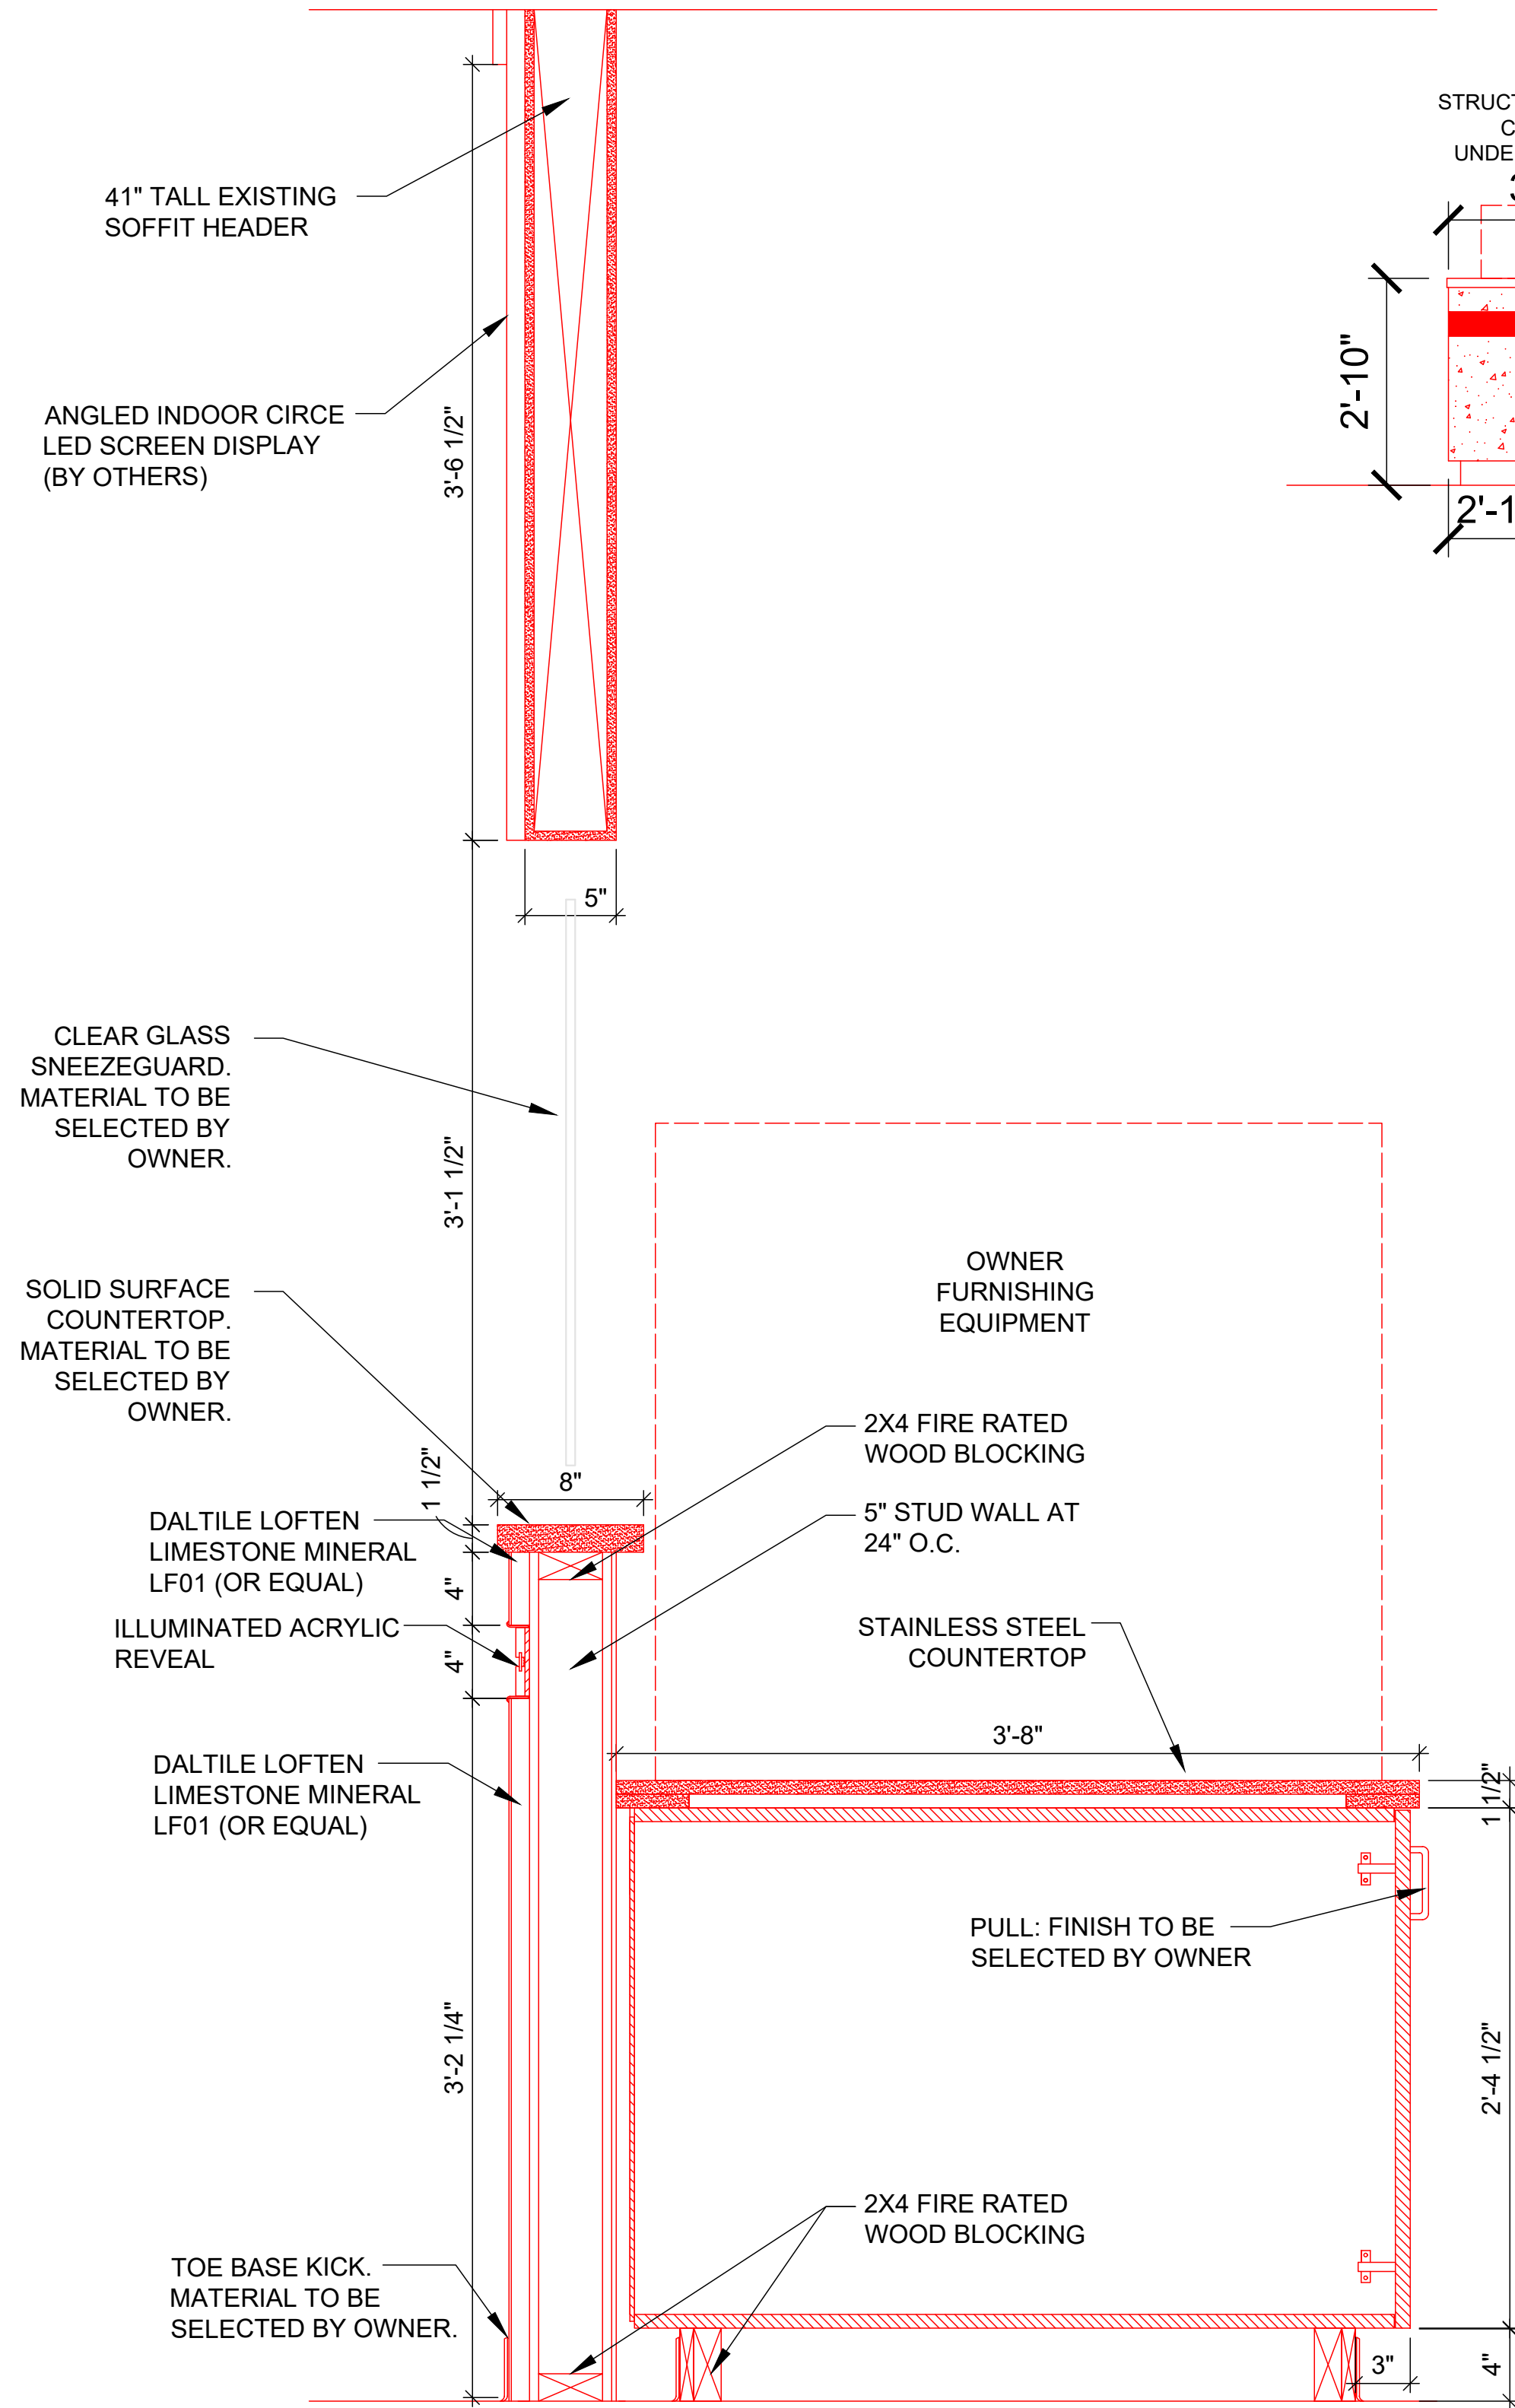


2 SECTION DETAIL

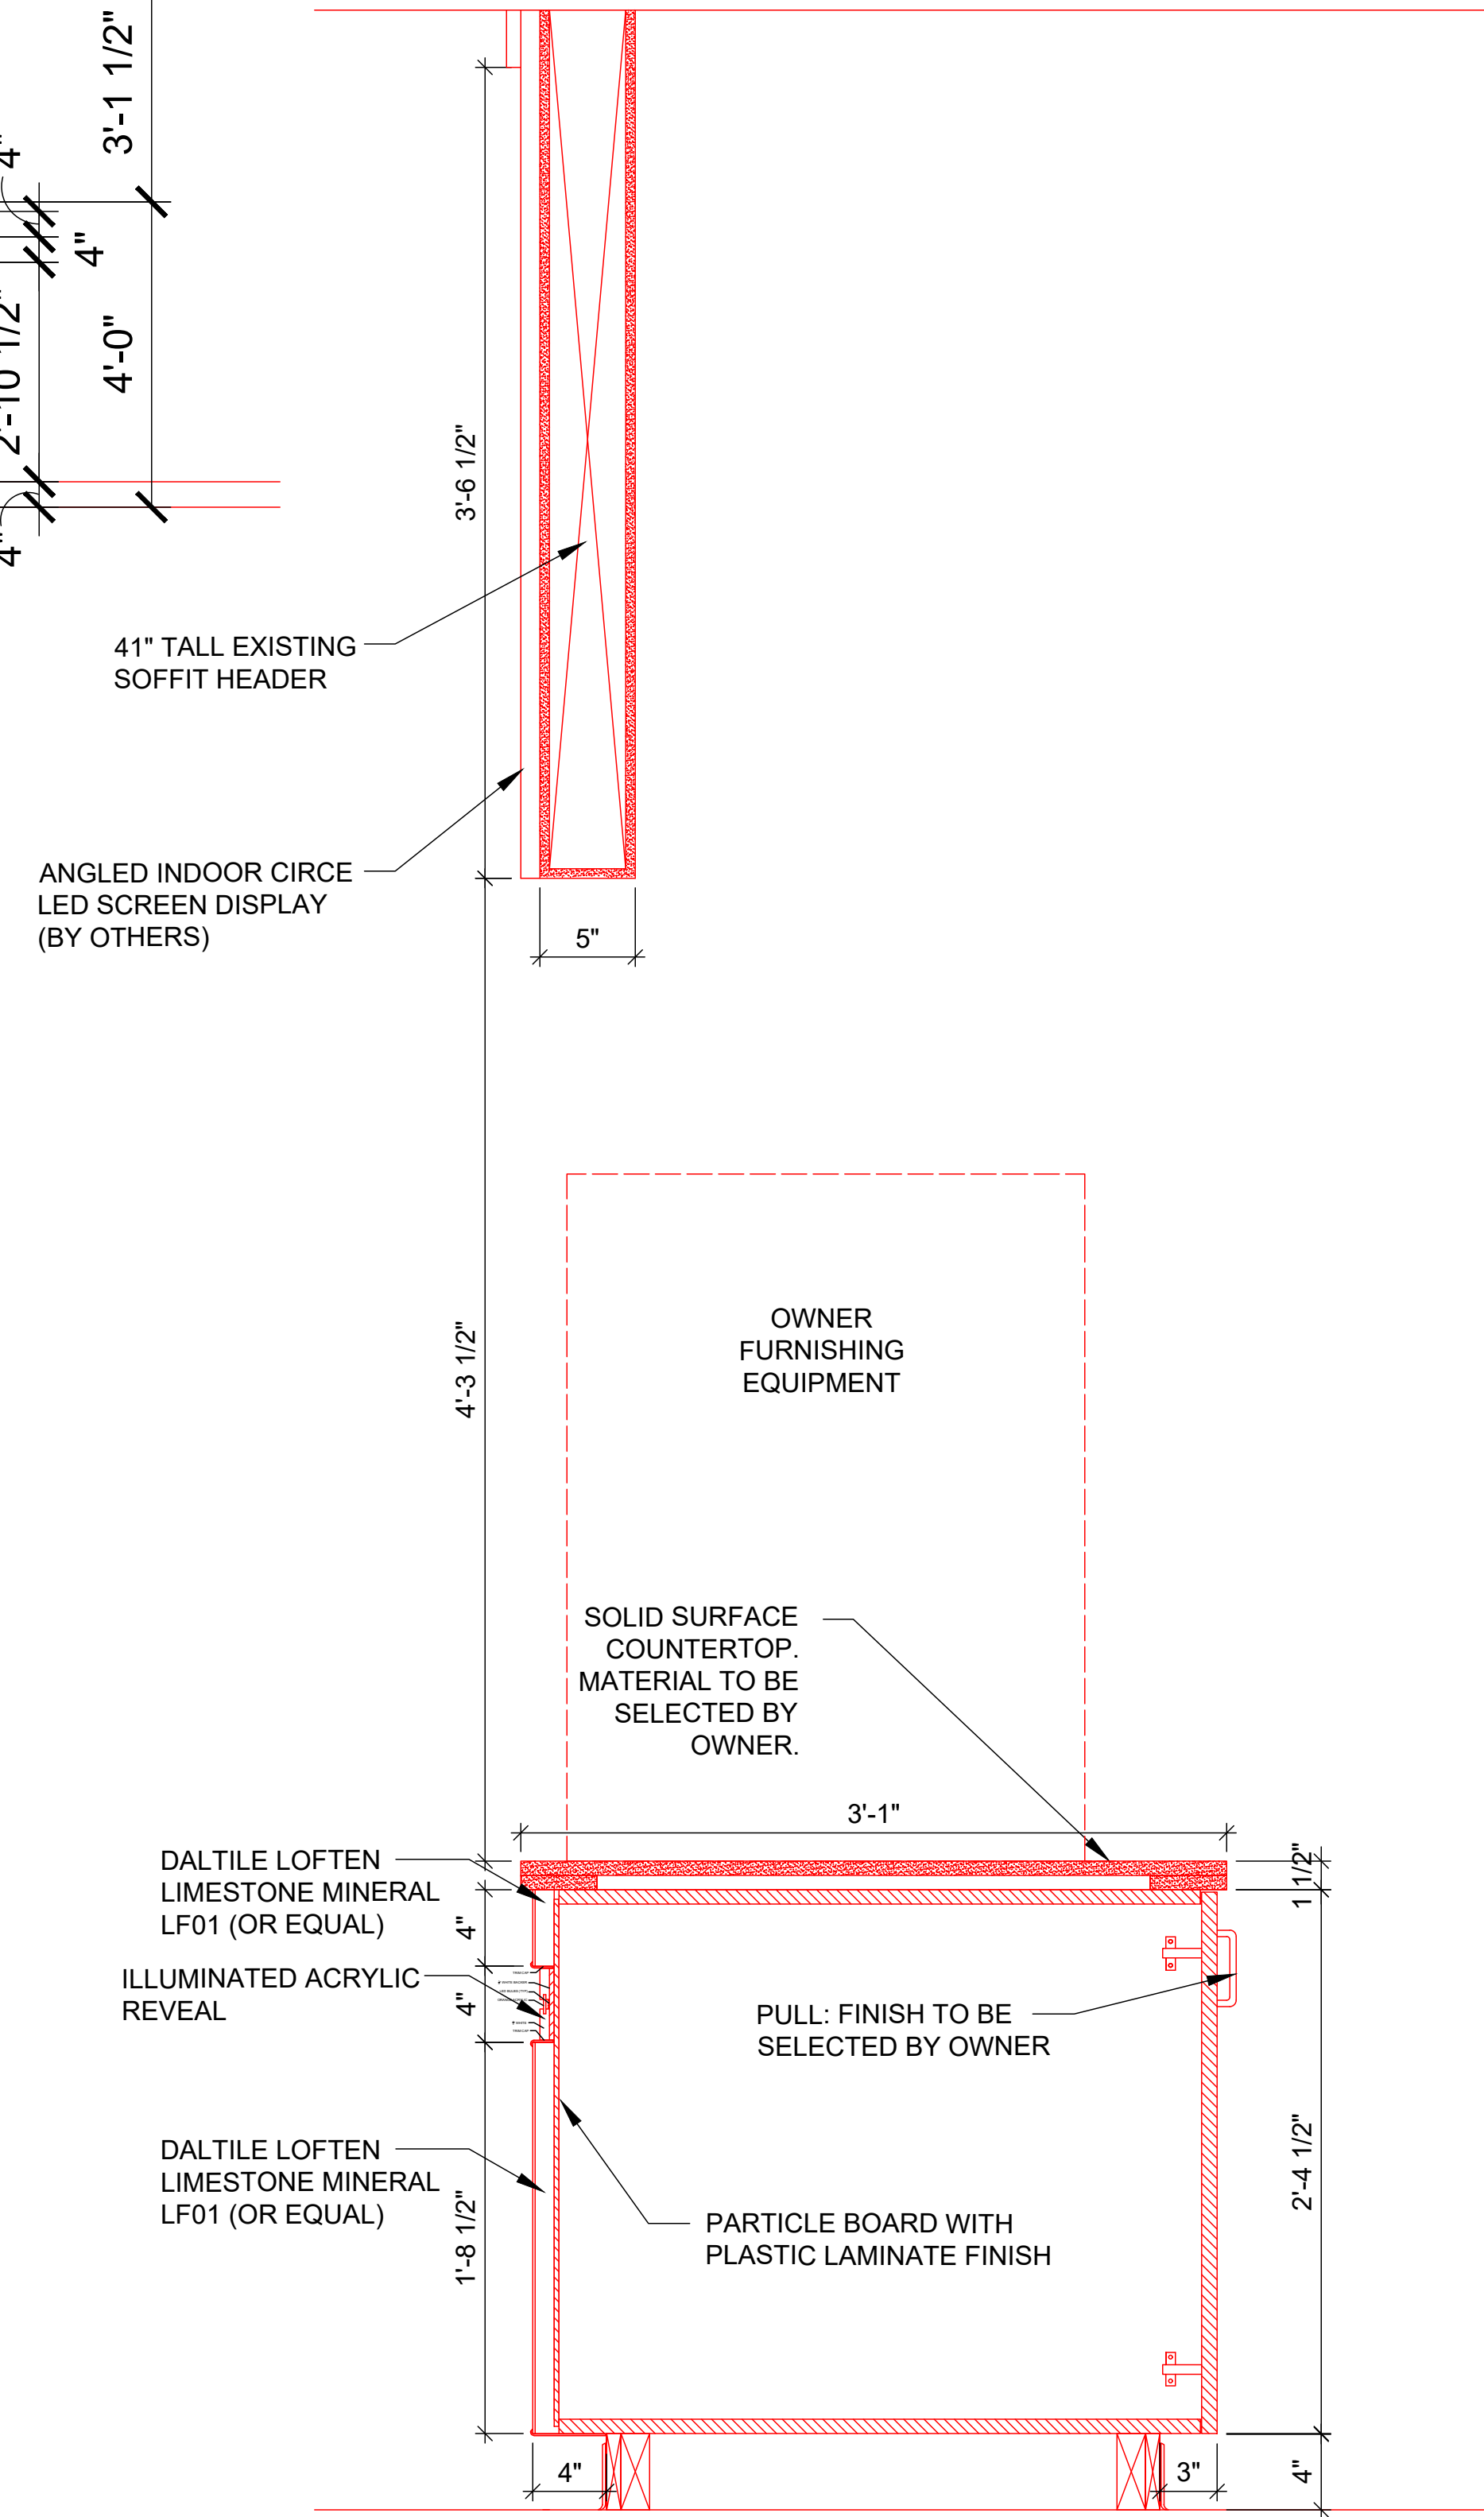

3 SECTION DETAIL

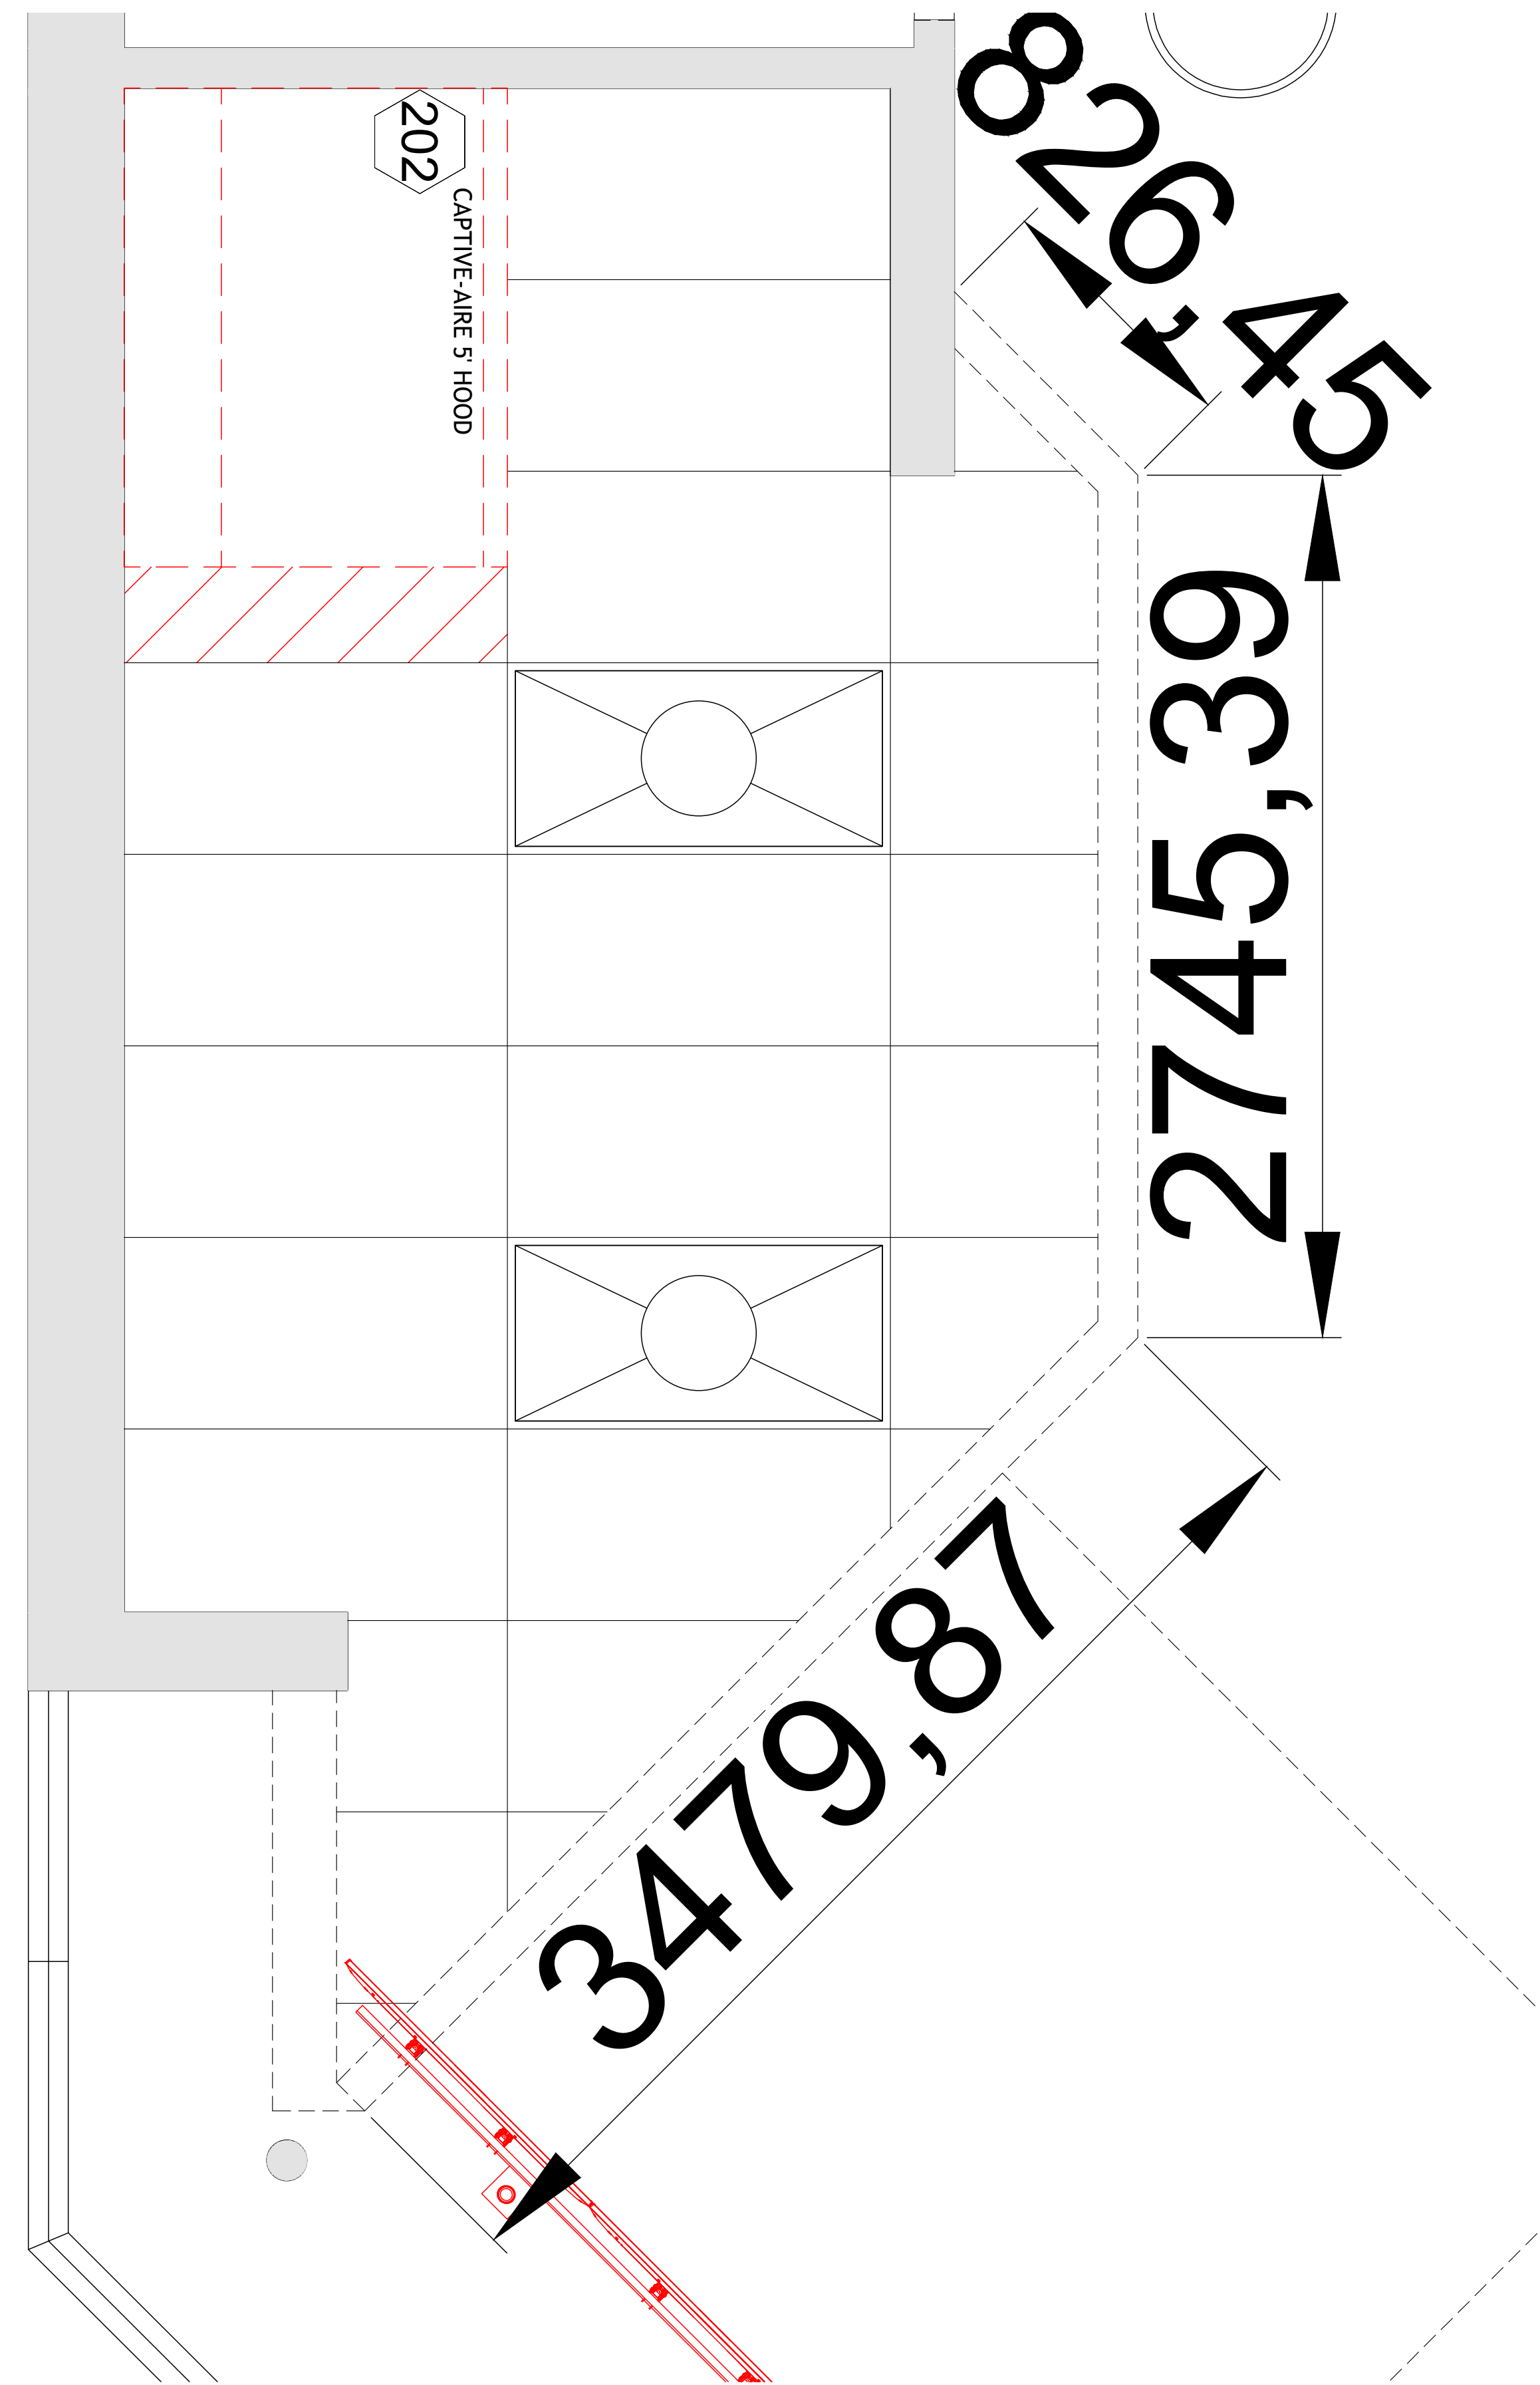

1 EXISTING SOFFIT PLAN - LED SCREEN

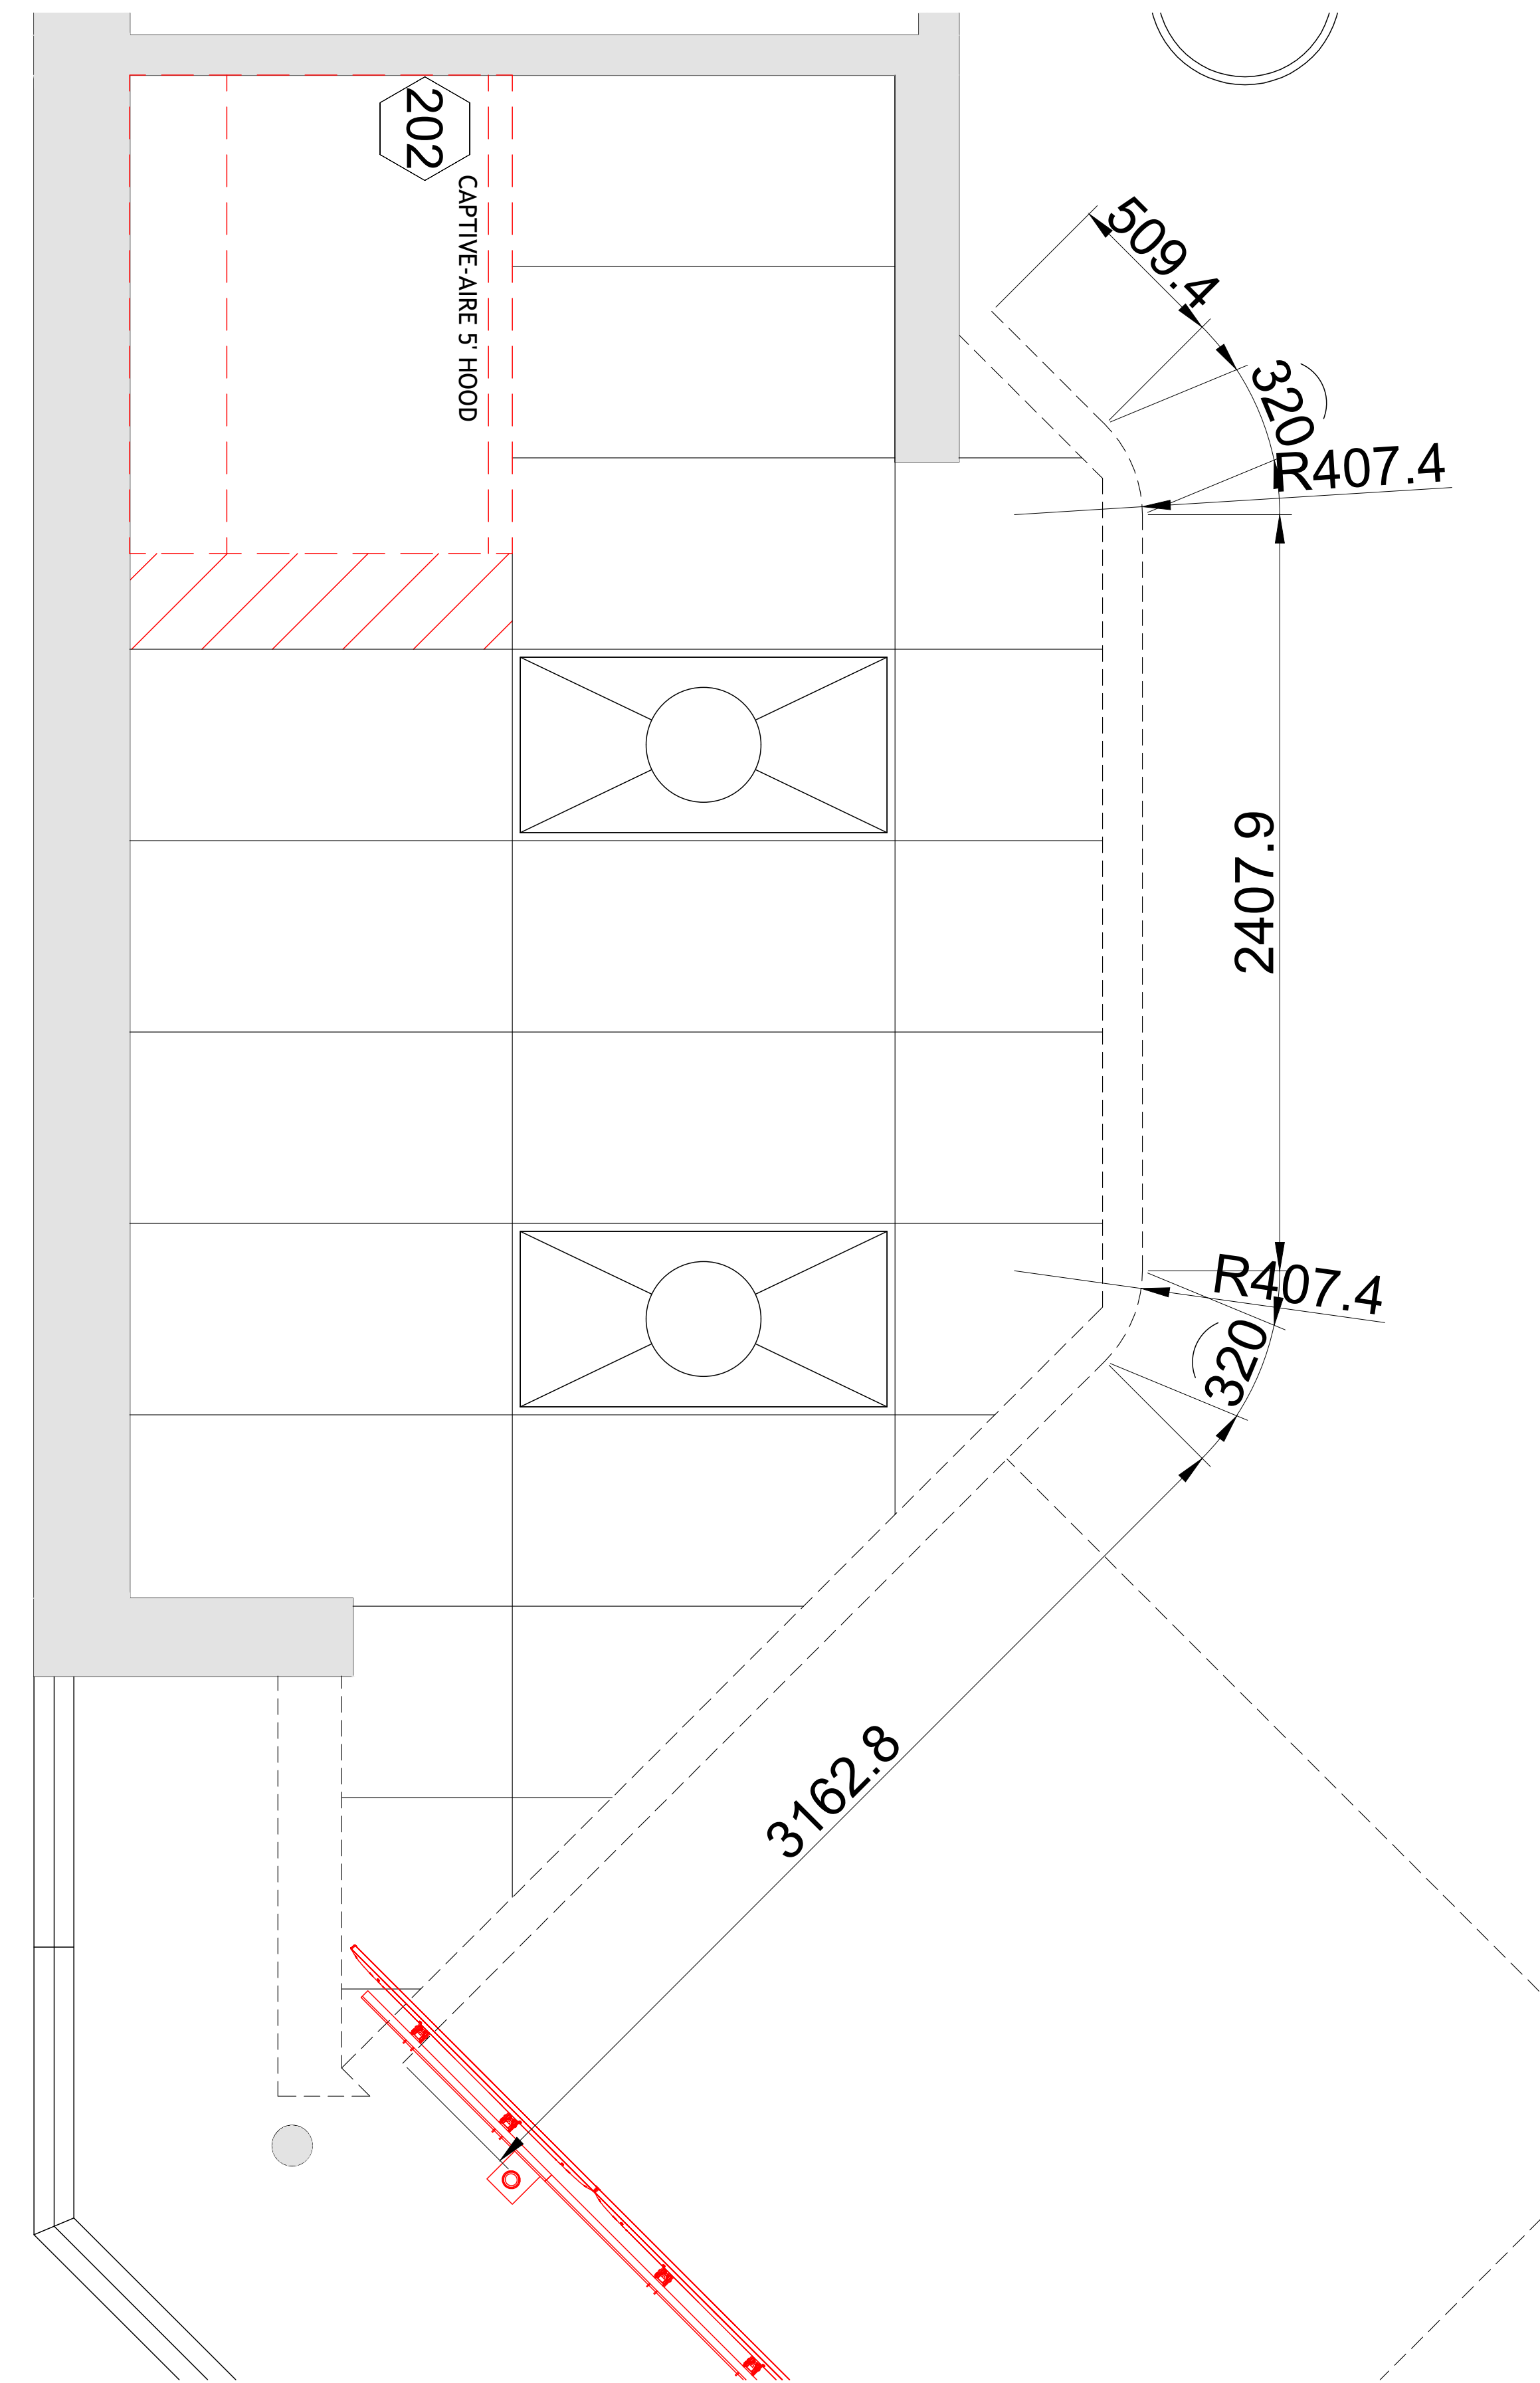

2 PROPOSED SOFFIT PLAN - LED SCREEN




1450 N. Benson Ave.,
Upland, CA 91786 USA
www.anabioli.com - (909) 394-4728


PROJECT FILE NAME:	REBEL REMODEL WITH DRIVE-THRU & GAMING	REVISION #:	DESIGNER:	PAGE:
PROJECT ADDRESS:	1300 W. NORMANTOWN RD. ROMEOVILLE, IL	32	DV	A3.1
		STORE #:	DATE:	SCALE:
		868	02-05-2025	3/4" = 1'-0"




BRIAN D. OLIVER
001026048
STATE OF ILLINOIS

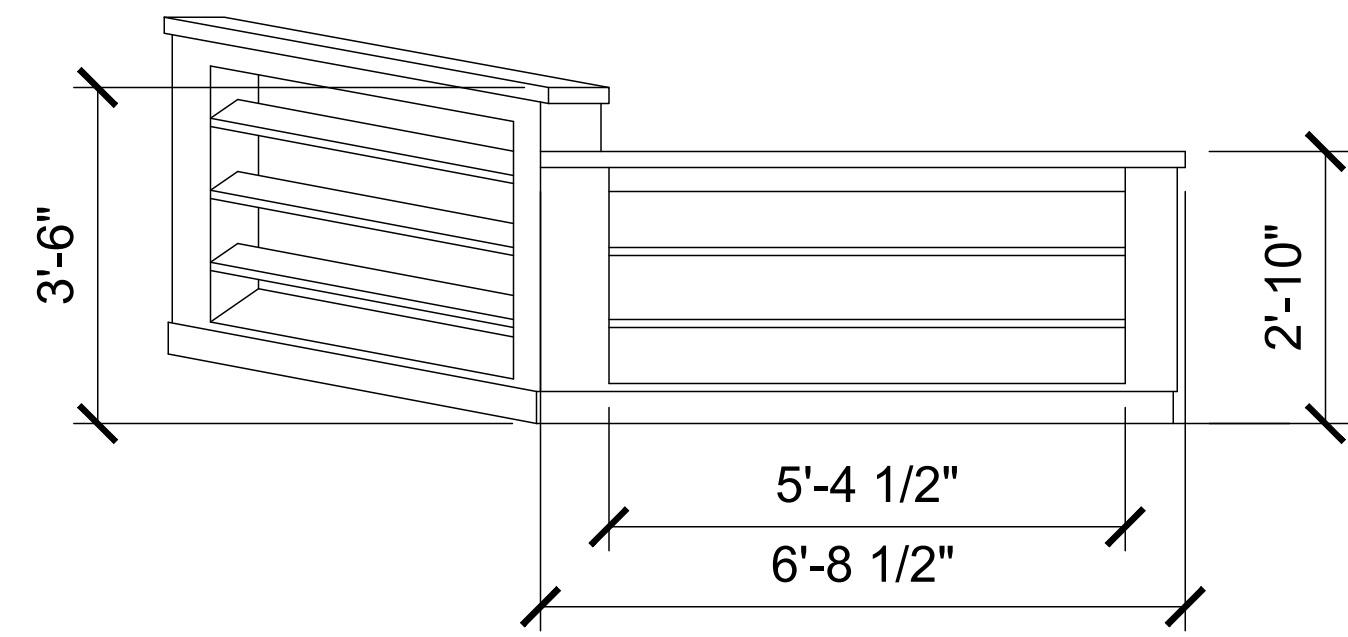


3 EXISTING RIGHT COUNTER ELEVATION

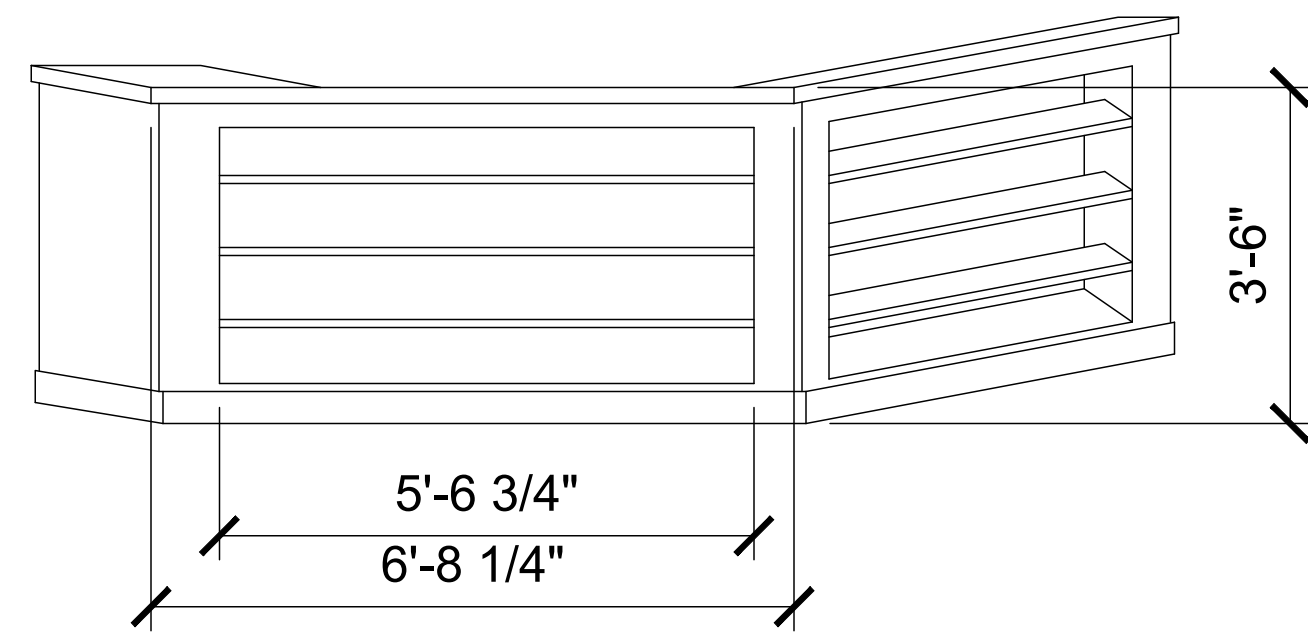


5 EXISTING LEFT COUNTER ELEVATION

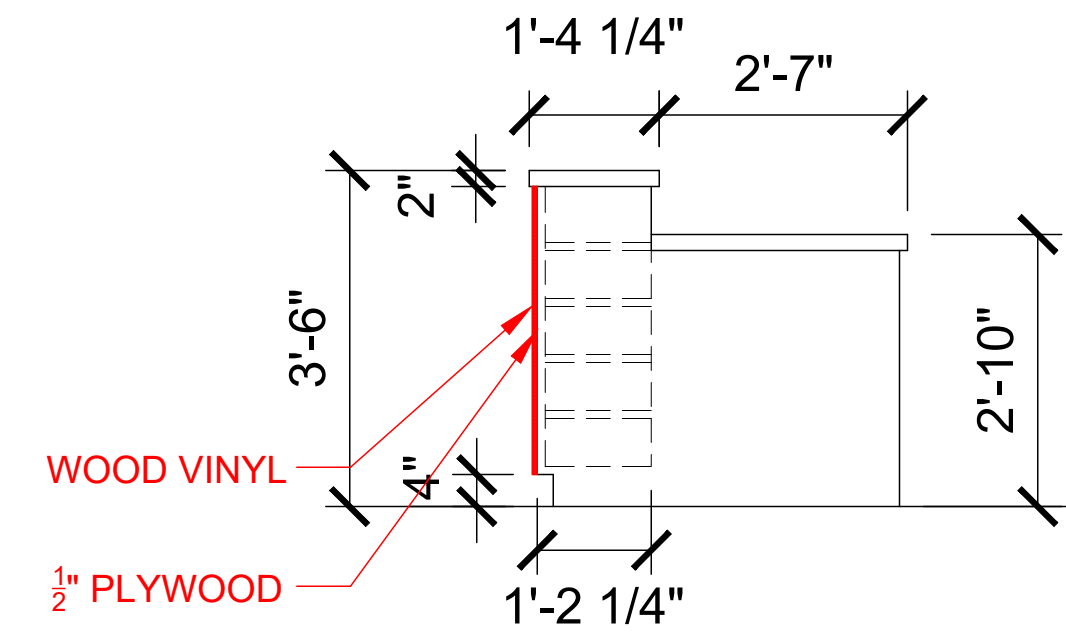


2 COUNTER SECTION DETAIL

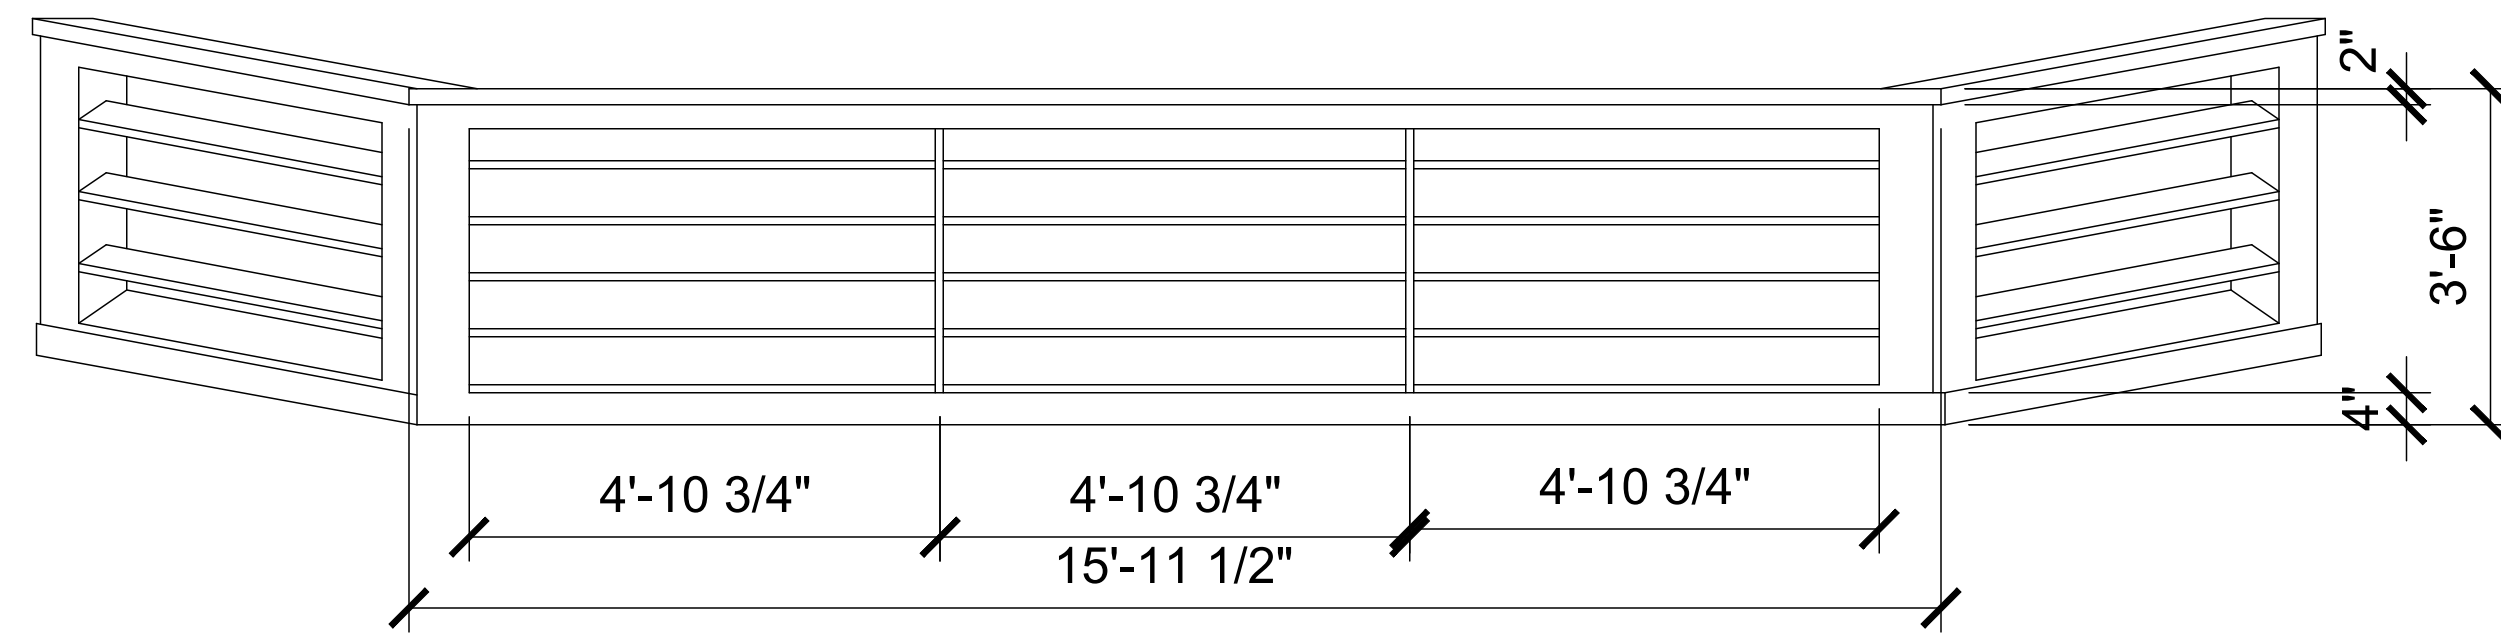


4 EXISTING FRONT COUNTER ELEVATION

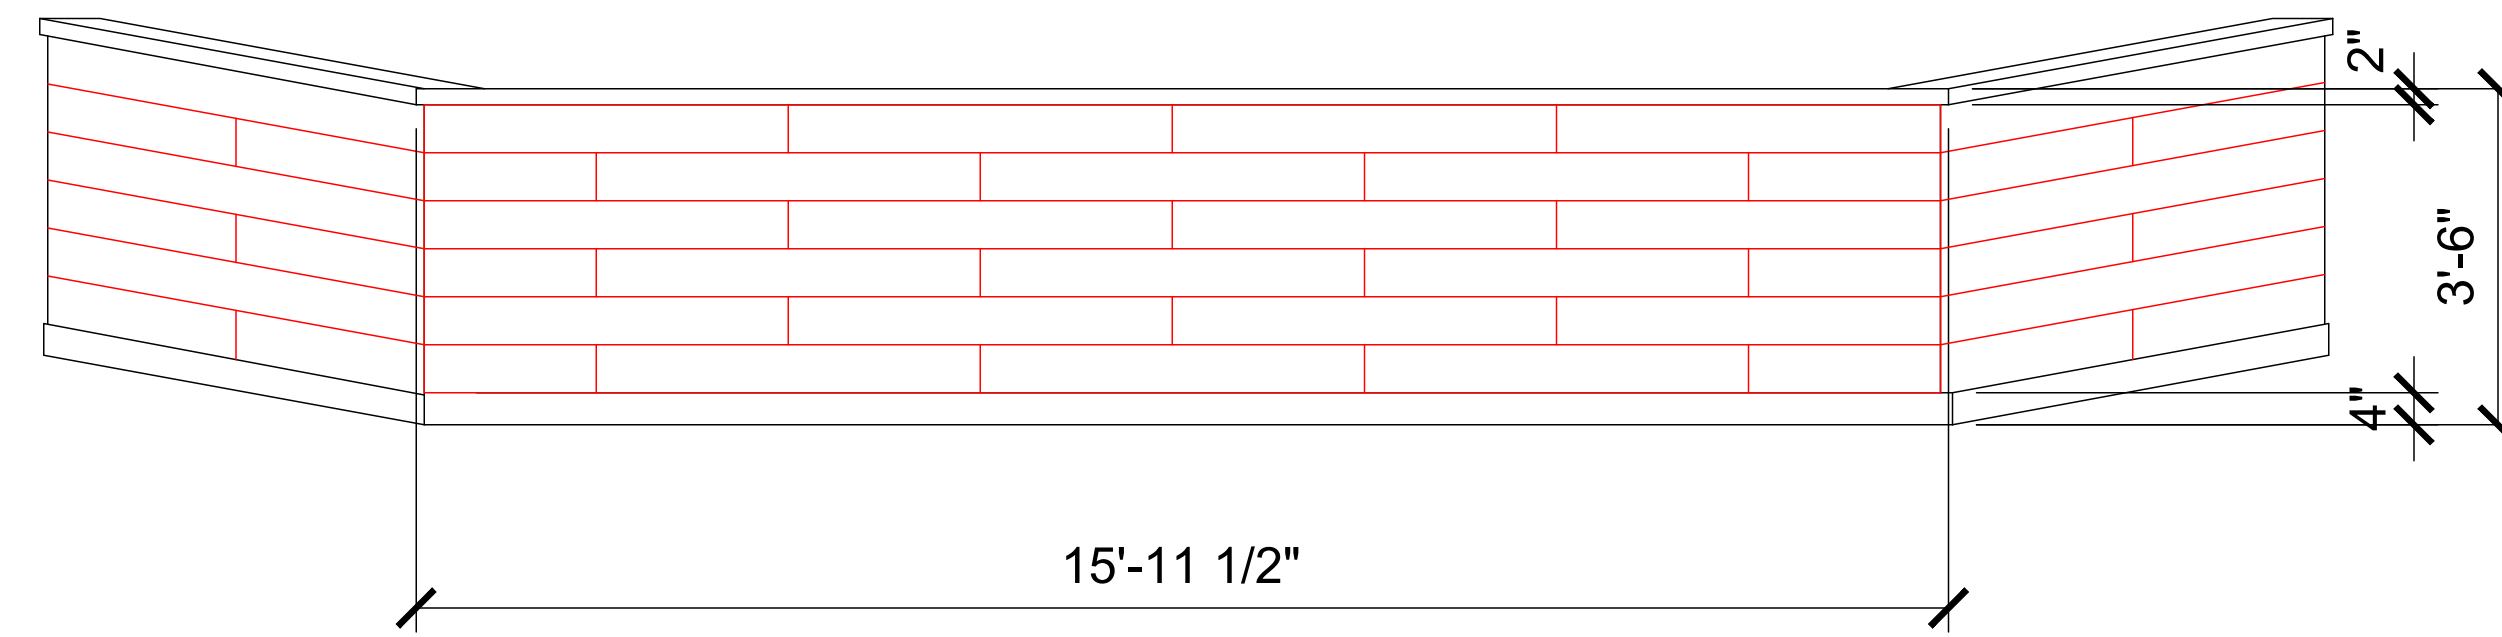


6 PROPOSED FRONT COUNTER ELEVATION

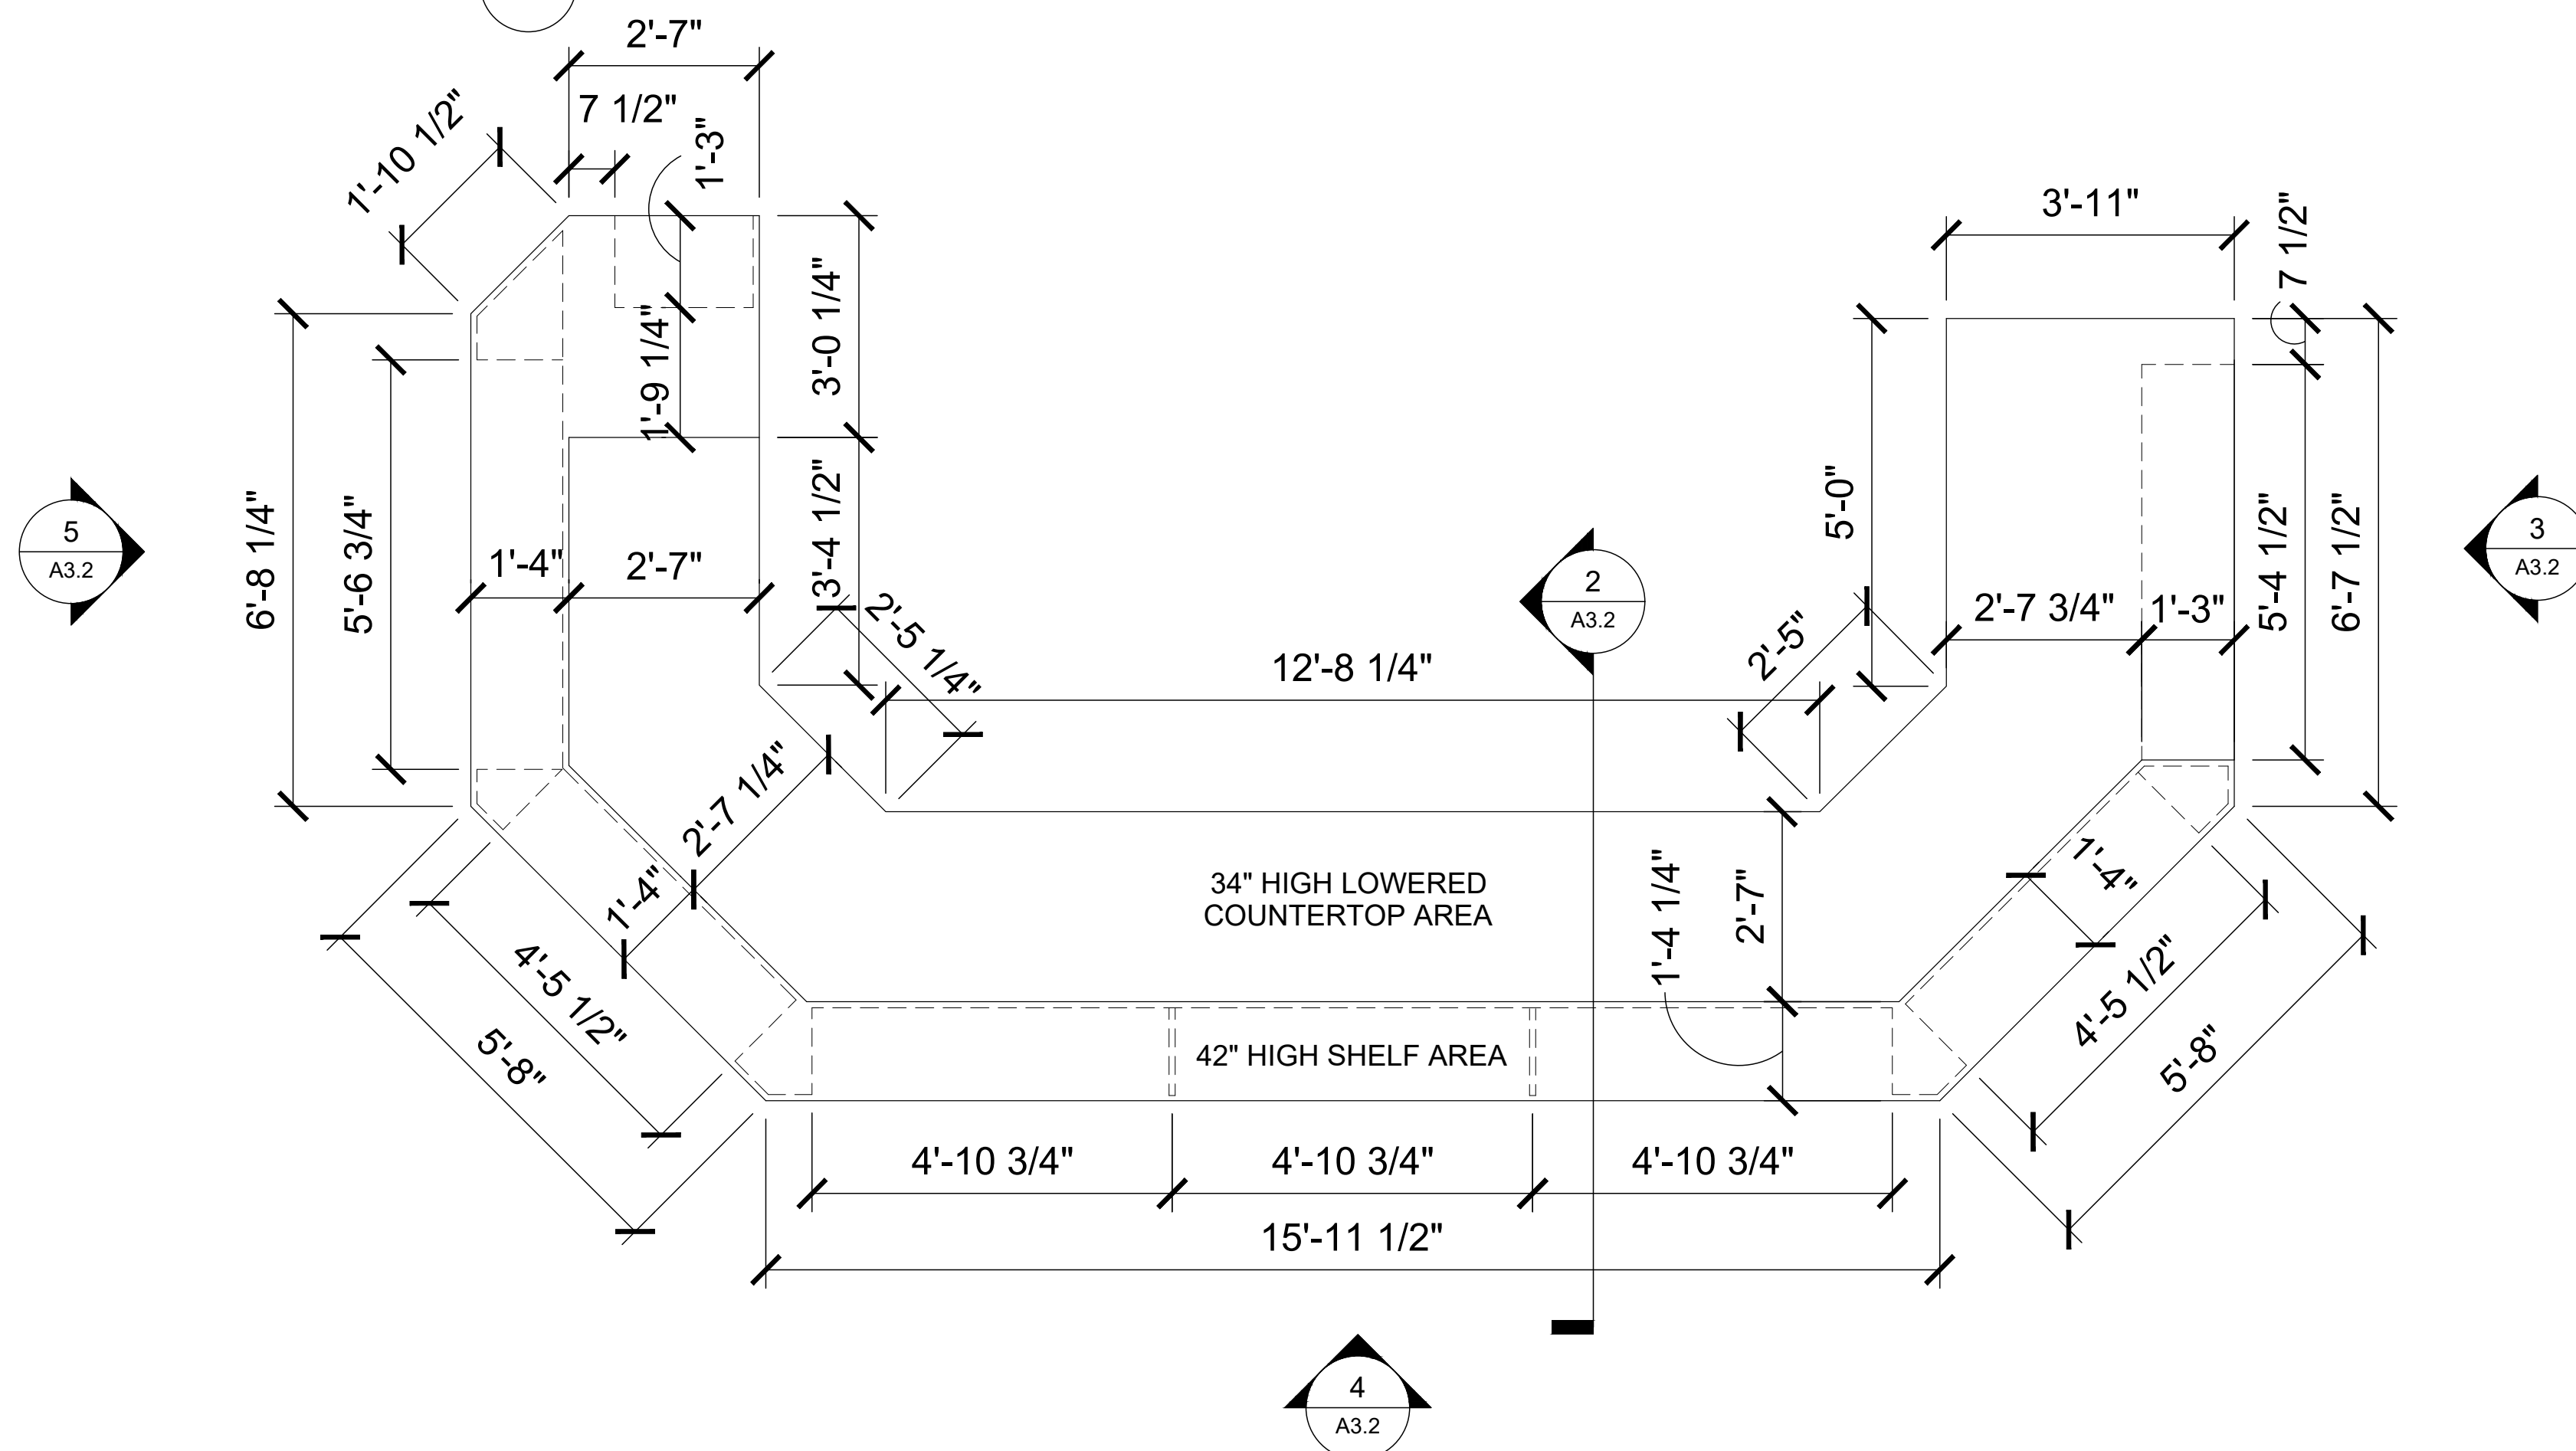

1 ENLARGED SALES COUNTER PLAN

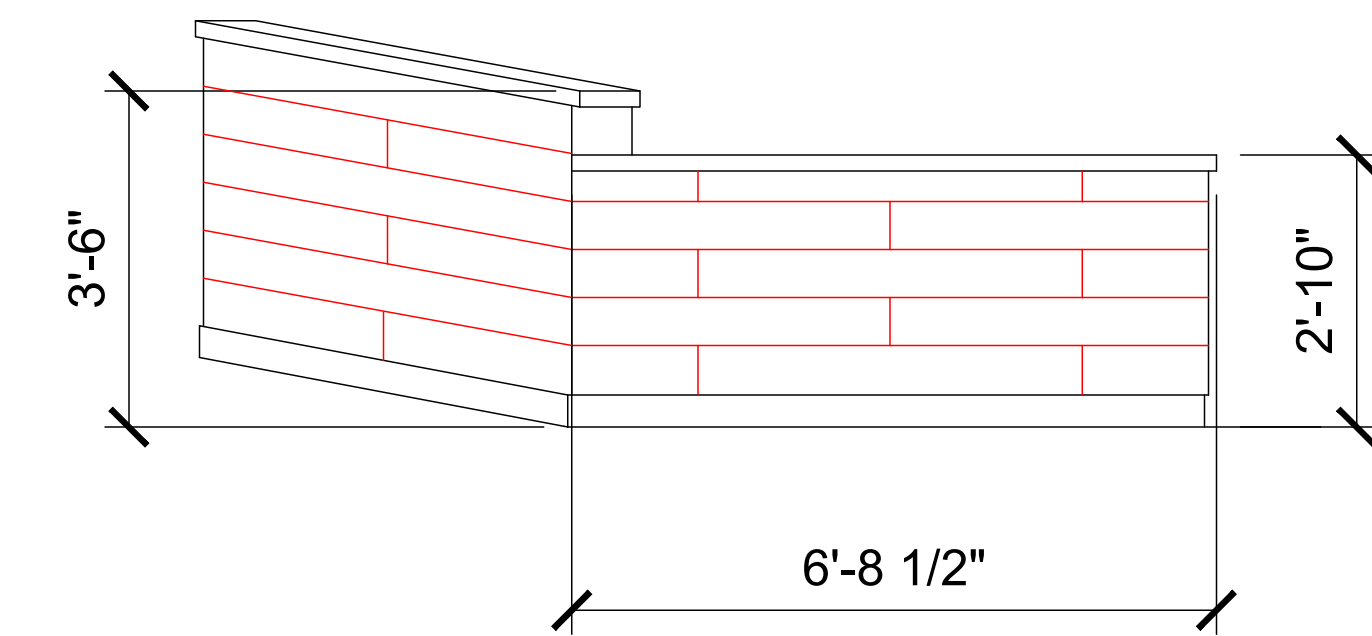

7 PROPOSED RIGHT COUNTER ELEVATION

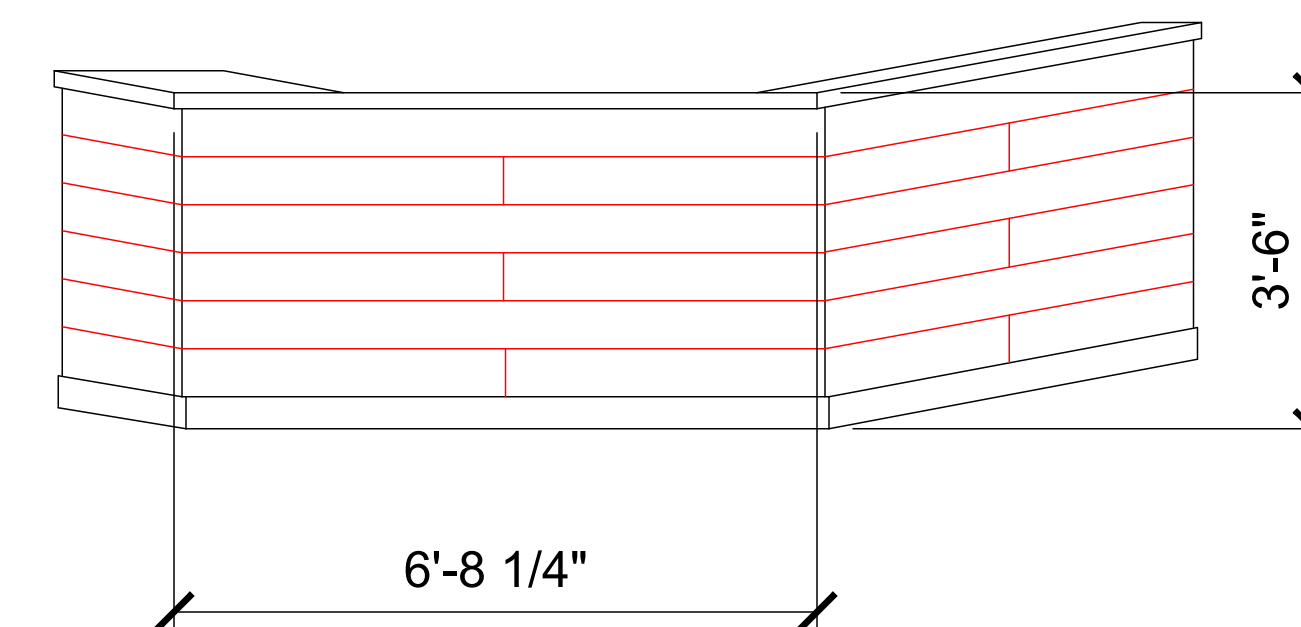

8 PROPOSED LEFT COUNTER ELEVATION




1450 N. Benson Ave.,
Upland, CA 91786 USA
www.anabioli.com - (909) 394-4728

PAGE:	A3.2	SCALE:	1/2" = 1'-0"
DESIGNER:	DV	DATE:	02-05-2025
REVISION #:	32	STORE #:	868

PROJECT FILE NAME:	REBEL REMODEL WITH DRIVE-THRU & GAMING
PROJECT ADDRESS:	1300 W. NORMANTOWN RD. ROMEOVILLE, IL



- LINE TYPE LEGEND
- NEW CONDITIONS
 - RELOCATE EXISTING CONDITIONS (WITHIN STORE)
 - RELOCATE EXISTING CONDITIONS (ANOTHER OUTSIDE LOCATION)
 - EXISTING CONDITIONS

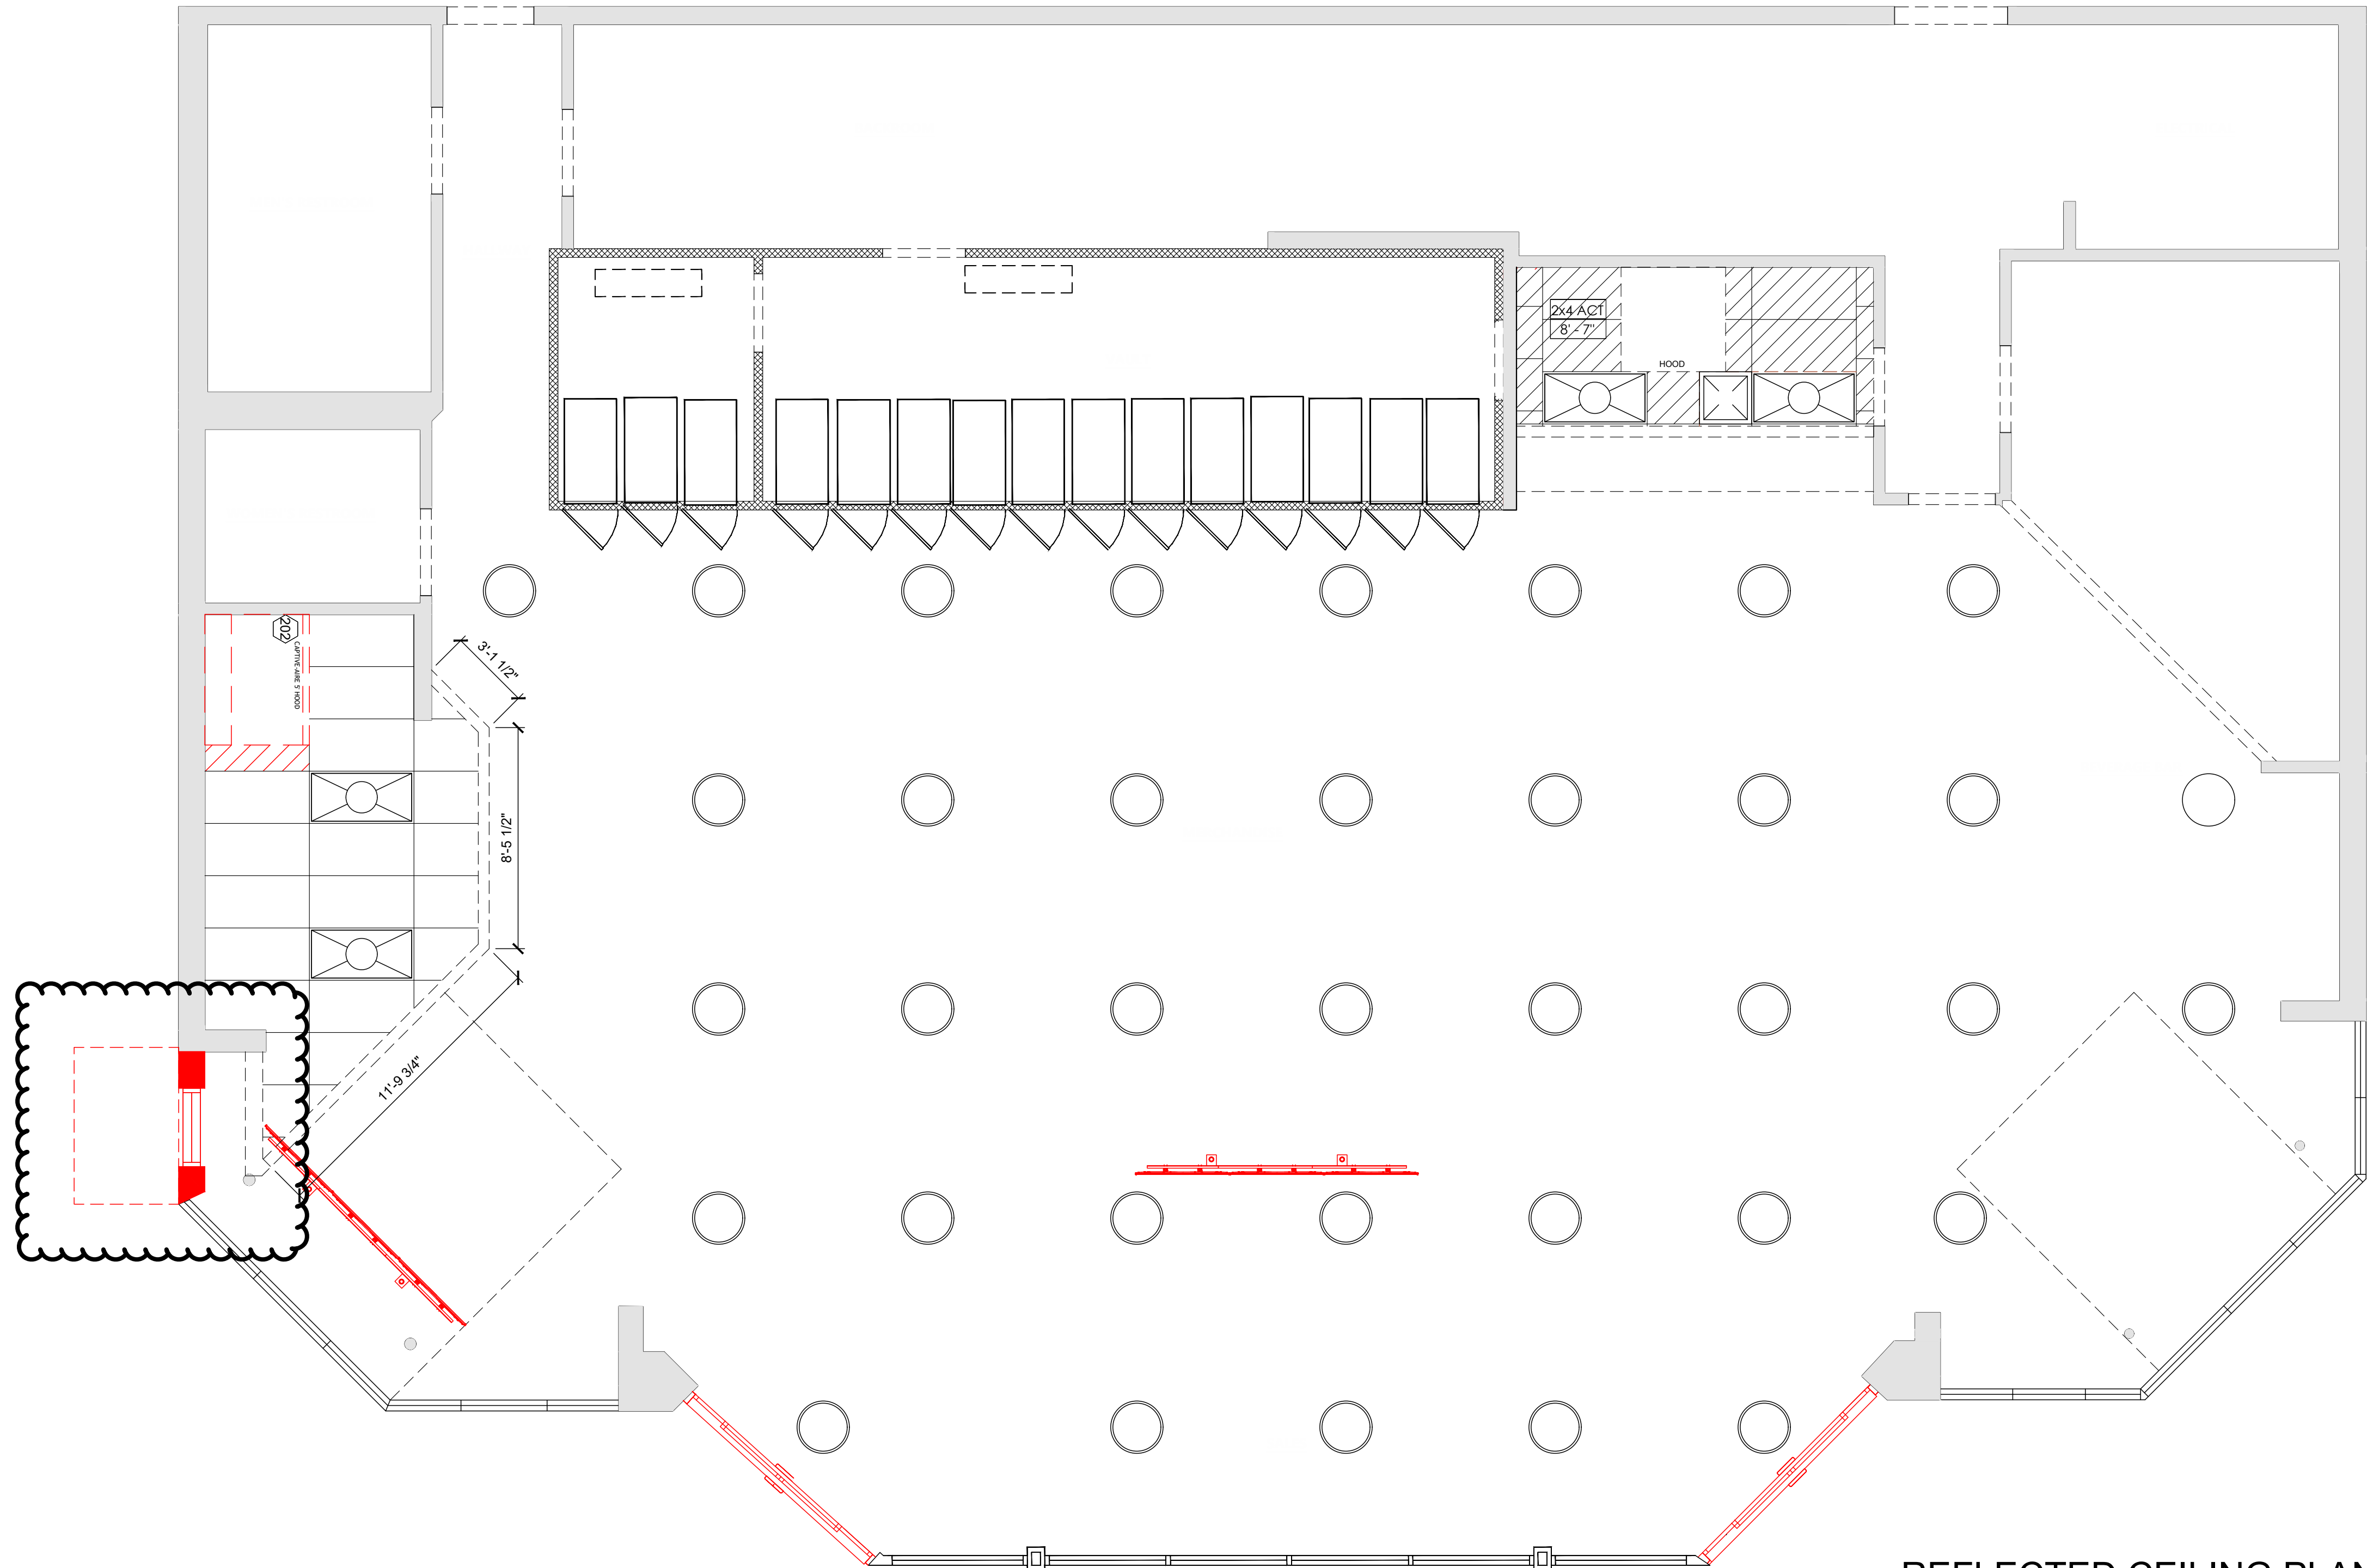


RCP LIGHTING SCHEDULE & LEGEND				
SYMBOL	QTY	MRF	MODEL	DESCRIPTION
	SEE PLAN			NEW ACOUSTICAL TILE AND GRID TO MATCH EXISTING
	36	--	N/A	EXISTING SUSPENDED BAY AREA LIGHT FIXTURE TO REMAIN
	4	--	N/A	EXISTING 2X4 RECESSED LIGHT FIXTURE TO REMAIN
	6	--	N/A	NEW CEILING MOUNTED DIGITAL MENU BOARDS





1450 N. Benson Ave.,
Upland, CA 91786 USA
www.anabioli.com - (909) 394-4728


PAGE:	A4.0	SCALE:	1/4" = 1'-0"
DESIGNER:	DV	DATE:	02-05-2025
REVISION #:	32	STORE #:	868

PROJECT FILE NAME:	REBEL REMODEL WITH DRIVE-THRU & GAMING
PROJECT ADDRESS:	1300 W. NORMANTOWN RD. ROMEOVILLE, IL

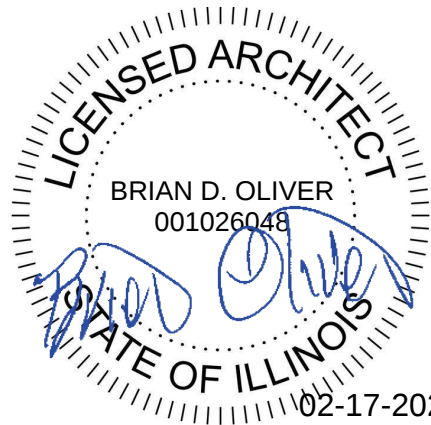

1 REFLECTED CEILING PLAN

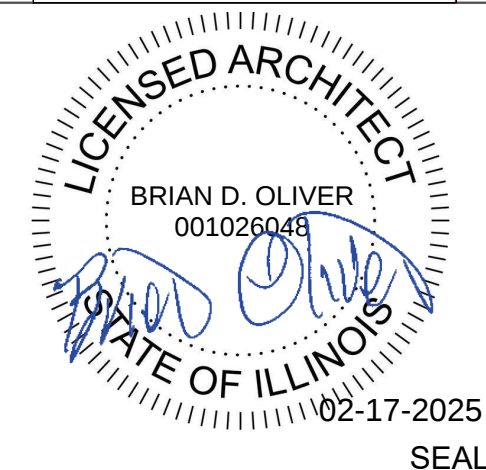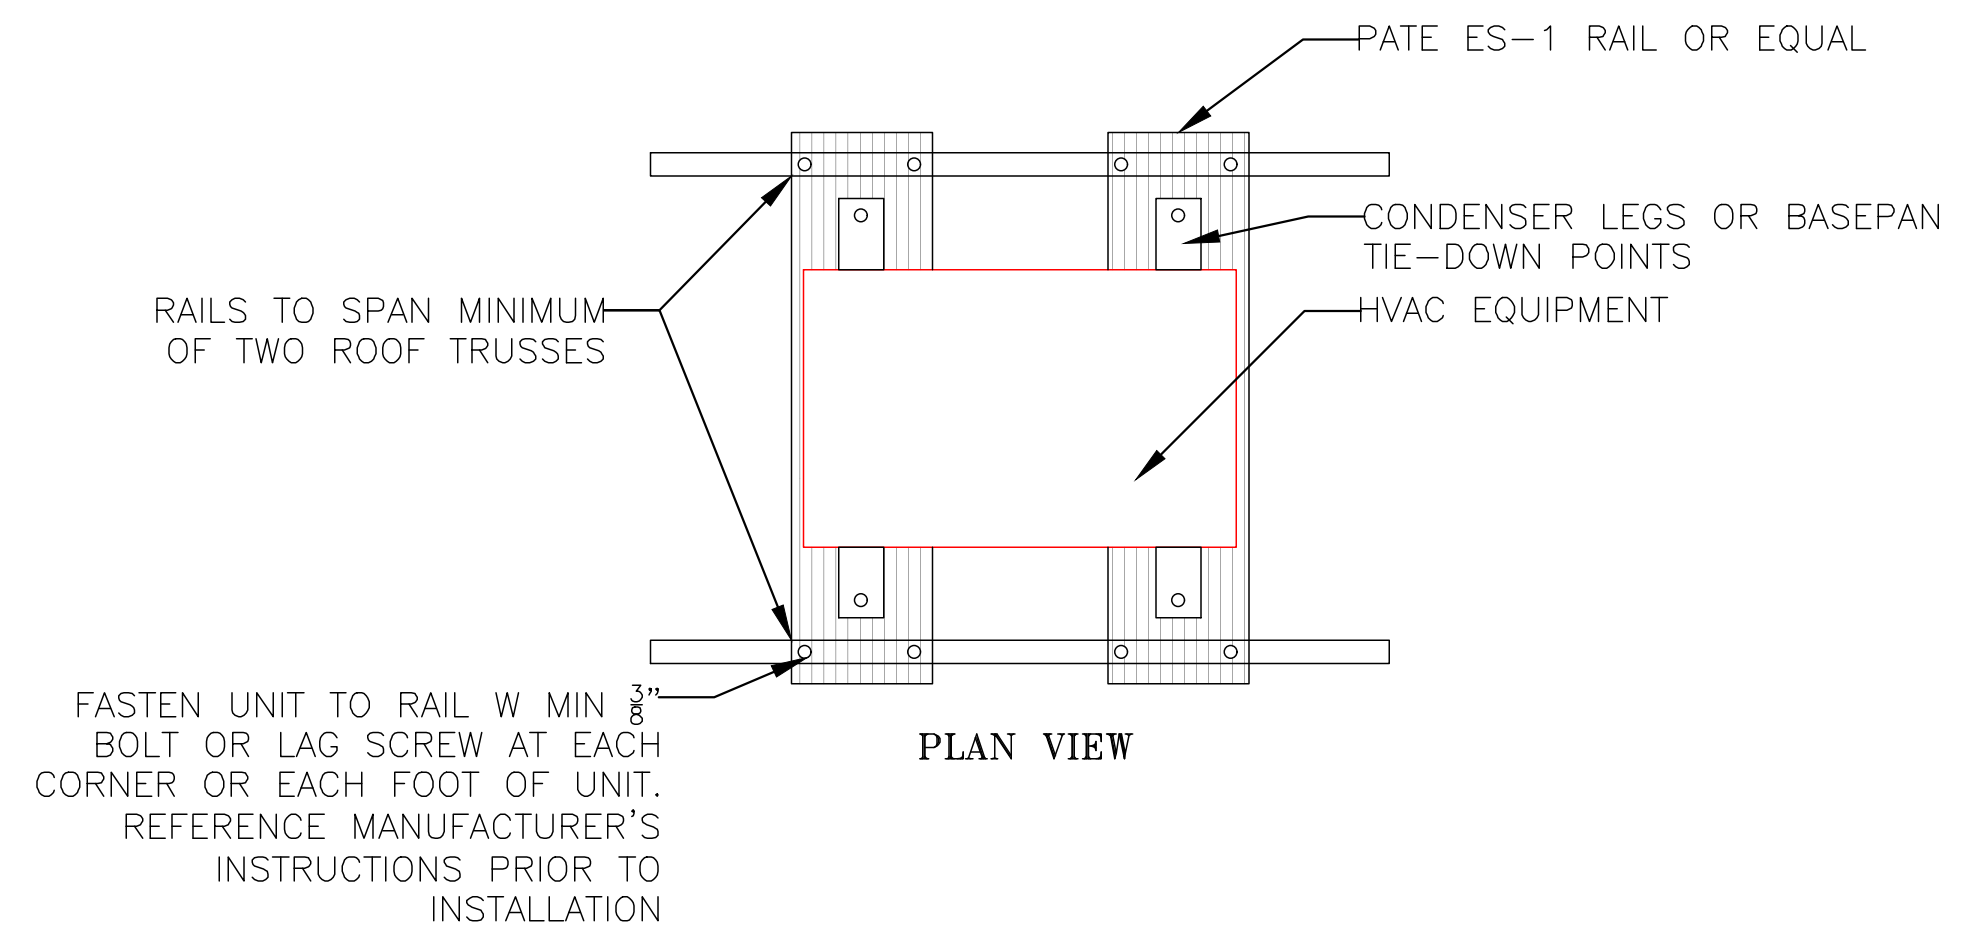

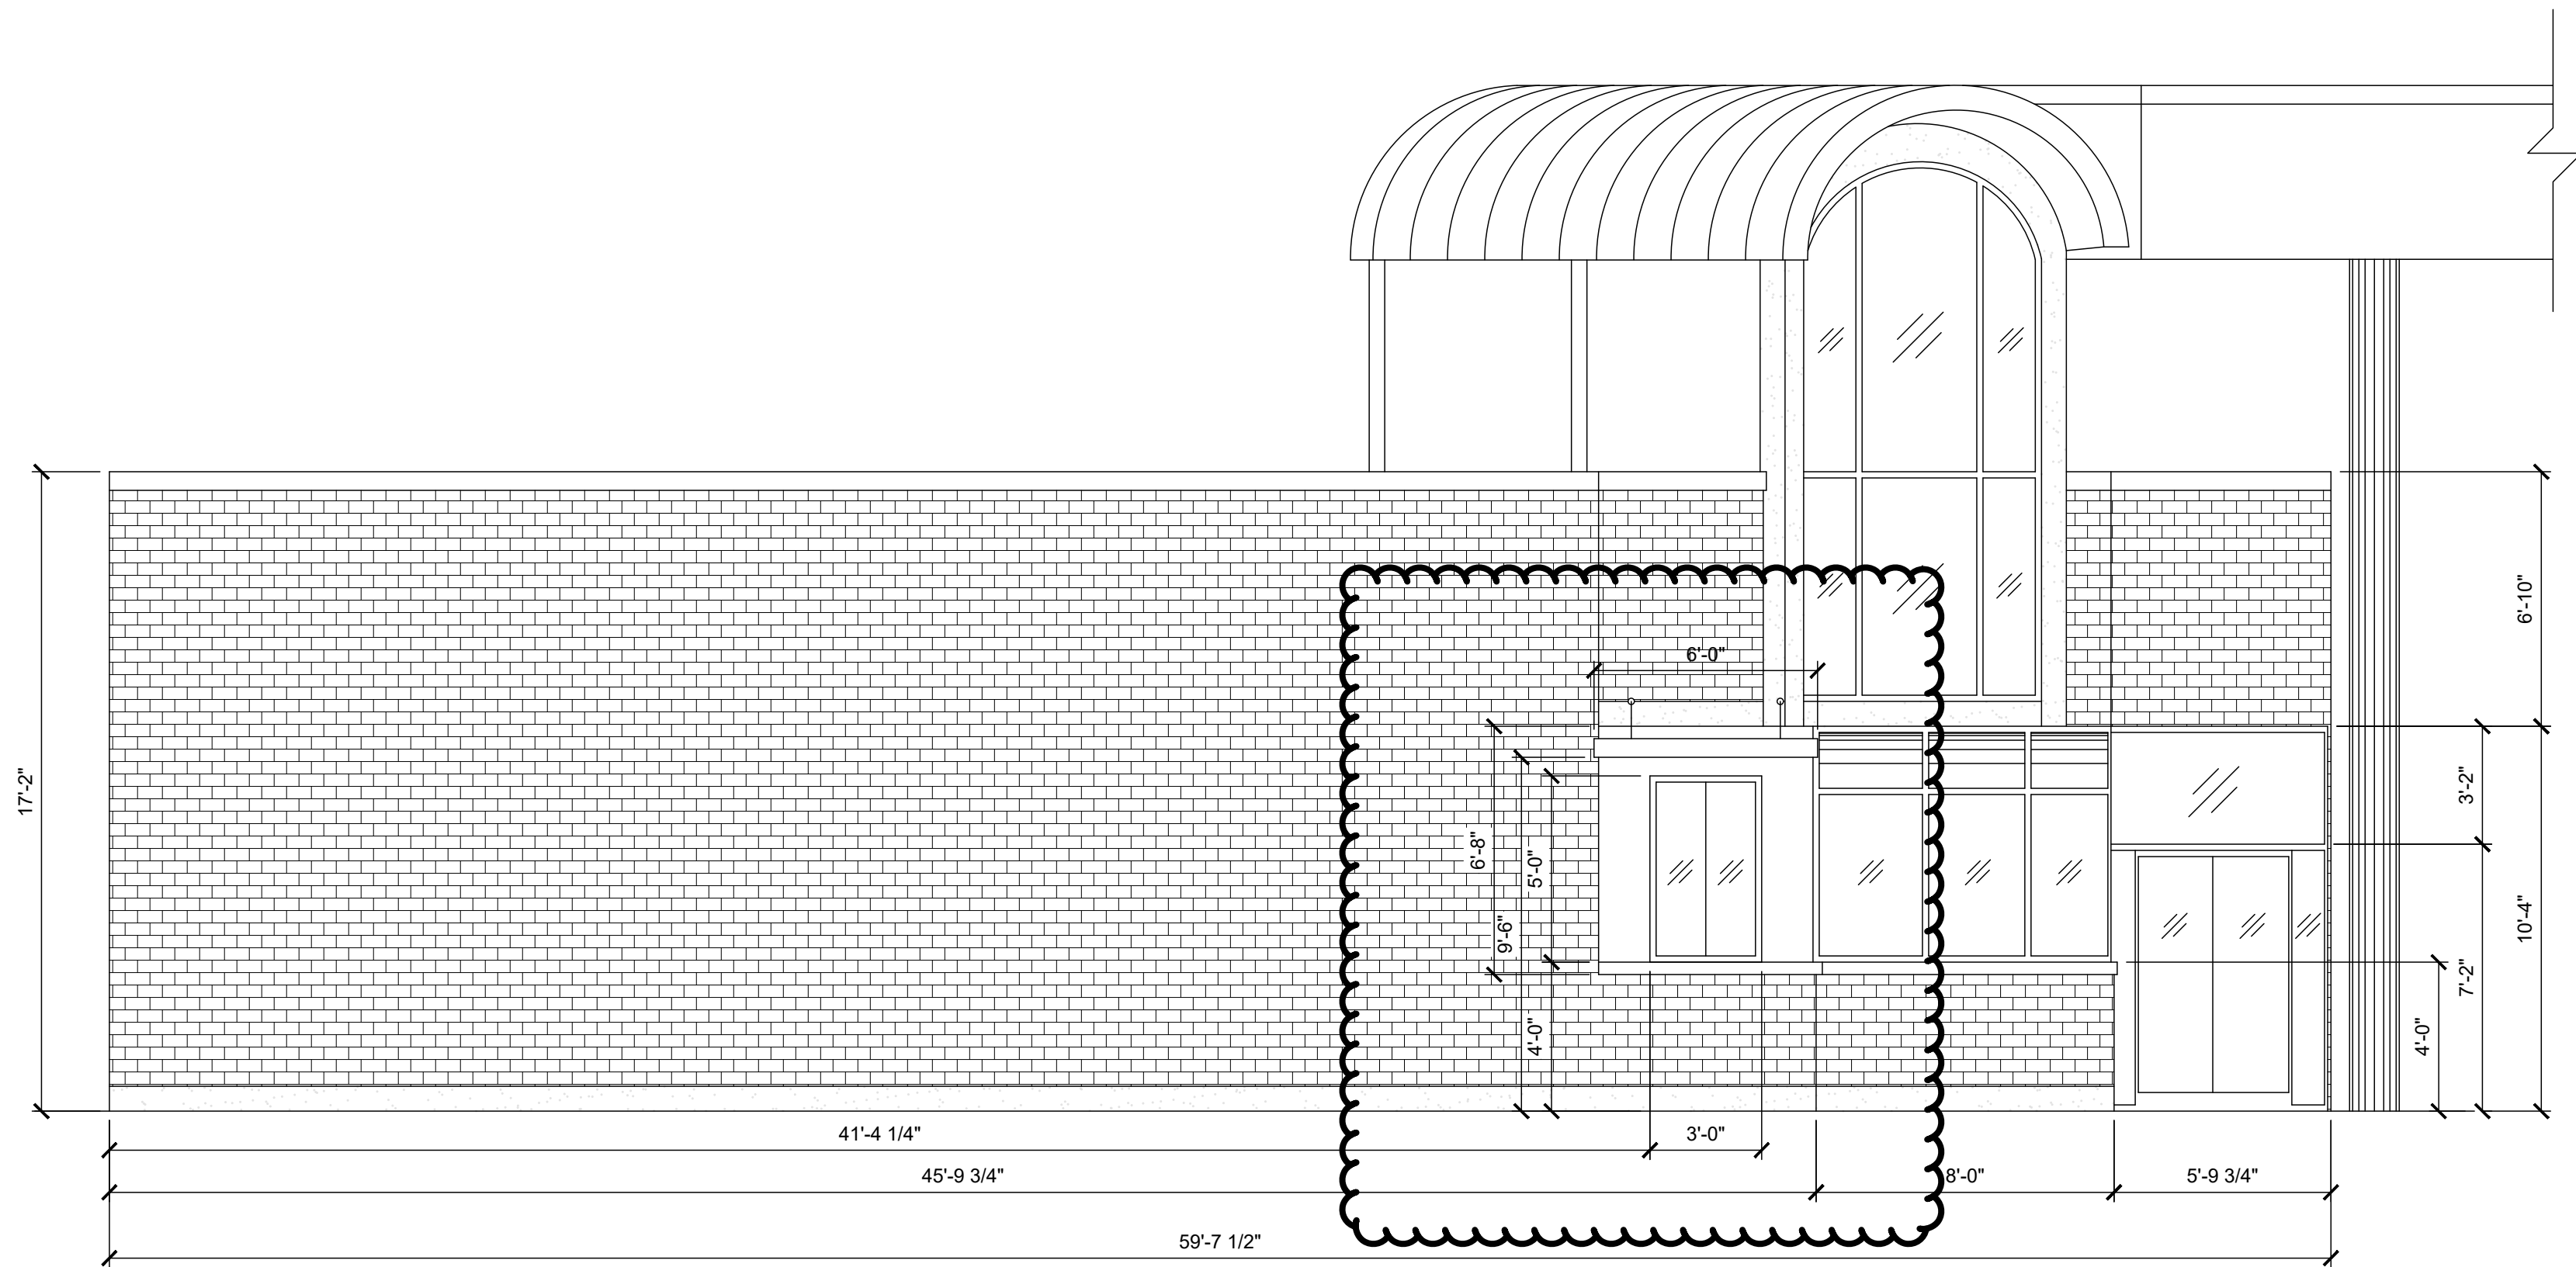


1 PROPOSED LEFT ELEVATION



1450 N. Benson Ave.,
Upland, CA 91786 USA
www.anabioli.com - (909) 394-4728

PROJECT FILE NAME:	REVISION #:	DESIGNER:	PAGE:
REBEL REMODEL WITH DRIVE-THRU & GAMING	32	DV	A6.0
PROJECT ADDRESS:	STORE #:	DATE:	SCALE:
1300 W. NORMANTOWN RD. ROMEOVILLE, IL	868	02-05-2025	1/4" = 1'-0"

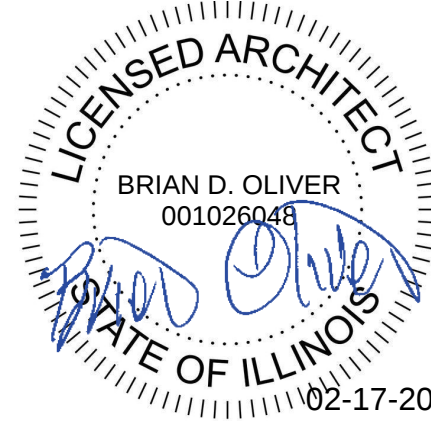

SEAL



A



H-1


$$1/4" = 1'-0"$$
