



Renwick Place
2060 W. Helen Drive
Romeoville, IL
William Ryan Homes



PROJECT NO. 17-0000000000
DATE: 11-30-2017
SHEET NO. 17-0000000000


LOT 005
Focham II
A3.1A

CONSTRUCTION ASSEMBLIES:


1. EXTERIOR WALLS: REFER TO THE SPECIFICATIONS FOR THE FOLLOWING ASSEMBLIES:
 - A. SOFT CONCRETE: CONCRETE ON ROOF PANELS ON ROOF TRUSSES. EXTERIOR FINISH: STUCCO. INTERIOR FINISH: GYP. BOARD. INSULATION: 2" POLYSTYRENE INSULATION BOARD.
 - B. EXTERIOR WALLS: 8" CMU. EXTERIOR FINISH: STUCCO. INTERIOR FINISH: GYP. BOARD. INSULATION: 2" POLYSTYRENE INSULATION BOARD.
 - C. EXTERIOR WALLS: 8" CMU. EXTERIOR FINISH: STUCCO. INTERIOR FINISH: GYP. BOARD. INSULATION: 2" POLYSTYRENE INSULATION BOARD.
 - D. EXTERIOR WALLS: 8" CMU. EXTERIOR FINISH: STUCCO. INTERIOR FINISH: GYP. BOARD. INSULATION: 2" POLYSTYRENE INSULATION BOARD.
2. EXTERIOR WALLS: REFER TO THE SPECIFICATIONS FOR THE FOLLOWING ASSEMBLIES:
 - A. SOFT CONCRETE: CONCRETE ON ROOF PANELS ON ROOF TRUSSES. EXTERIOR FINISH: STUCCO. INTERIOR FINISH: GYP. BOARD. INSULATION: 2" POLYSTYRENE INSULATION BOARD.
 - B. EXTERIOR WALLS: 8" CMU. EXTERIOR FINISH: STUCCO. INTERIOR FINISH: GYP. BOARD. INSULATION: 2" POLYSTYRENE INSULATION BOARD.
 - C. EXTERIOR WALLS: 8" CMU. EXTERIOR FINISH: STUCCO. INTERIOR FINISH: GYP. BOARD. INSULATION: 2" POLYSTYRENE INSULATION BOARD.
 - D. EXTERIOR WALLS: 8" CMU. EXTERIOR FINISH: STUCCO. INTERIOR FINISH: GYP. BOARD. INSULATION: 2" POLYSTYRENE INSULATION BOARD.
3. EXTERIOR WALLS: REFER TO THE SPECIFICATIONS FOR THE FOLLOWING ASSEMBLIES:
 - A. SOFT CONCRETE: CONCRETE ON ROOF PANELS ON ROOF TRUSSES. EXTERIOR FINISH: STUCCO. INTERIOR FINISH: GYP. BOARD. INSULATION: 2" POLYSTYRENE INSULATION BOARD.
 - B. EXTERIOR WALLS: 8" CMU. EXTERIOR FINISH: STUCCO. INTERIOR FINISH: GYP. BOARD. INSULATION: 2" POLYSTYRENE INSULATION BOARD.
 - C. EXTERIOR WALLS: 8" CMU. EXTERIOR FINISH: STUCCO. INTERIOR FINISH: GYP. BOARD. INSULATION: 2" POLYSTYRENE INSULATION BOARD.
 - D. EXTERIOR WALLS: 8" CMU. EXTERIOR FINISH: STUCCO. INTERIOR FINISH: GYP. BOARD. INSULATION: 2" POLYSTYRENE INSULATION BOARD.
4. EXTERIOR WALLS: REFER TO THE SPECIFICATIONS FOR THE FOLLOWING ASSEMBLIES:
 - A. SOFT CONCRETE: CONCRETE ON ROOF PANELS ON ROOF TRUSSES. EXTERIOR FINISH: STUCCO. INTERIOR FINISH: GYP. BOARD. INSULATION: 2" POLYSTYRENE INSULATION BOARD.
 - B. EXTERIOR WALLS: 8" CMU. EXTERIOR FINISH: STUCCO. INTERIOR FINISH: GYP. BOARD. INSULATION: 2" POLYSTYRENE INSULATION BOARD.
 - C. EXTERIOR WALLS: 8" CMU. EXTERIOR FINISH: STUCCO. INTERIOR FINISH: GYP. BOARD. INSULATION: 2" POLYSTYRENE INSULATION BOARD.
 - D. EXTERIOR WALLS: 8" CMU. EXTERIOR FINISH: STUCCO. INTERIOR FINISH: GYP. BOARD. INSULATION: 2" POLYSTYRENE INSULATION BOARD.

GENERAL EXTERIOR ELEVATION NOTES:


- 1. GRADE CONDITIONS MAY VARY FOR THIS PROJECT. THE ARCHITECT SHALL PROVIDE THE GRADE CONDITIONS FOR THE EXTERIOR WALLS. THE ARCHITECT SHALL PROVIDE THE GRADE CONDITIONS FOR THE EXTERIOR WALLS. THE ARCHITECT SHALL PROVIDE THE GRADE CONDITIONS FOR THE EXTERIOR WALLS.
- 2. THE ARCHITECT SHALL PROVIDE THE GRADE CONDITIONS FOR THE EXTERIOR WALLS. THE ARCHITECT SHALL PROVIDE THE GRADE CONDITIONS FOR THE EXTERIOR WALLS. THE ARCHITECT SHALL PROVIDE THE GRADE CONDITIONS FOR THE EXTERIOR WALLS.
- 3. THE ARCHITECT SHALL PROVIDE THE GRADE CONDITIONS FOR THE EXTERIOR WALLS. THE ARCHITECT SHALL PROVIDE THE GRADE CONDITIONS FOR THE EXTERIOR WALLS. THE ARCHITECT SHALL PROVIDE THE GRADE CONDITIONS FOR THE EXTERIOR WALLS.
- 4. THE ARCHITECT SHALL PROVIDE THE GRADE CONDITIONS FOR THE EXTERIOR WALLS. THE ARCHITECT SHALL PROVIDE THE GRADE CONDITIONS FOR THE EXTERIOR WALLS. THE ARCHITECT SHALL PROVIDE THE GRADE CONDITIONS FOR THE EXTERIOR WALLS.

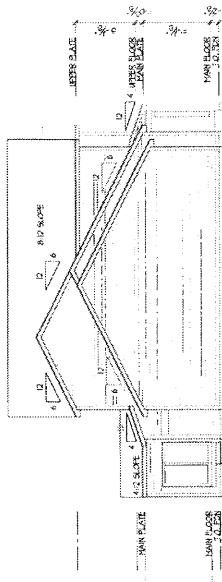

Left Elevation
SCALE: 1/8" = 1'-0" (2224) (18" x 12" BATT)

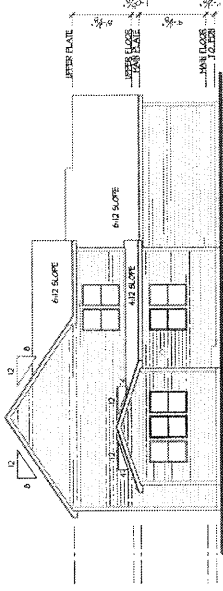


Rear Elevation
SCALE: 1/8" = 1'-0" (2224) (18" x 12" BATT)

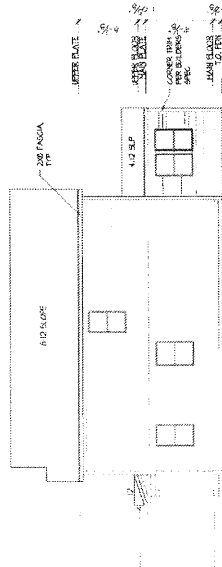


Right Elevation
SCALE: 1/8" = 1'-0" (2224) (18" x 12" BATT)

ATTIC VENTILATION SCHEDULE									
AREA	WALL AREA (SQ. FT.)	WALL AREA (SQ. FT.)	WALL AREA (SQ. FT.)	WALL AREA (SQ. FT.)	WALL AREA (SQ. FT.)	WALL AREA (SQ. FT.)	WALL AREA (SQ. FT.)	WALL AREA (SQ. FT.)	WALL AREA (SQ. FT.)
WALL AREA	2000	2000	2000	2000	2000	2000	2000	2000	2000
WALL AREA	2000	2000	2000	2000	2000	2000	2000	2000	2000
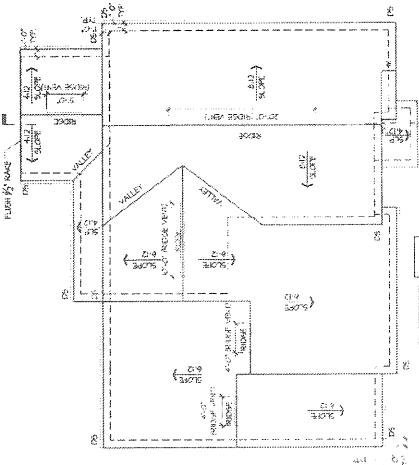


Roof Plan
SCALE: 1/8" = 1'-0" (2224) (18" x 12" BATT)

Colonial
Front Elevation
SCALE: 1/8" = 1'-0" (2224) (18" x 12" BATT)

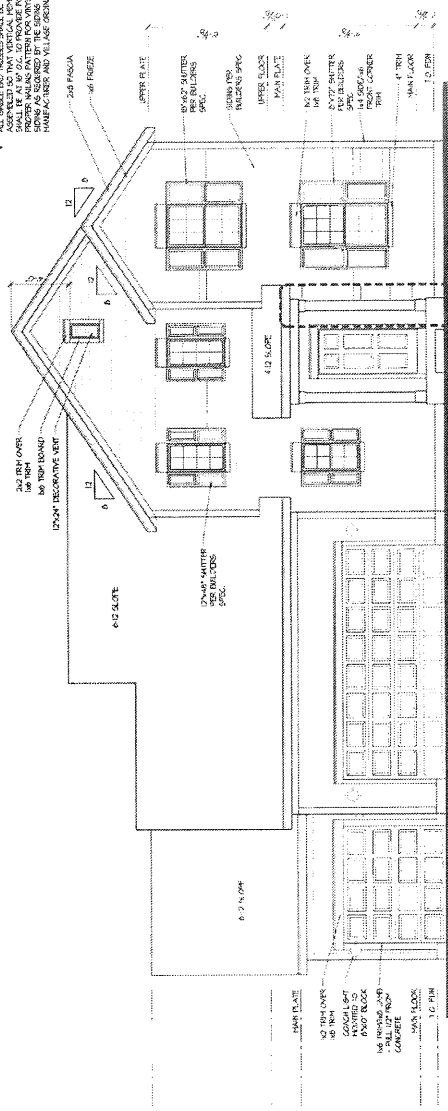



 Renwick Place
2060 W. Helen Drive
Romeoville, IL
William Ryan Homes



10-10 CHERRY BLVD
 HAWAII, HAWAII 96704
 ALO 765 2250

LOT 005
Fordham II
A1.1A

Colonia

BOOTH BY APPOINTMENT

PLAN NOTES:

- [illegible]

FLOOR PLAN

KEYNOTES:

- THE FOLLOWING KEYNOTES
DIFFERENCE THE SYMBOLS AS
SACRED CH PLANS.


PLAN NOTES:

- [illegible]

CONSTRUCTION

ASSAULTS

- [illegible]

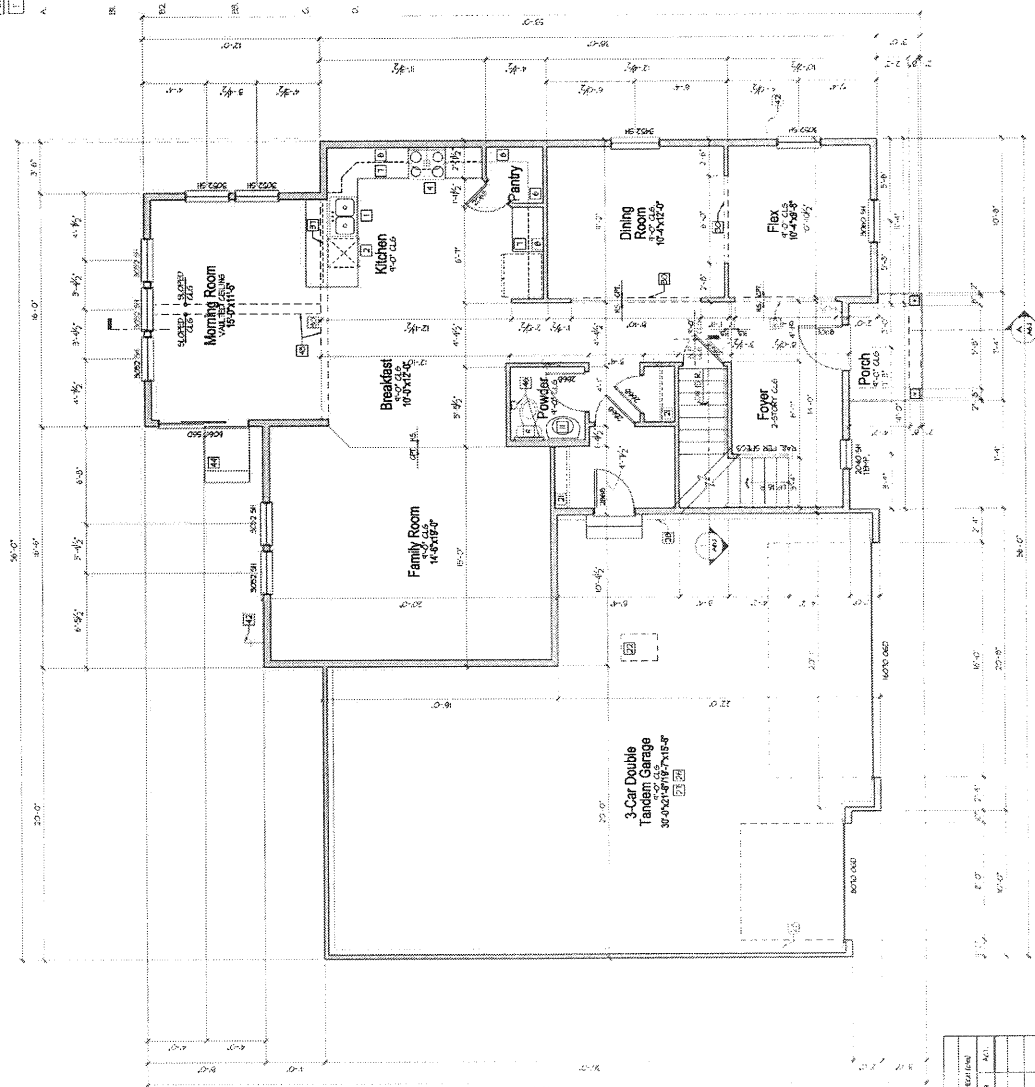

Main Floor Plan

ACR: E. 16° 27' 42.2304" N 95° 51' 23.1607" W

LIGHT AND VENTILATION SCHEDULE									
ROOM	AREA	LIGHT TIME			VENT TIME			MOIST TIME	
		REQ.	ACT.	REMARKS	REQ.	ACT.	REMARKS	REQ.	ACT.
PLANT ROOM	44	22.00	27.0	11.00	4.0			60%	
WATER TANK	26	22.00	11.00	15.00	18.0			60%	
WATER TANK	97	6.0	25.2	4.00	4.5			50	
WATER TANK	100	22.00	17.0	10.00	10.0			50	
WATER TANK	27	22.00	7.0	5.00	1.0			50	
WATER TANK	9	6.04	1.0	1.0	2.0			50	
WATER TANK	14	6.04	1.0	1.0	2.0			50	
WATER TANK	34	10.0						50	